





Reviewed for Code Compliance  
Inspection Division  
Approved with Conditions  
Date: 09/15/14

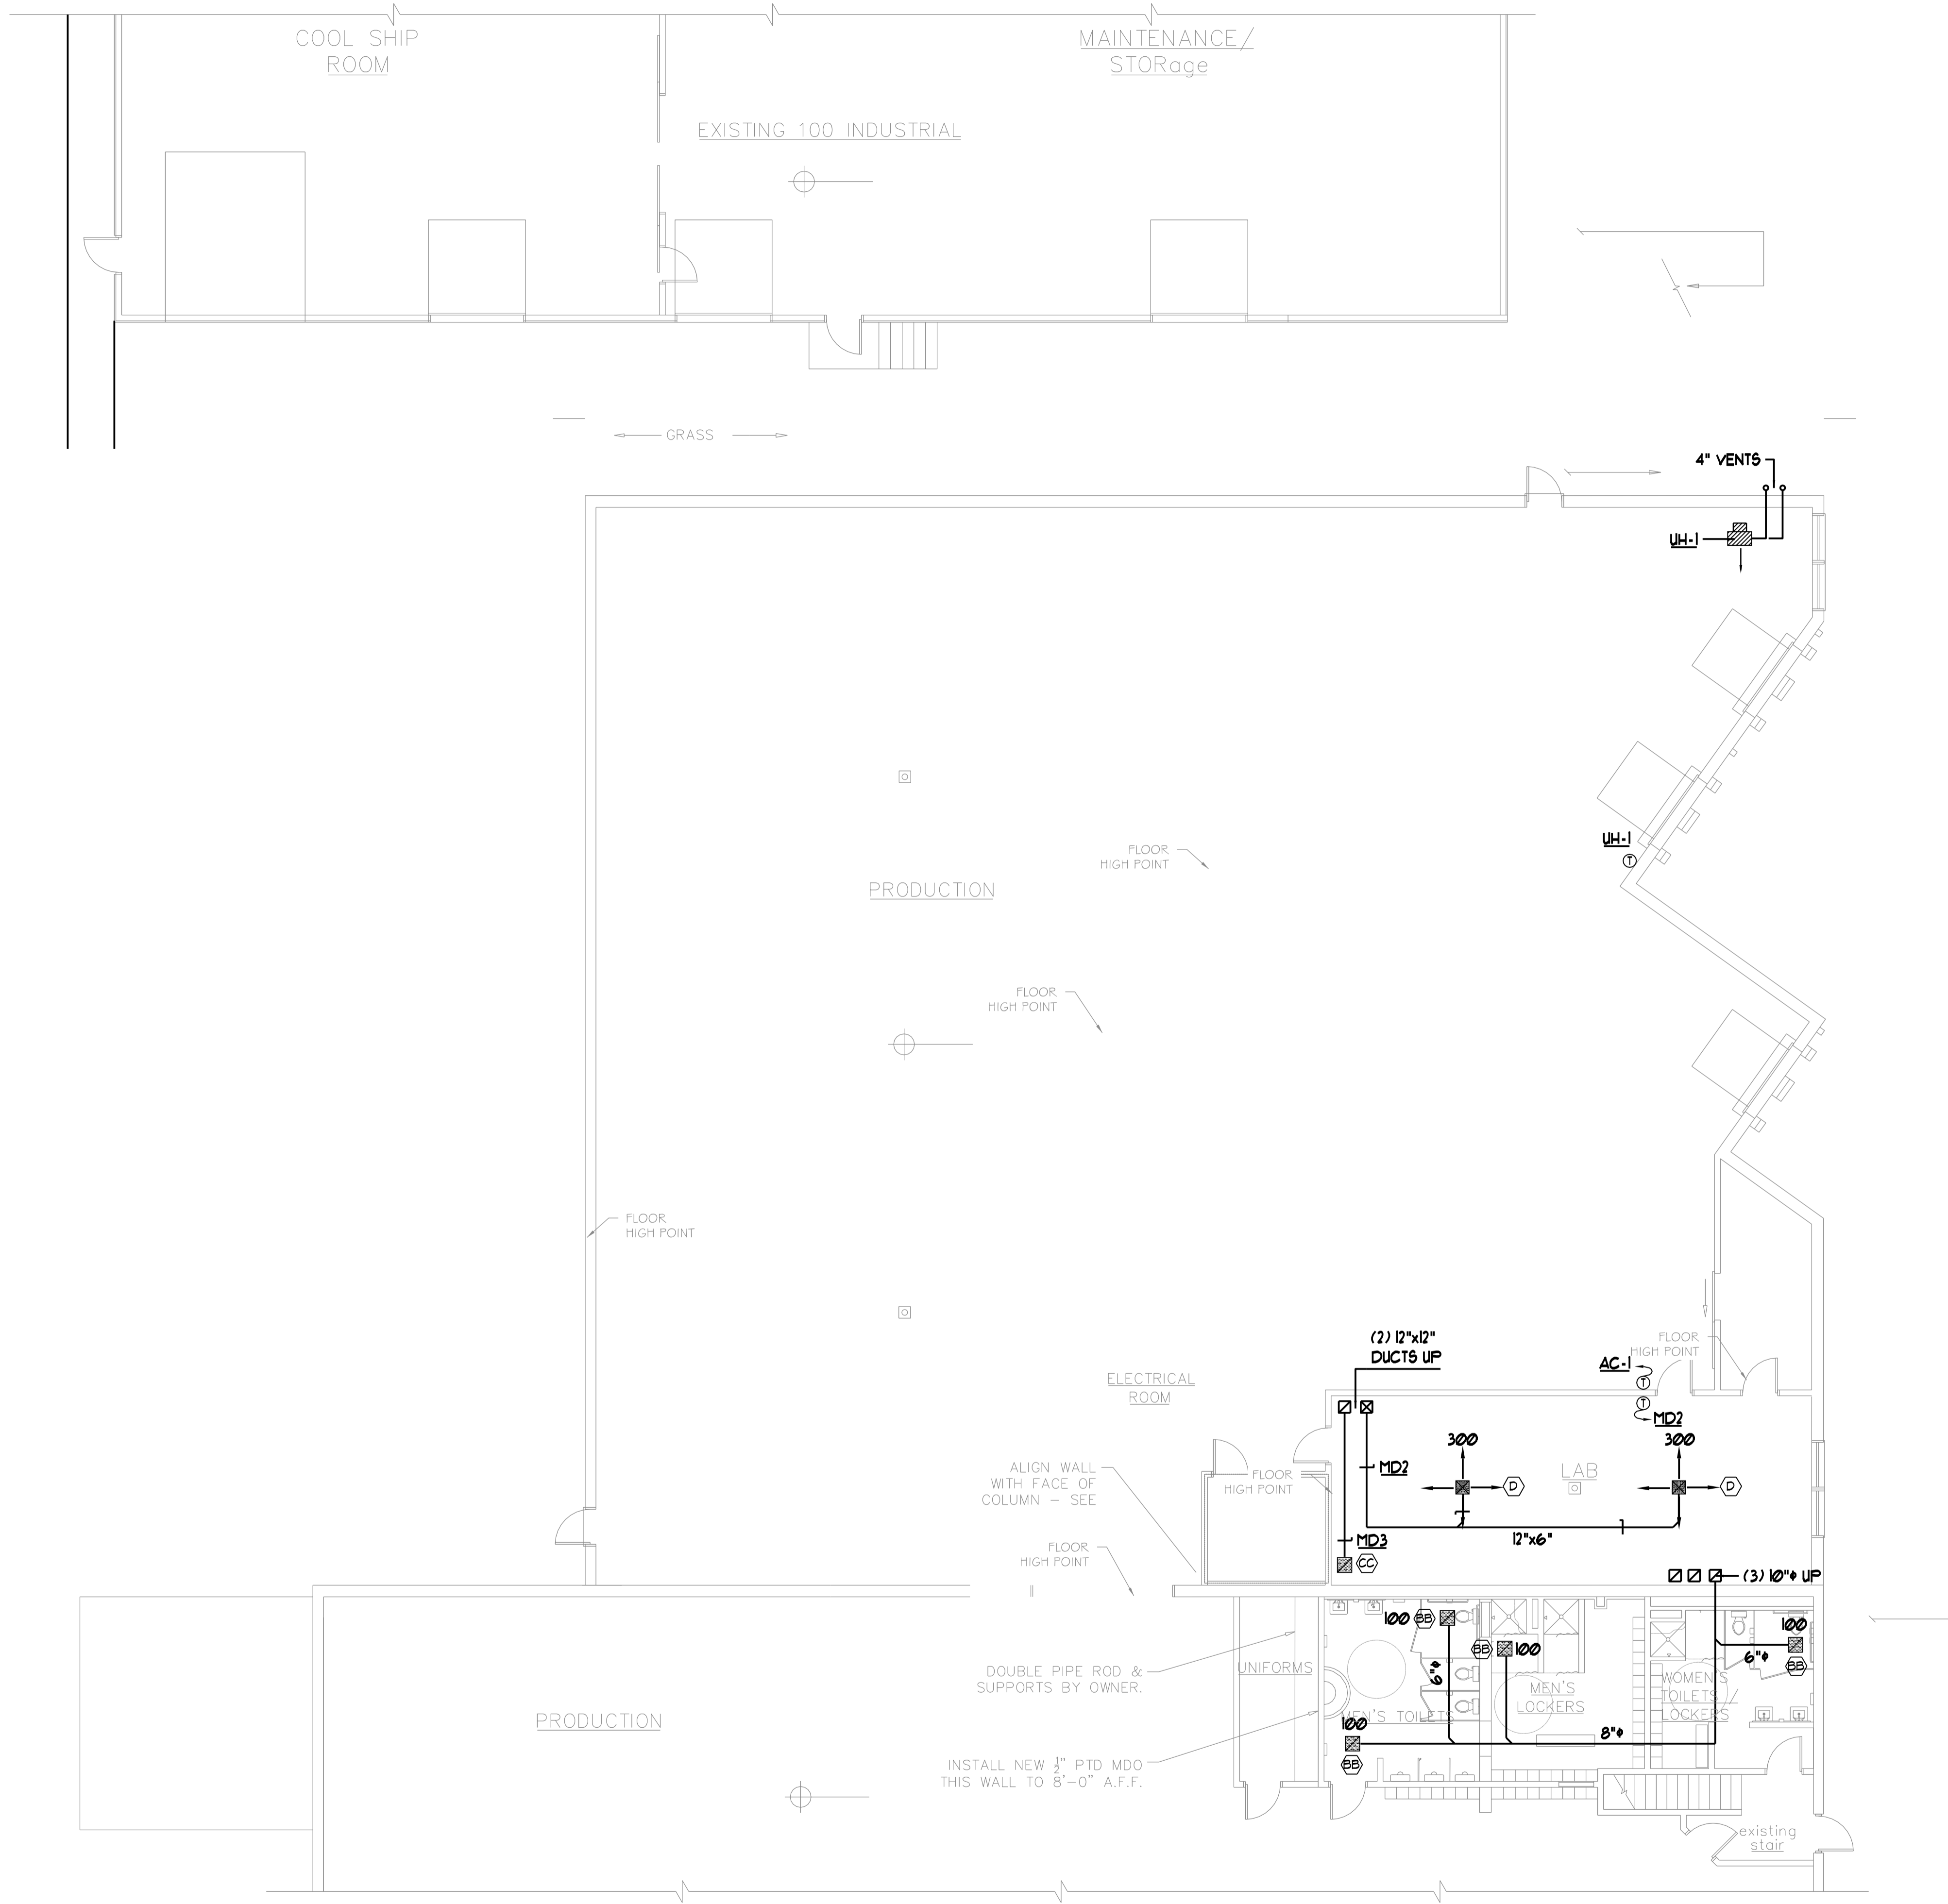

**FIRST FLOOR PLAN**  
SCALE 1/8" = 1'-0"

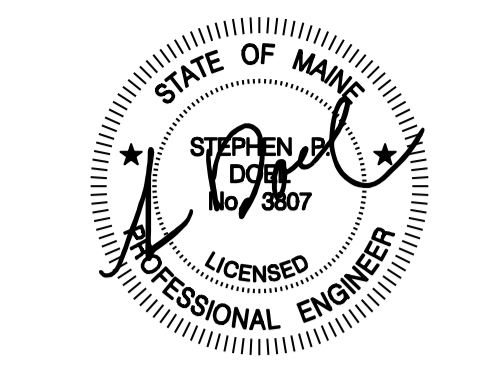

**ALLAGASH**  
BREWING COMPANY  
50 Industrial Way  
Portland, Maine

ALLAGASH BREWING CO.  
BOTTLING AREA ADDITION  
Portland, Maine  
FIRST FLOOR MECHANICAL PLAN

Date Drawn - 7/7/14

Drawn By - SPD

Revised -  
PERMIT 07/25/14

Project # 3588

Scale - AS NOTED

Sheet Number - M1