







Reviewed for Code Compliance
Inspection Division
Approved with Conditions

Date: 09/15/14

EXISTING 100 INDUSTRIAL ROOF

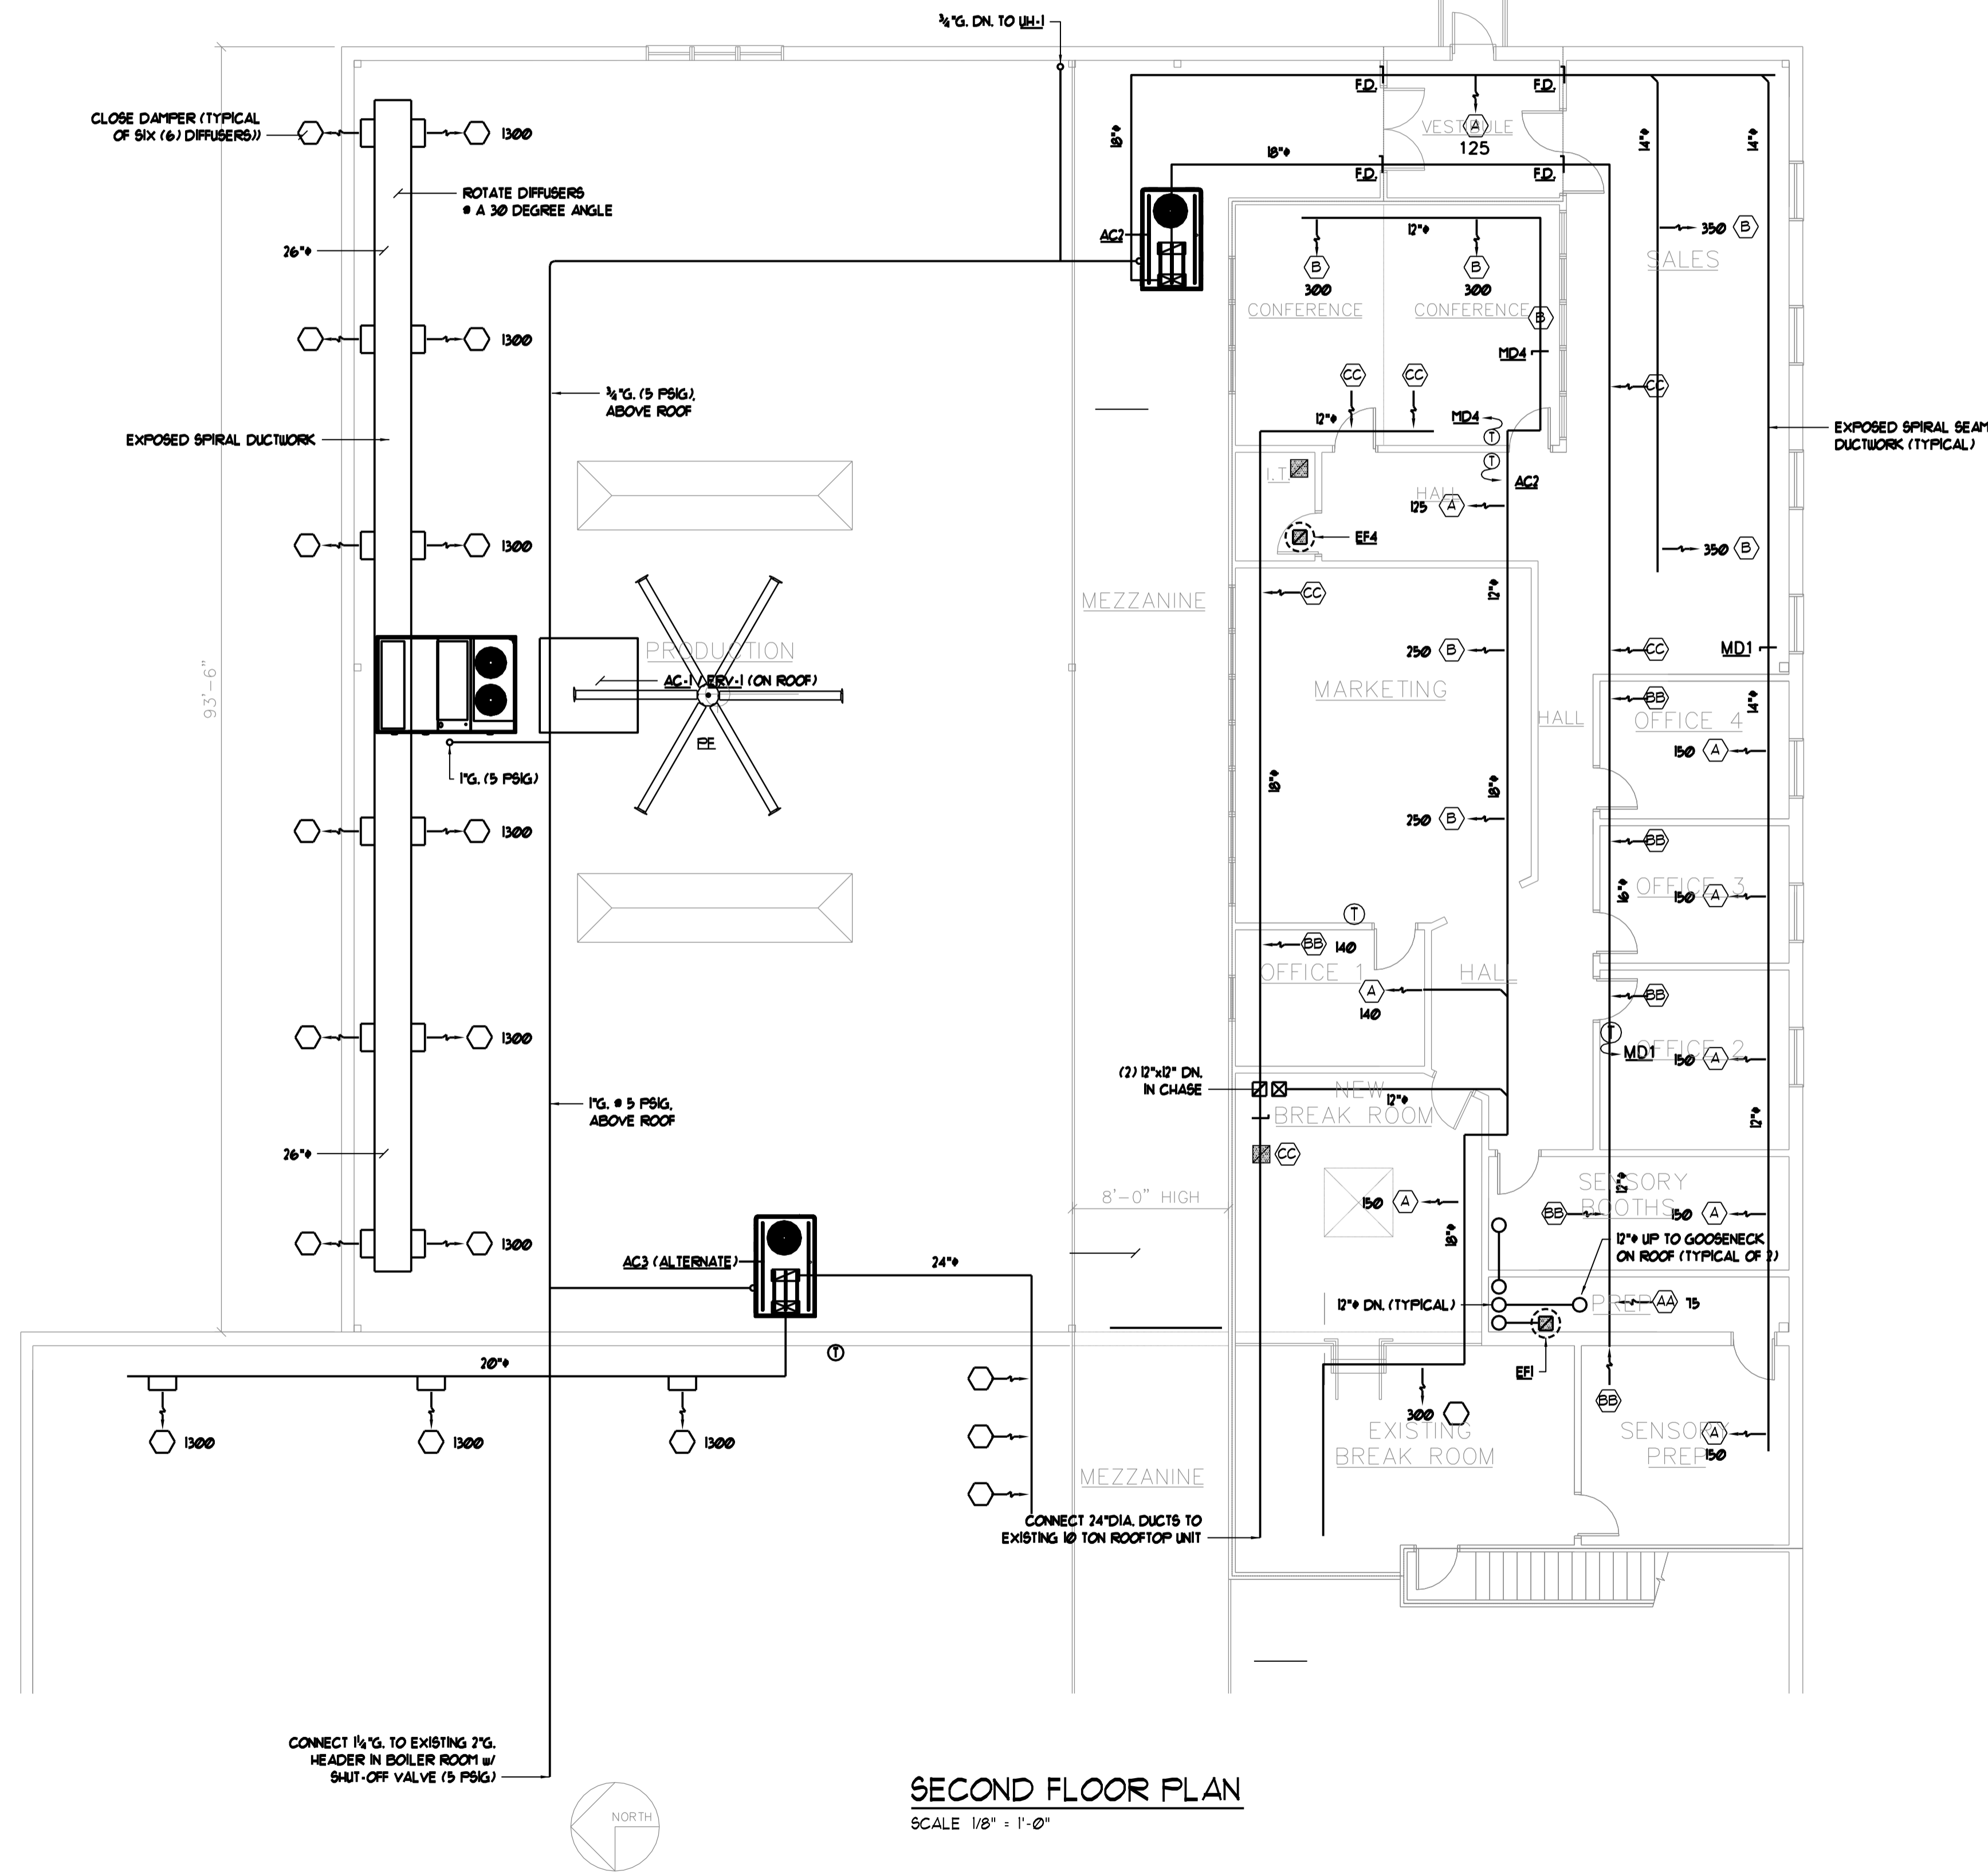

SECOND FLOOR PLAN
SCALE 1/8" = 1'-0"

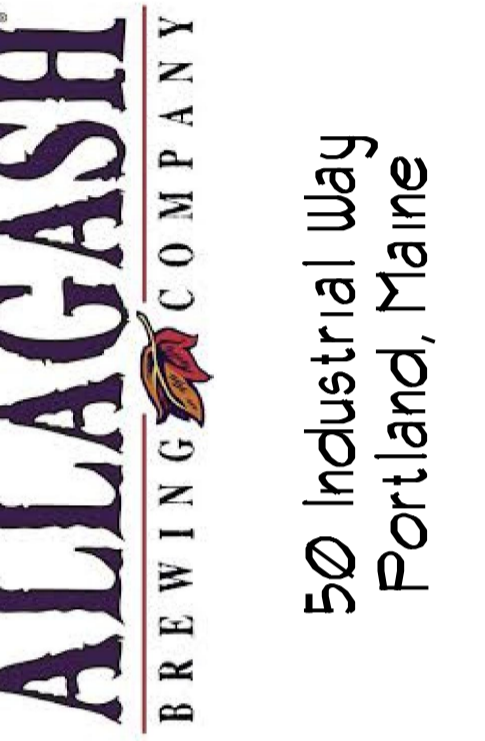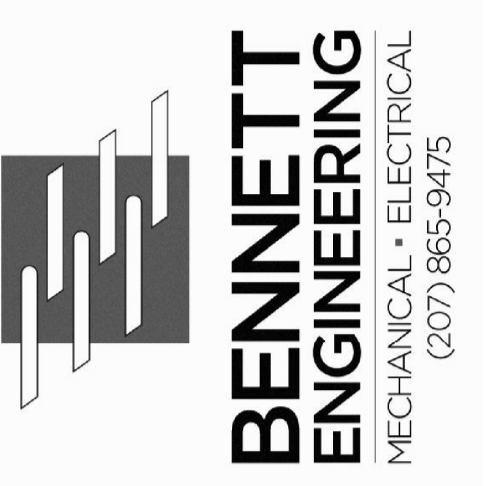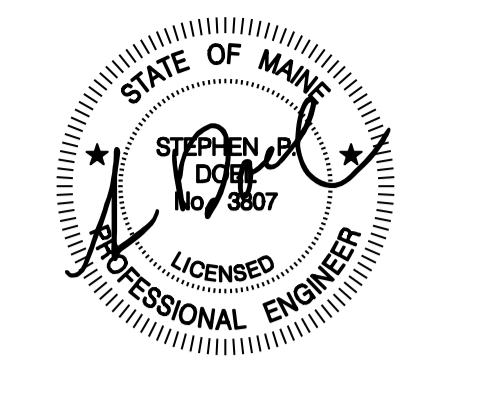

ALLAGASH BREWING CO.
BOTTLING AREA ADDITION
Portland, Maine
SECOND FLOOR MECHANICAL PLAN

Date Drawn - 7/7/14

Drawn By - ---

Revised -
PERMIT 07/25/14

Project # 3588

Scale - AS NOTED

Sheet Number - M2