





Reviewed for Code Compliance
Inspection Division
Approved with Conditions
Date: 09/15/14

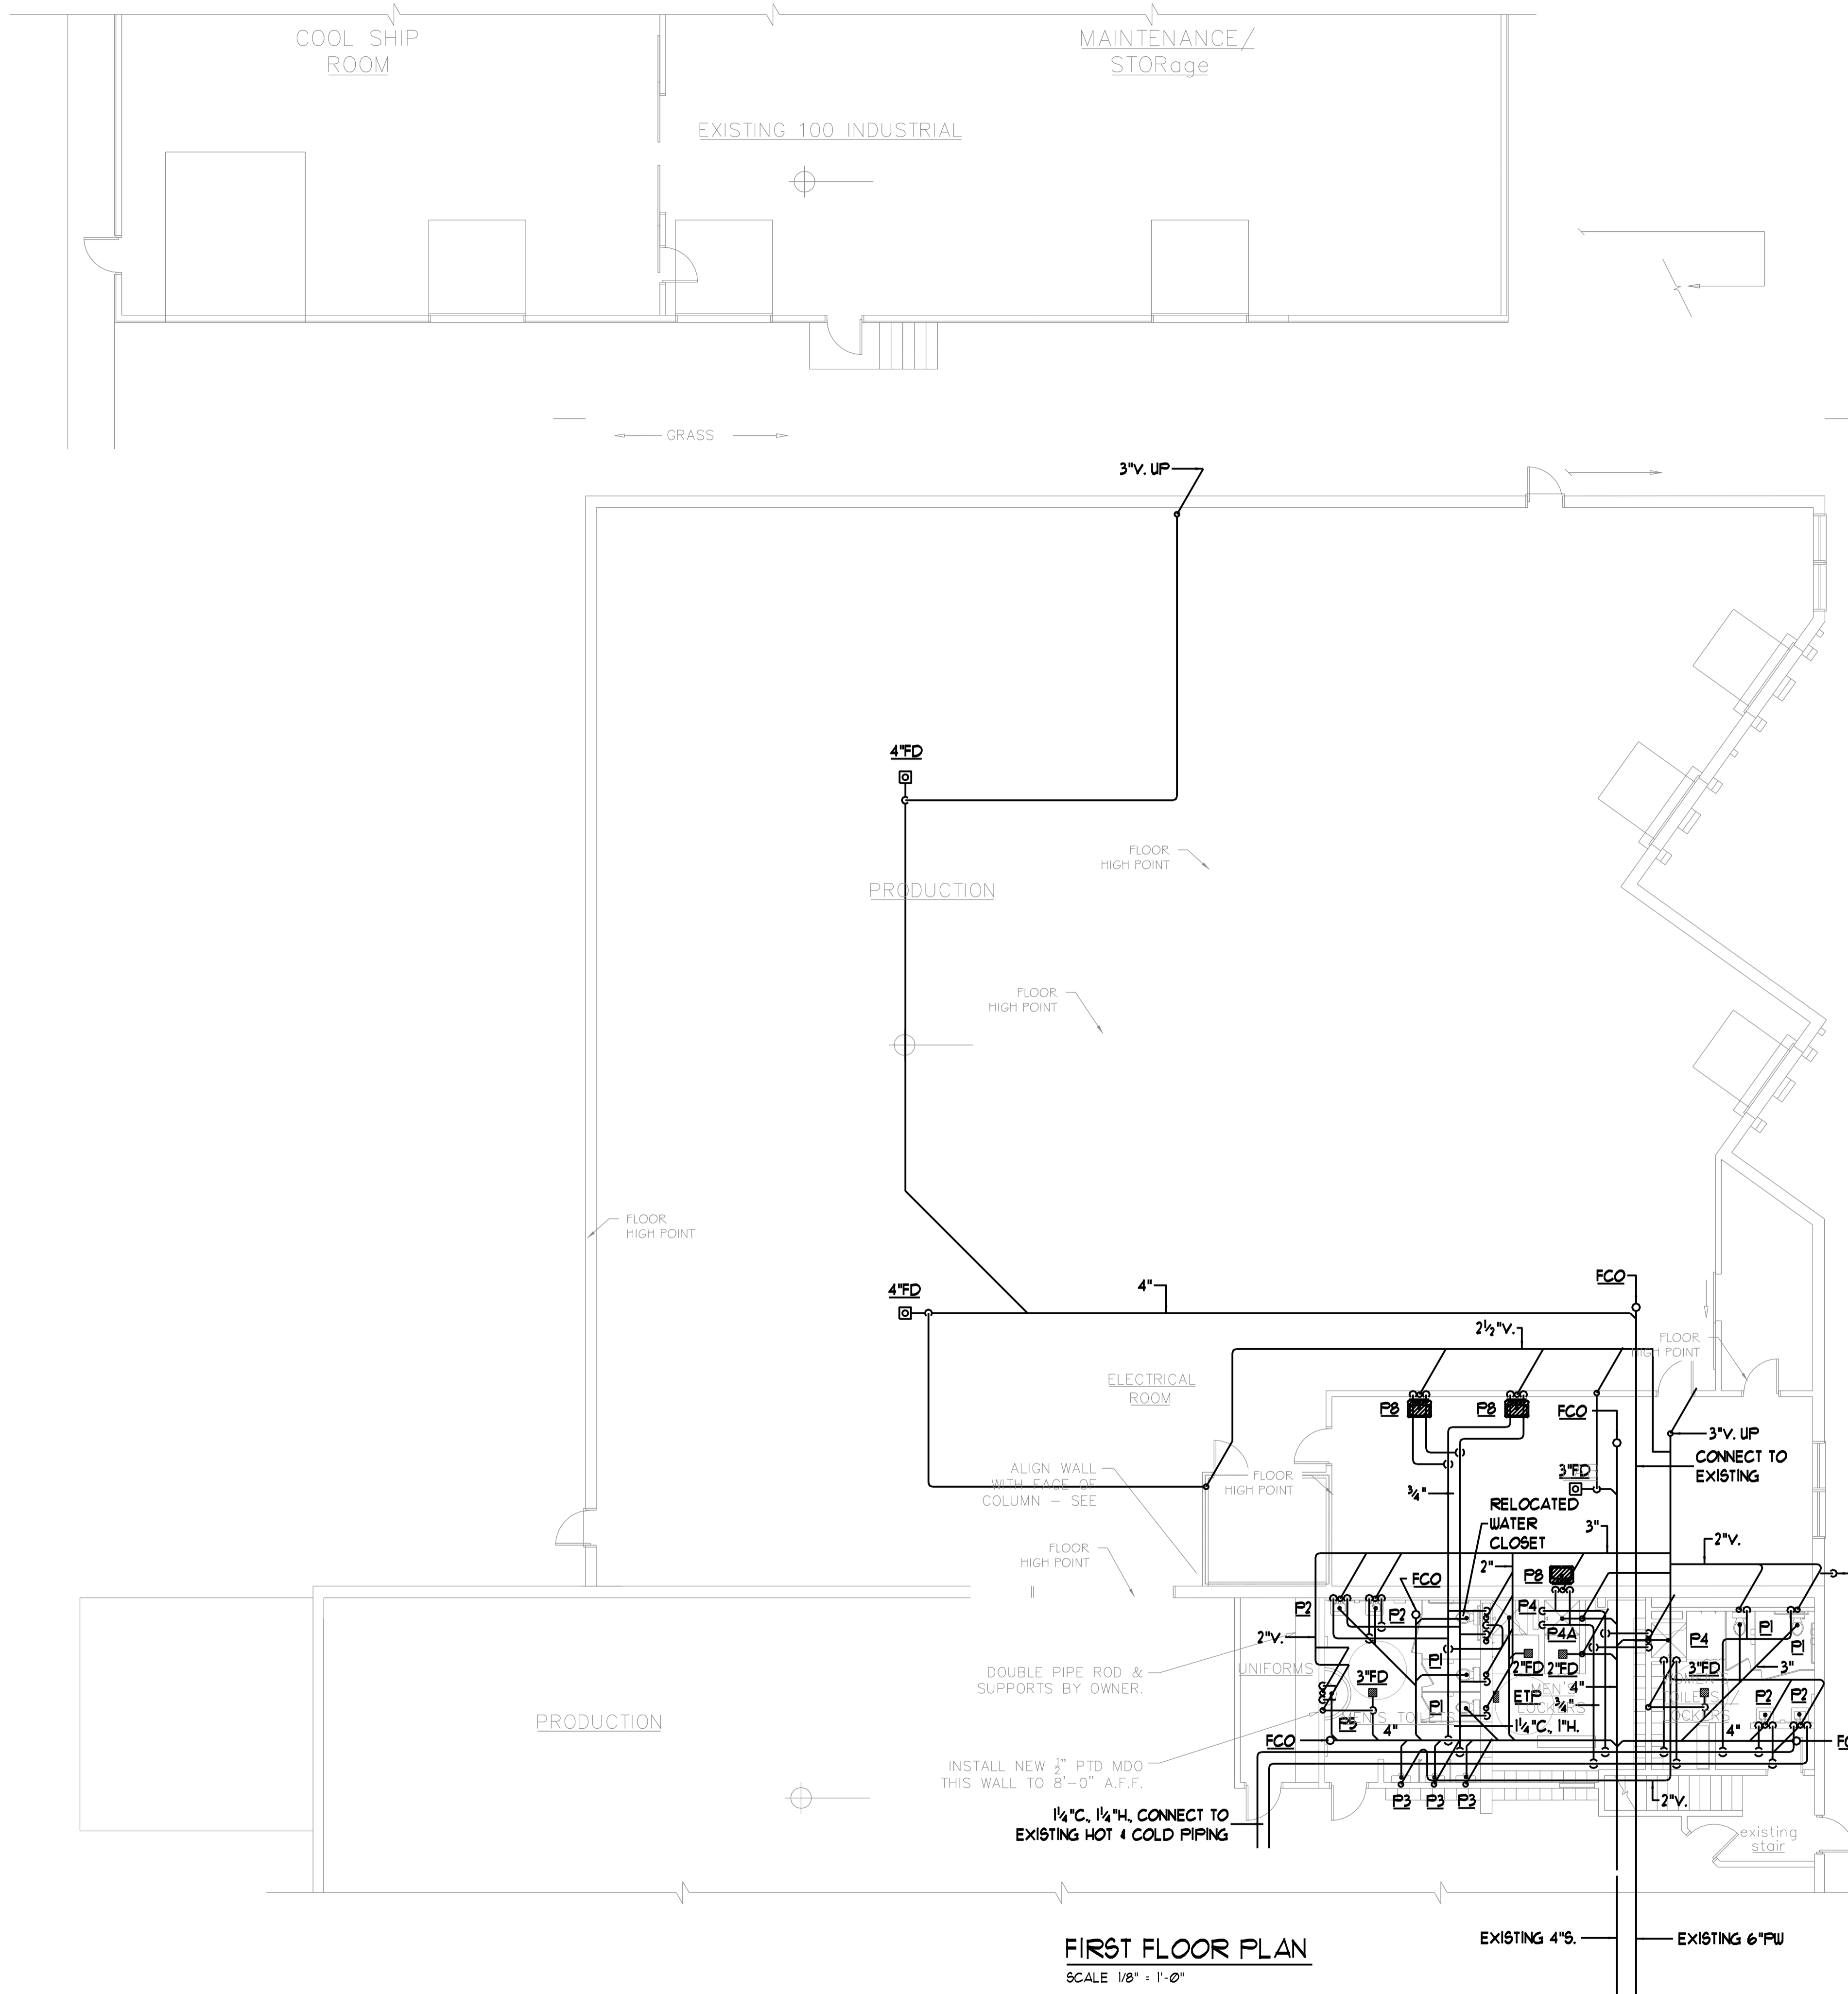

FIRST FLOOR PLAN
SCALE 1/8" = 1'-0"

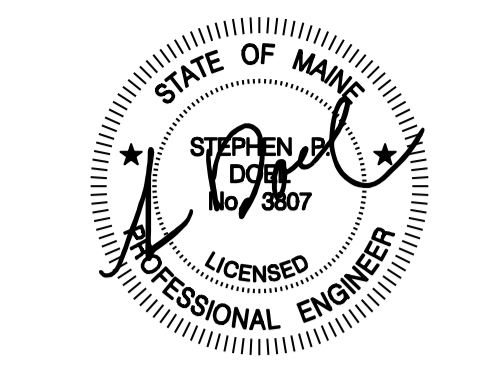

ALLAGASH
BREWING COMPANY
50 Industrial Way
Portland, Maine

ALLAGASH BREWING CO.
BOTTLING AREA ADDITION
Portland, Maine
FIRST FLOOR PLUMBING PLAN

Date Drawn - 7/7/14

Drawn By - SPD

Revised -
PERMIT 07/25/14

Project # 3588

Scale - AS NOTED

Sheet Number - P1