

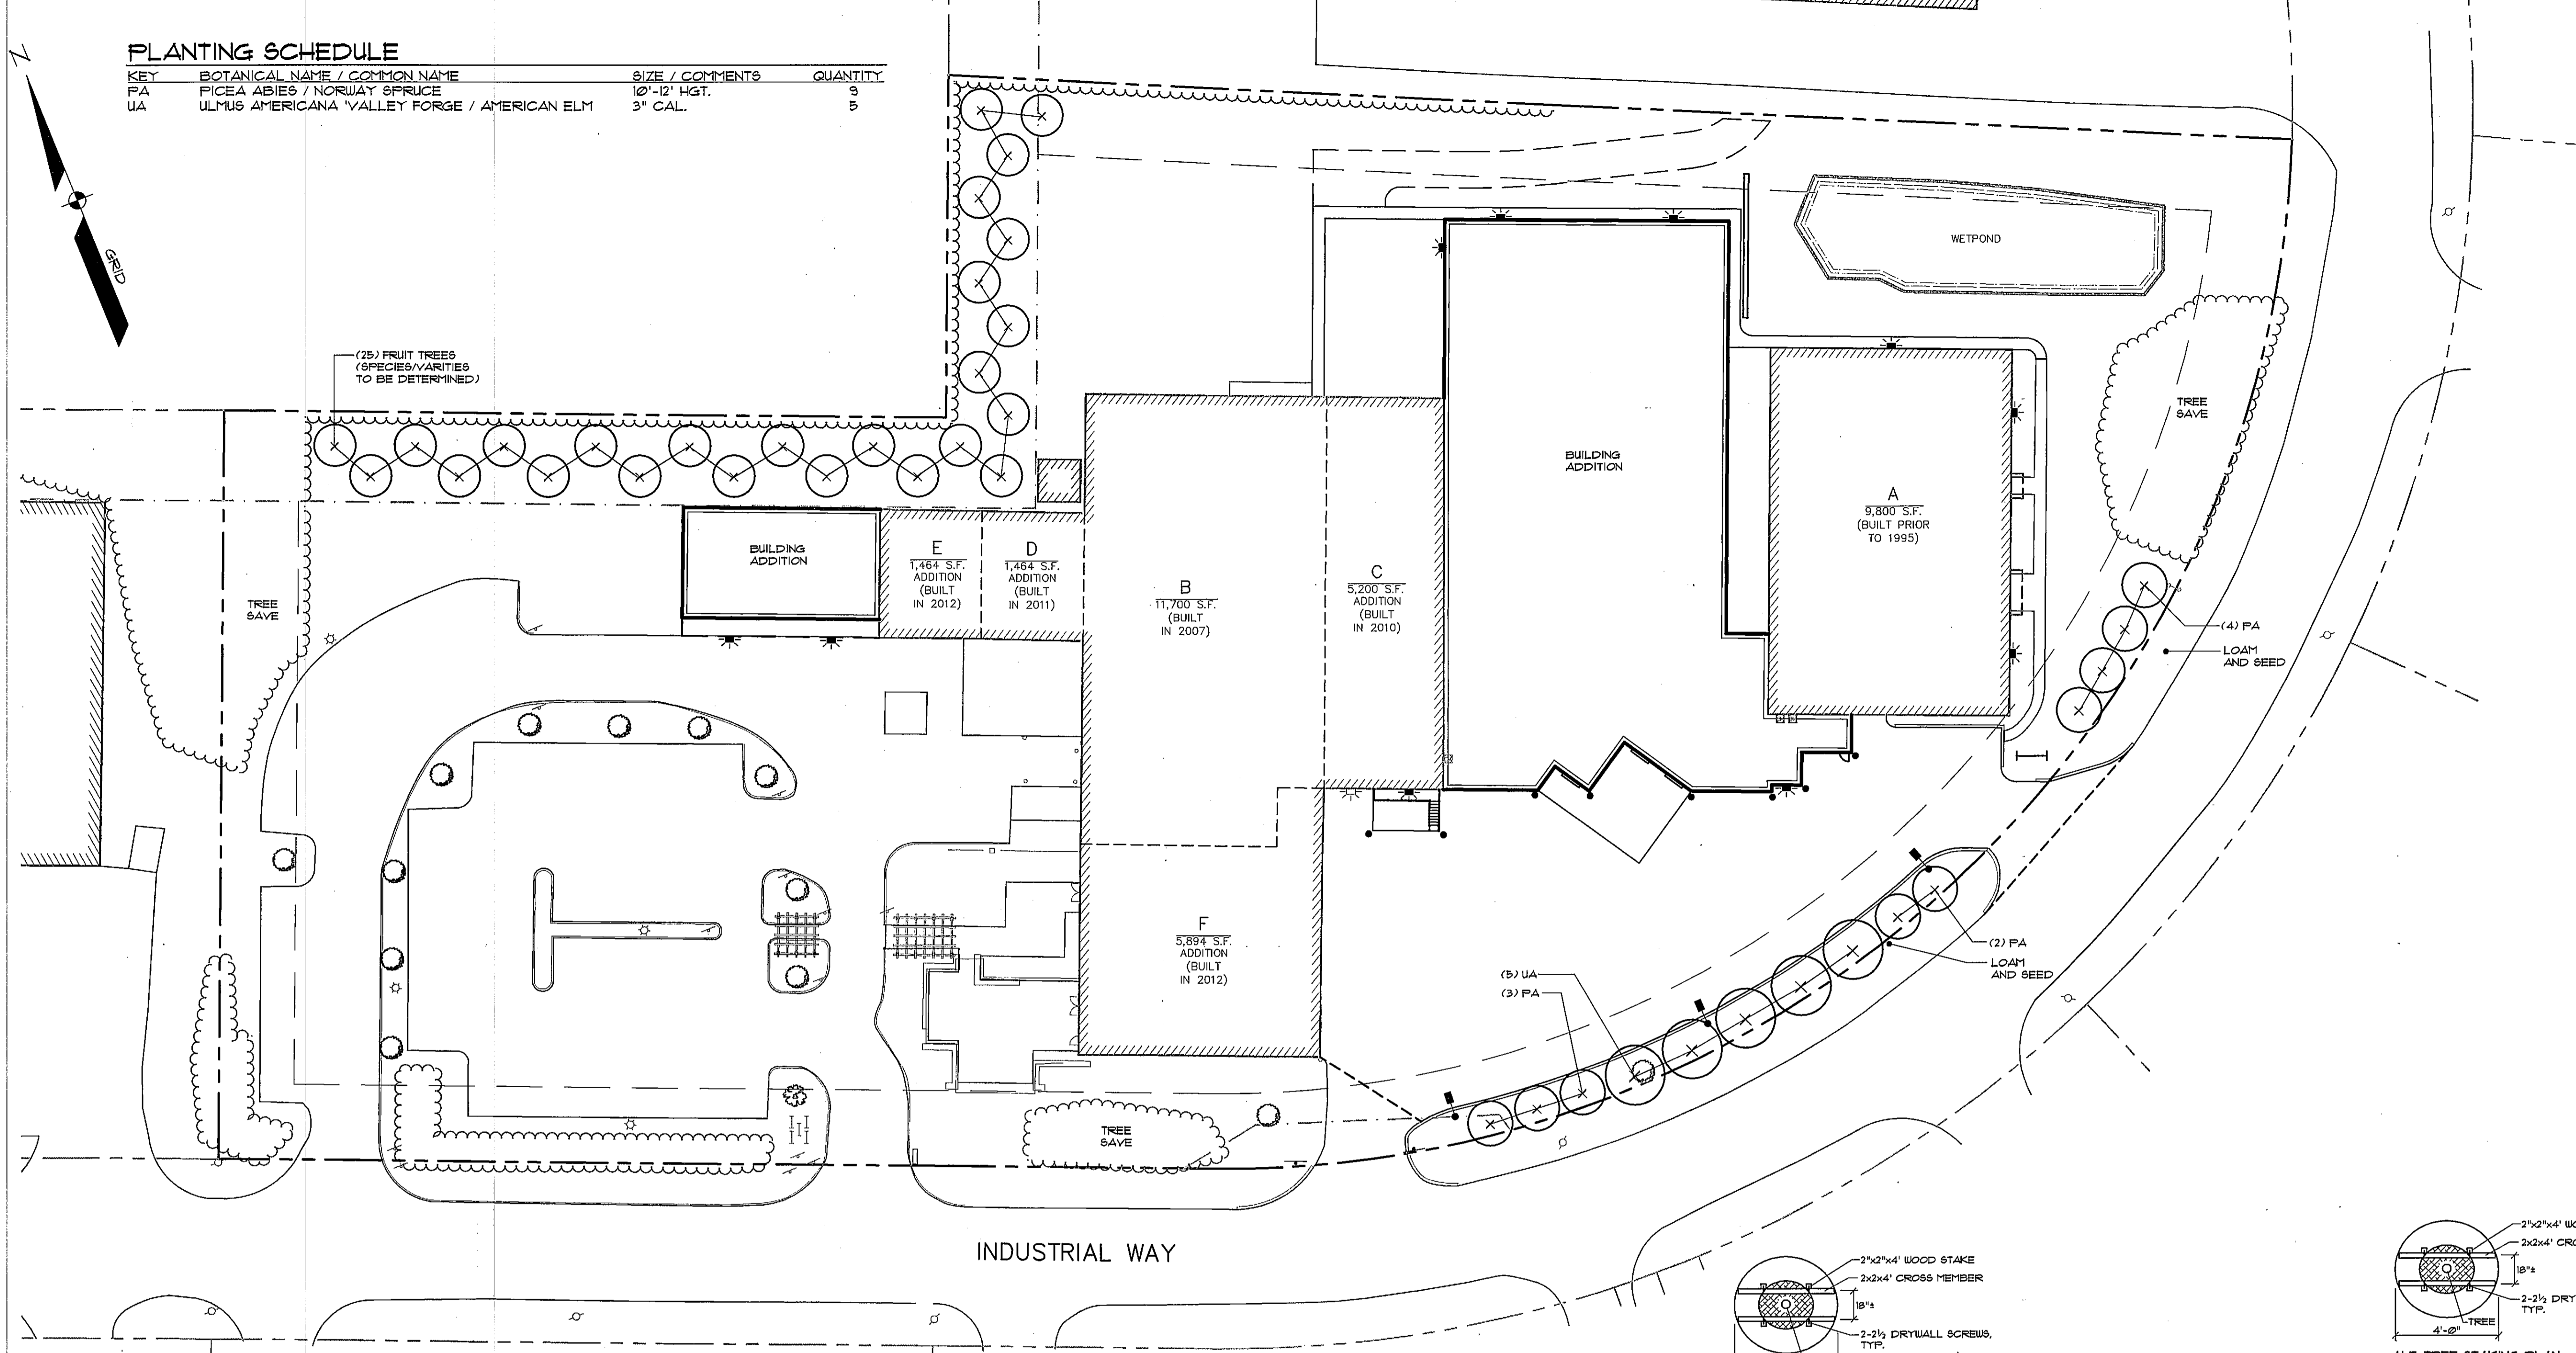


PLANTING SCHEDULE

KEY	BOTANICAL NAME / COMMON NAME	SIZE / COMMENTS	QUANTITY
FA	FICEA ABIES / NORWAY SPRUCE	10'-12' HGT.	9
UA	ULMUS AMERICANA / VALLEY FORGE / AMERICAN ELM	3" CAL.	5

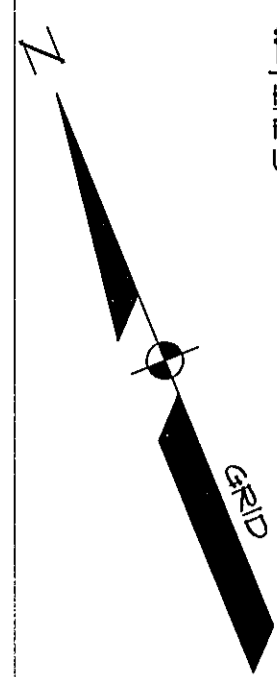

INDUSTRIAL WAY

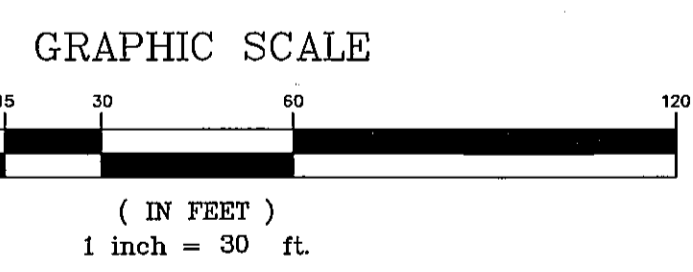

NOTES:


- ALL TREE SAVE AREAS MUST BE IDENTIFIED IN THE FIELD PRIOR TO SITE WORK.
- PROTECTIVE MEASURES WILL BE REQUIRED IN TREE SAVE AREAS IN ORDER TO PREVENT THE STORAGE OF MATERIALS AND EQUIPMENT.
- IN THE CASE THAT TREE SAVE AREAS ARE AFFECTED DURING CONSTRUCTION, ADDITIONAL TREES/SHRUBS MAY BE NEEDED.

LIGHTING LEGEND


- KIM LIGHTING:**
- 9-3 - EKG401-3/20HP9-E18 (20' MOUNTING HEIGHT)
 - 9-36 - EKG401-3/20HP9-E18/H9 (20' MOUNTING HEIGHT)
 - 9-45 - EKG401-4/25HP9-E18/H9 (20' MOUNTING HEIGHT)
- RAAB

LEGEND


EXISTING	DESCRIPTION	PROPOSED
---	BOUNDARY LINE/ROW	---
---	ABUTTER LINE/ROW	---
---	SETBACK	---
---	EASEMENT	---
---	BUILDING	---
---	SIGN	---
---	EDGE PAVEMENT	---
---	EDGE CONCRETE	---
---	CURBLINE	---
---	TREELINE	---
○	DECIDUOUS TREE	○
⊗	CONIFEROUS TREE	⊗
○	MULCH LINE	○
---	SCREENING FENCE	---
---	BOLLARD	---
○	LIGHT POLE/WALL	○
○	UTILITY POLE	○

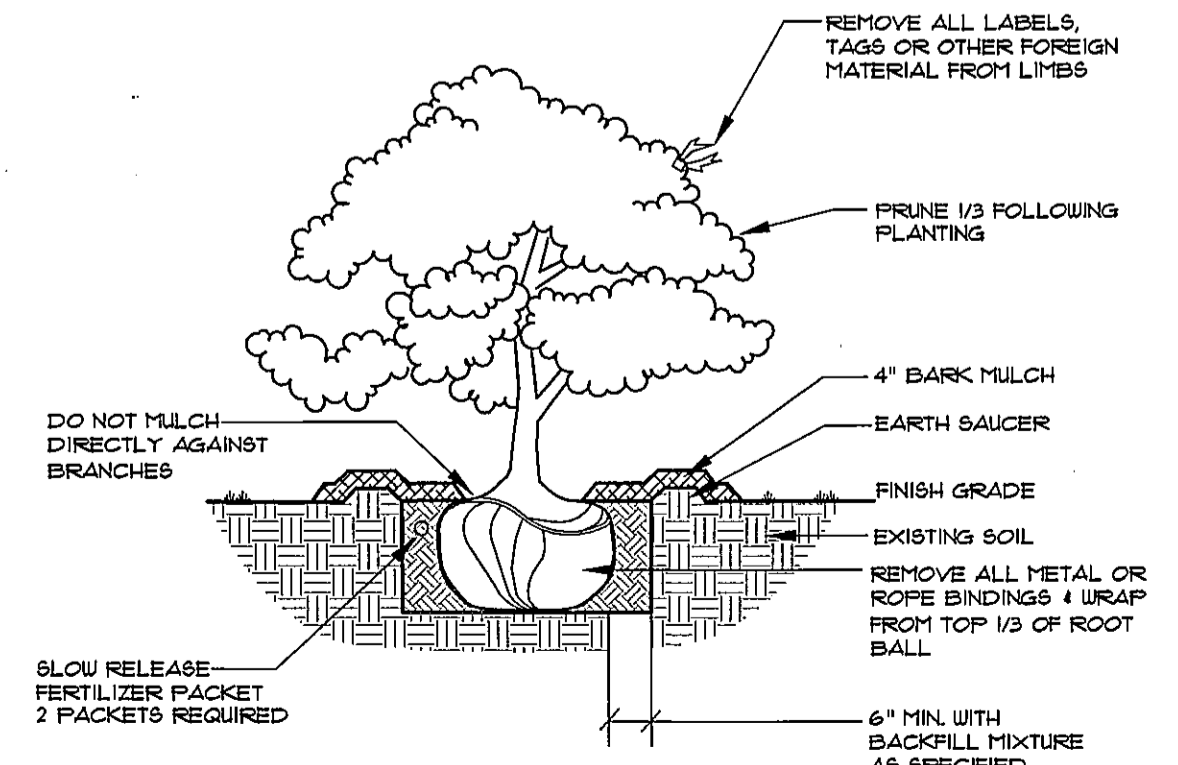

DECIDUOUS & EVERGREEN SHRUB
NOT TO SCALE

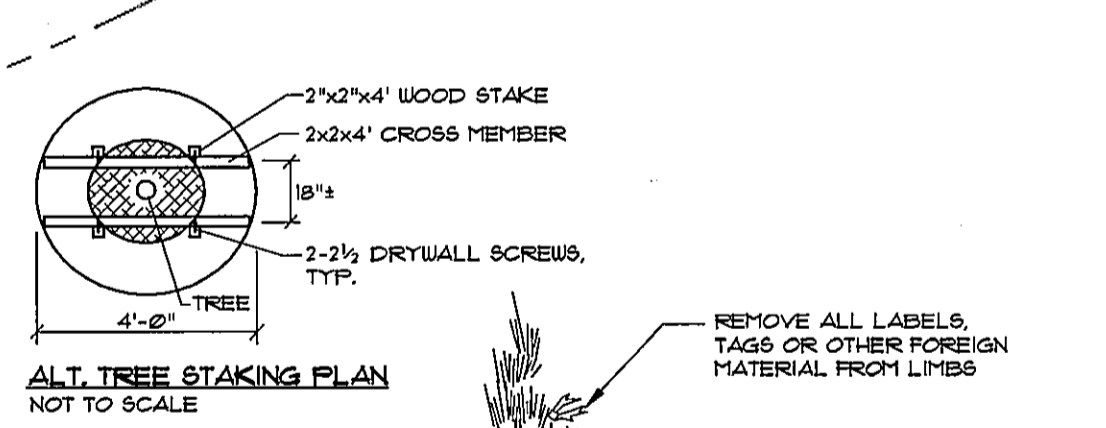


ALT. TREE STAKING PLAN
NOT TO SCALE

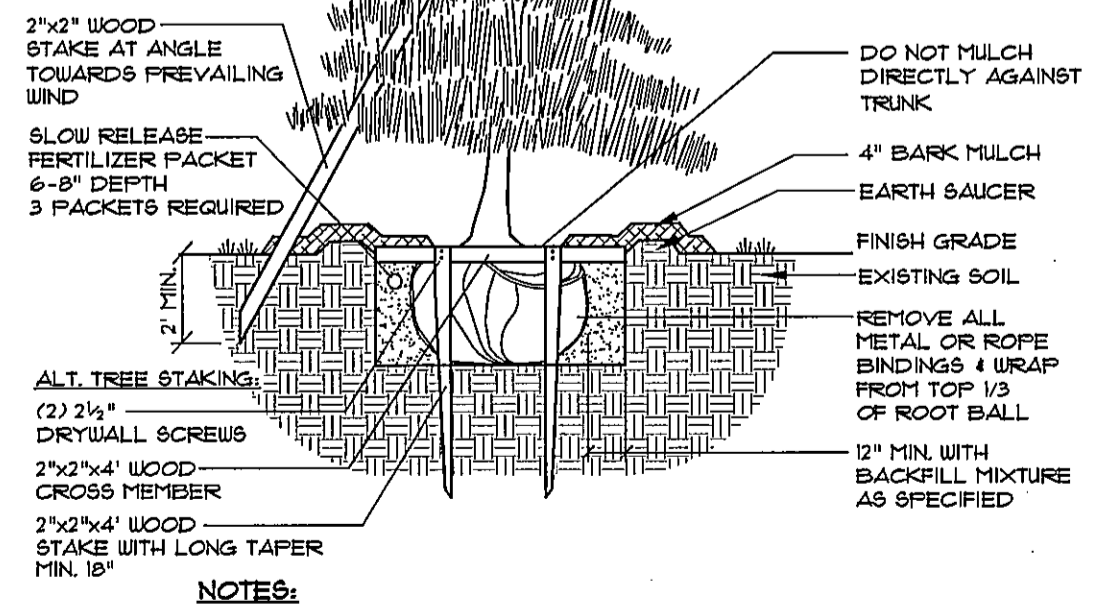


- NOTES:**
- INSTALL STAKES AND GUYS TO TREES IF THE FOLLOWING APPLY:
 - THE TREE IS OF SUBSTANTIAL SIZE.
 - THE PLANTING LOCATION IS EXTREMELY WINDY, AS ON OPEN UNDEVELOPED SITES.
 - THE PLANTING LOCATION IS COMPRISED OF SAND OR OTHER LOOSE TEXTURED SOILS.
 - IF STAKES AND GUYS ARE REQUIRED, REMOVE AFTER ONE YEAR TIME.

DECIDUOUS TREES UNDER 2\"/>

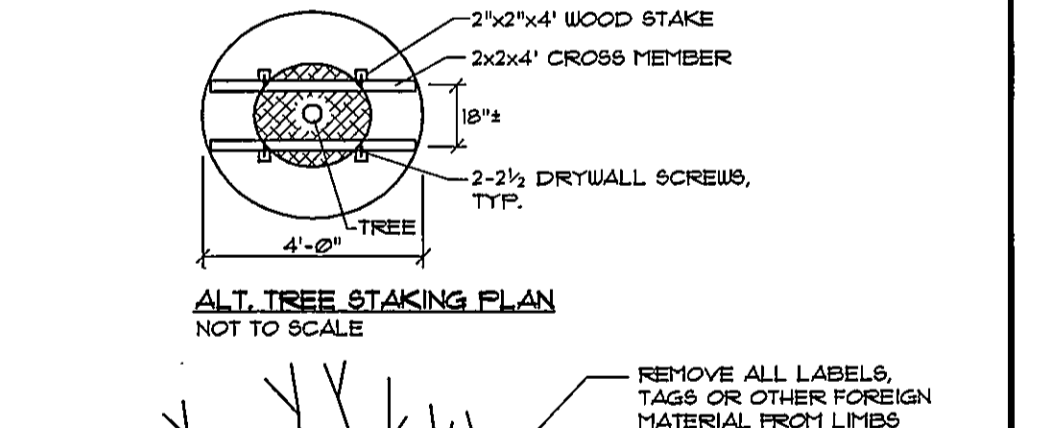

ALT. TREE STAKING PLAN
NOT TO SCALE

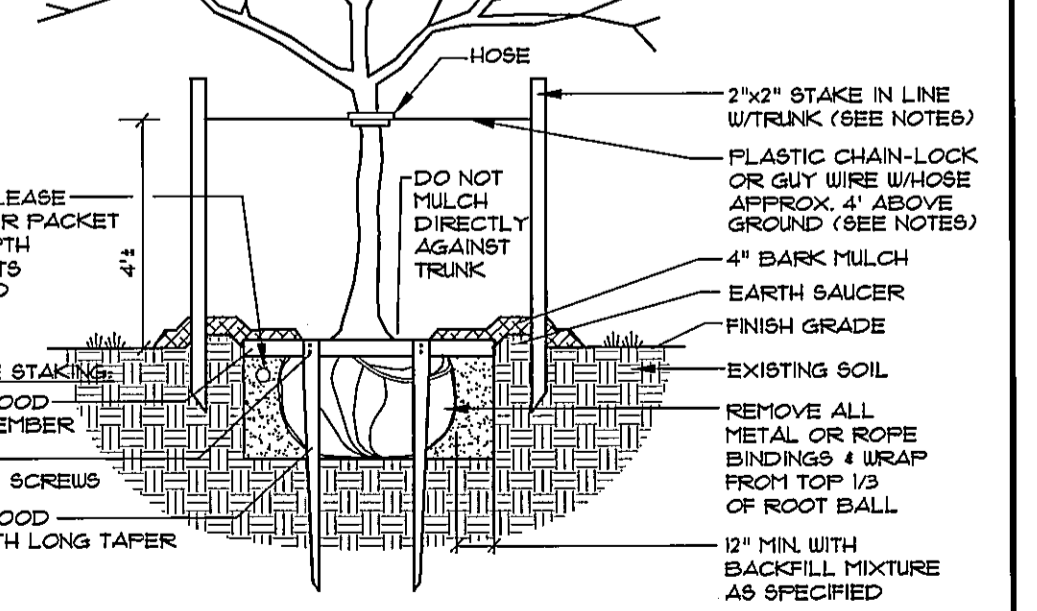

- NOTES:**
- INSTALL STAKES AND GUYS TO TREES IF THE FOLLOWING APPLY:
 - THE TREE IS OF SUBSTANTIAL SIZE.
 - THE PLANTING LOCATION IS EXTREMELY WINDY, AS ON OPEN UNDEVELOPED SITES.
 - THE PLANTING LOCATION IS COMPRISED OF SAND OR OTHER LOOSE TEXTURED SOILS.
 - IF STAKES AND GUYS ARE REQUIRED, REMOVE AFTER ONE YEAR TIME.

DECIDUOUS TREES 2\"/>

SEBAGO TECHNICS
WWW.SEBAGOTECHNICS.COM
75 Main Road, South Portland, ME 04106
Tel: 207-800-2100

PROJECT NO. 02249
FIELD BOOK 847
DESIGN CHKO
DRAWN MAL

LANDSCAPE AND LIGHTING PLAN
OF:
ALLAGASH BREWING COMPANY
INDUSTRIAL WAY
PORTLAND, MAINE
FOR:
50 INDUSTRIAL WAY
PORTLAND, MAINE 04103

DATE	SCALE
05-20-14	1" = 30'

SHEET 7 OF 9

02249L1.dwg TAB: L