
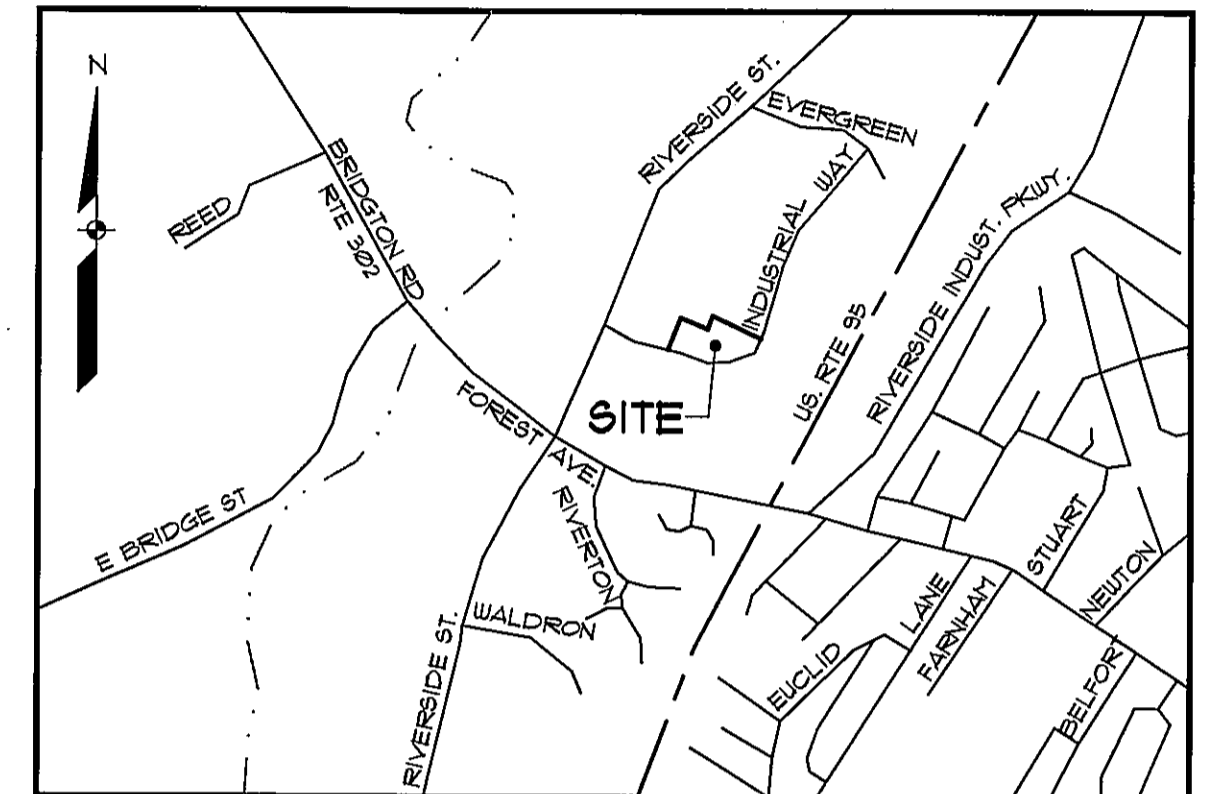
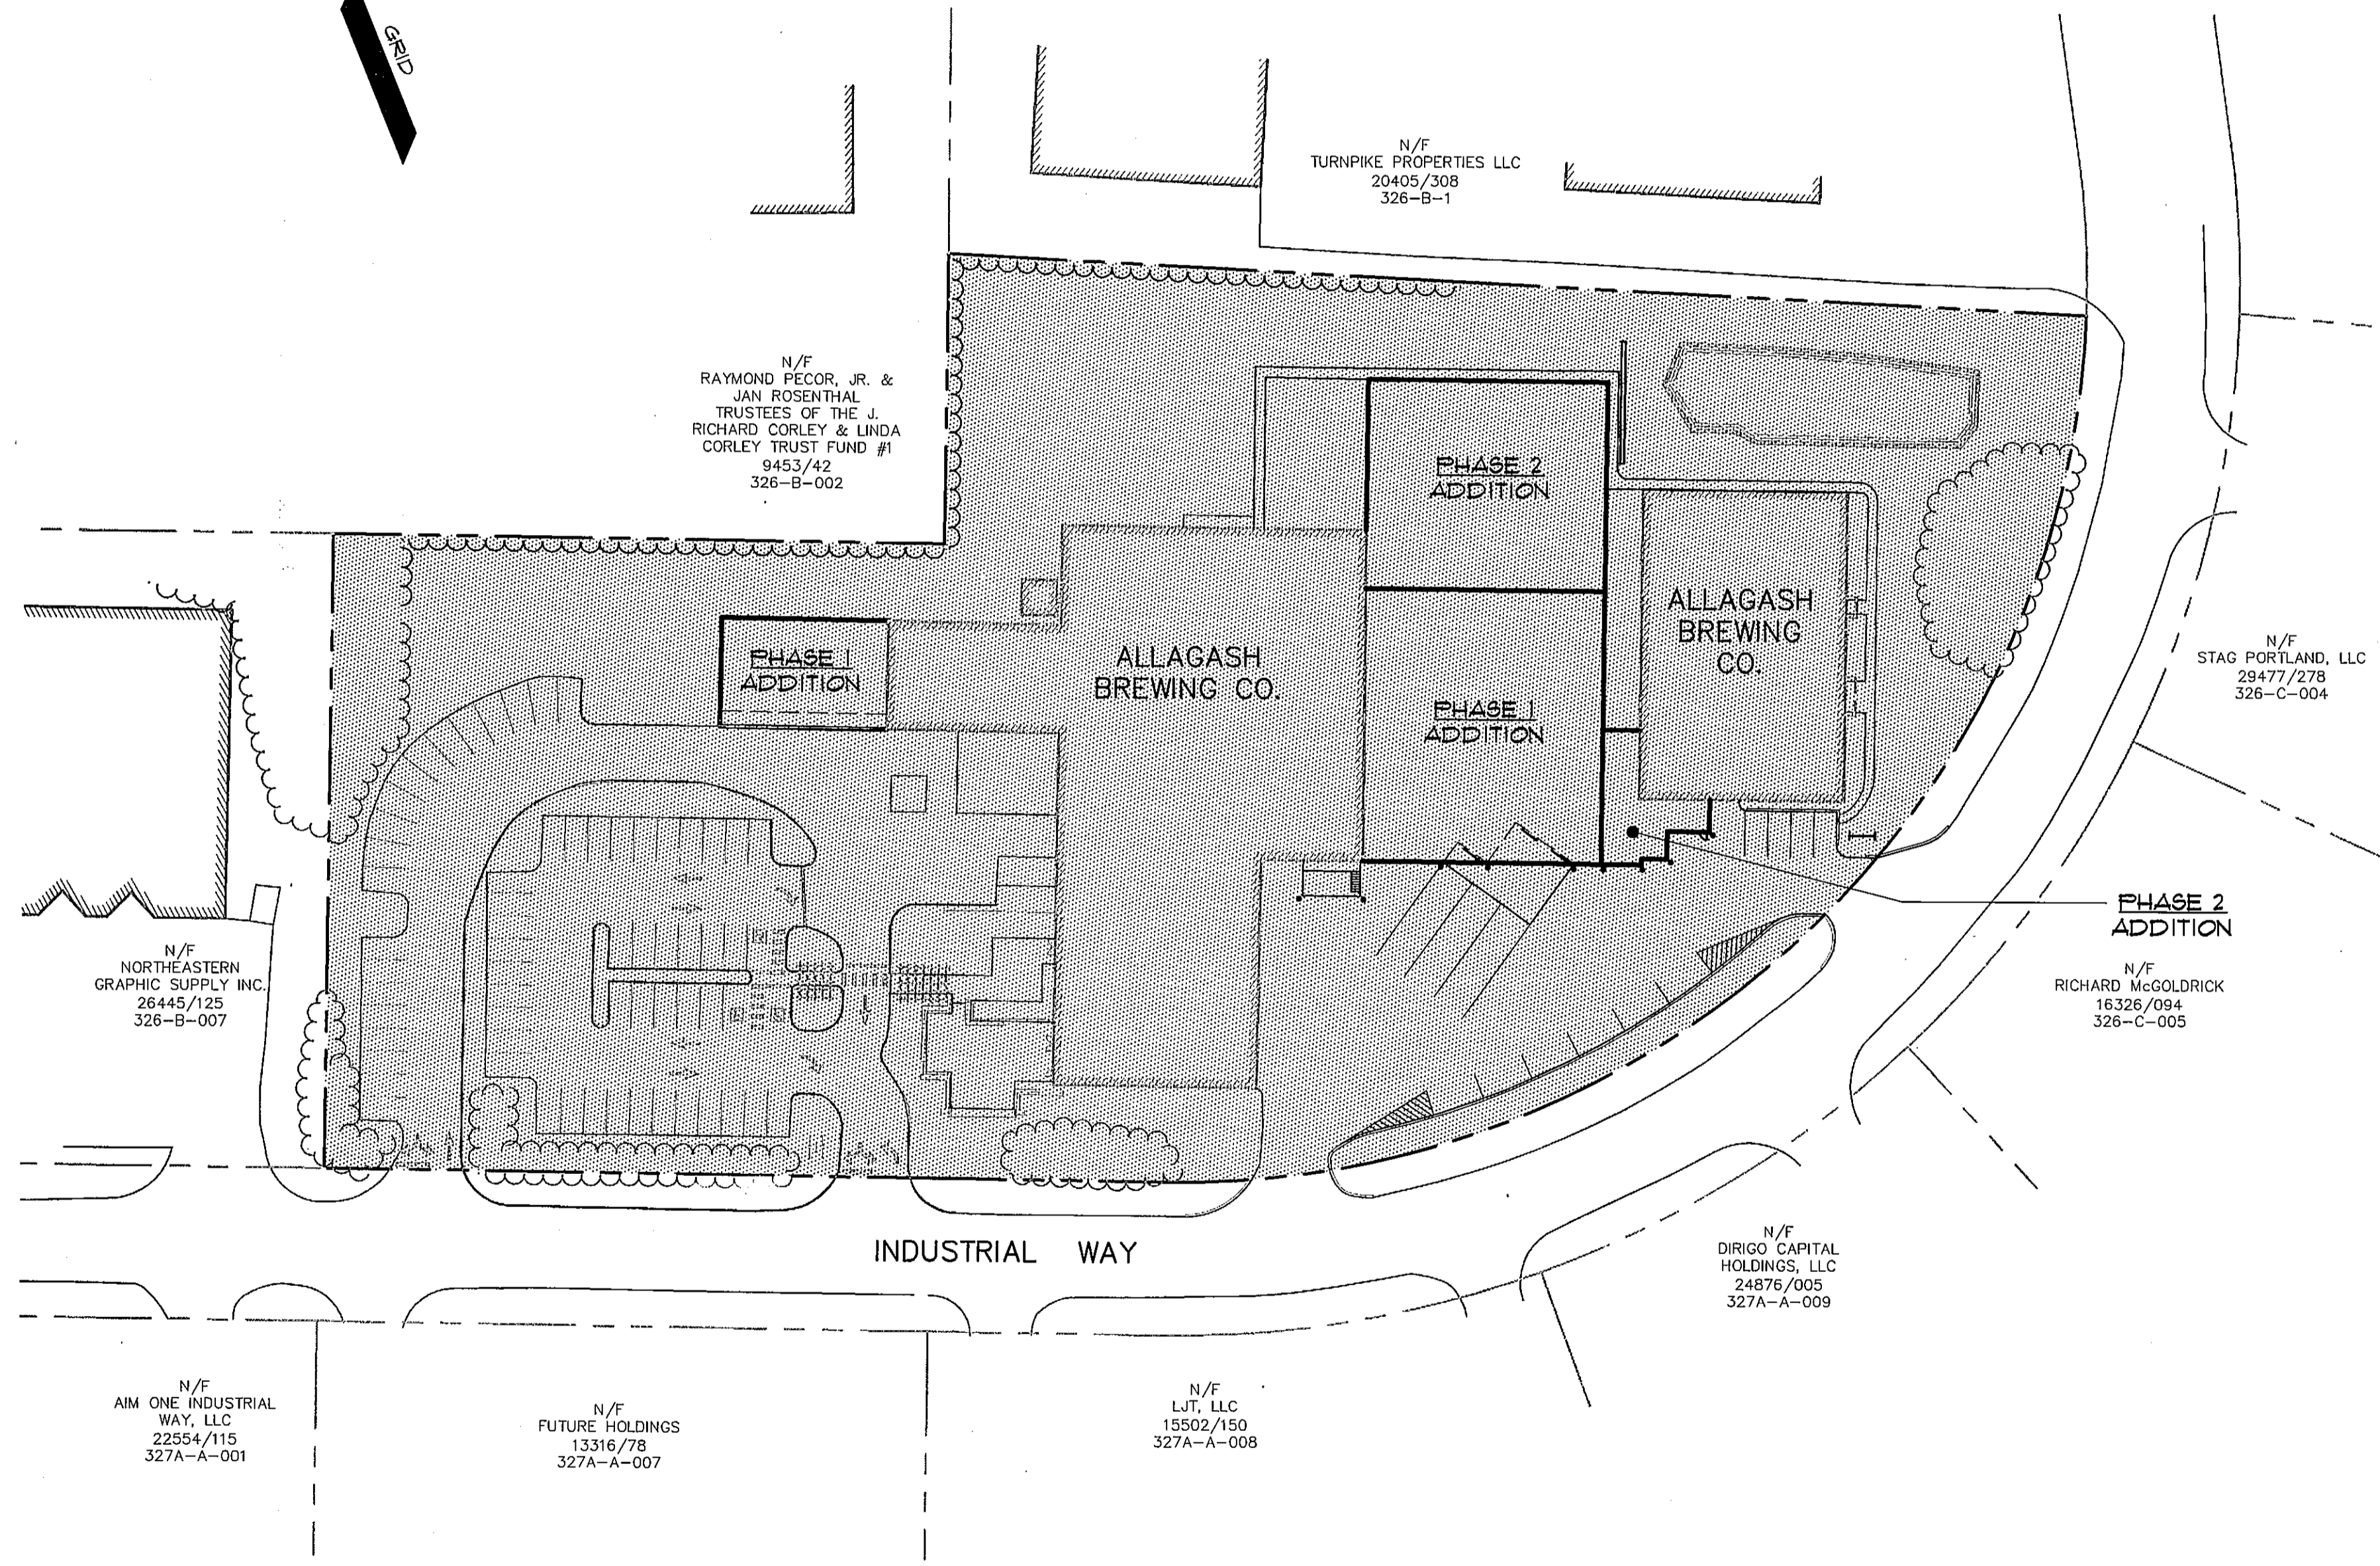


ALLAGASH BREWING COMPANY

PORTLAND, MAINE

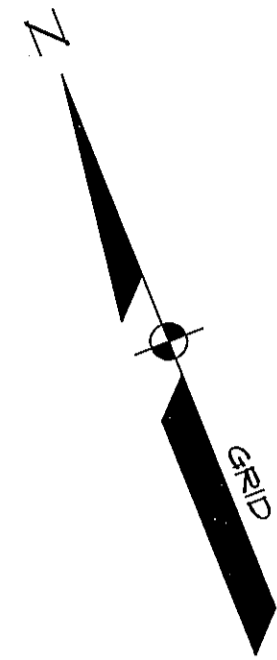

LOCATION MAP

N.T.S.

APPLICANT:
50 INDUSTRIAL WAY, LLC
 50 INDUSTRIAL WAY
 PORTLAND, MAINE 04103

ENGINEER / SURVEYOR:

SEBAGO
 TECHNICS

WWW.SEBAGOTECHNICS.COM


75 John Roberts Rd. - Suite 1A 250 Goddard Rd. - Suite B
 South Portland, ME 04106 Lewiston, ME 04240
 Tel. 207-200-2100 Tel. 207-783-6666

ARCHITECT:
GRANT HAYS ASSOCIATES
 P.O. BOX 6119
 FALMOUTH, MAINE 04105

SCALE: 1" = 50'

SHEET INDEX

SHEET	DESCRIPTION
C1	COVER SHEET
C2	EXISTING CONDITIONS PLAN
C3.1	DEMOLITION PLAN-PHASE 1
C3.2	DEMOLITION PLAN-PHASE 2
C4	PHASING PLAN
C5.1	SITE PLAN-PHASE 1
C5.2	SITE PLAN-PHASE 2
C6.1	GRADING AND UTILITY PLAN-PHASE 1
C6.2	GRADING AND UTILITY PLAN-PHASE 2
C7.1	LANDSCAPE AND LIGHTING PLAN-PHASE 1
C7.2	LANDSCAPE AND LIGHTING PLAN-PHASE 2
C8	DETAILS
C9	DETAILS

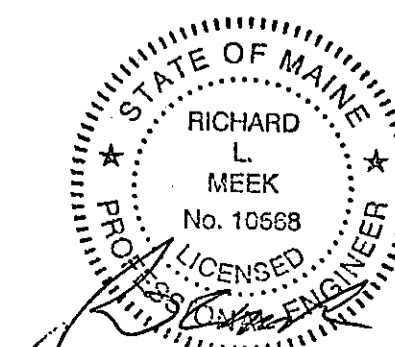

B	RLM	07-11-14	FINAL SITE PLAN SUBMISSION TO CITY
A	RLM	06-03-14	SITE PLAN SUBMISSION TO CITY
REV:	BY:	DATE:	STATUS:

THIS PLAN SHALL NOT BE MODIFIED WITHOUT WRITTEN PERMISSION FROM SEBAGO TECHNICS, INC. ANY ALTERATIONS, AUTHORIZED OR OTHERWISE, SHALL BE AT THE USER'S SOLE RISK AND WITHOUT LIABILITY TO SEBAGO TECHNICS, INC.

022490.dwg, TAB: C