


PORTLAND HOUSING AUTHORITY

Portland, Maine


ISSUED FOR REVIEW

RIVERTON PARK BOILER REPLACEMENTS: BUILDING NOS 12,17,25

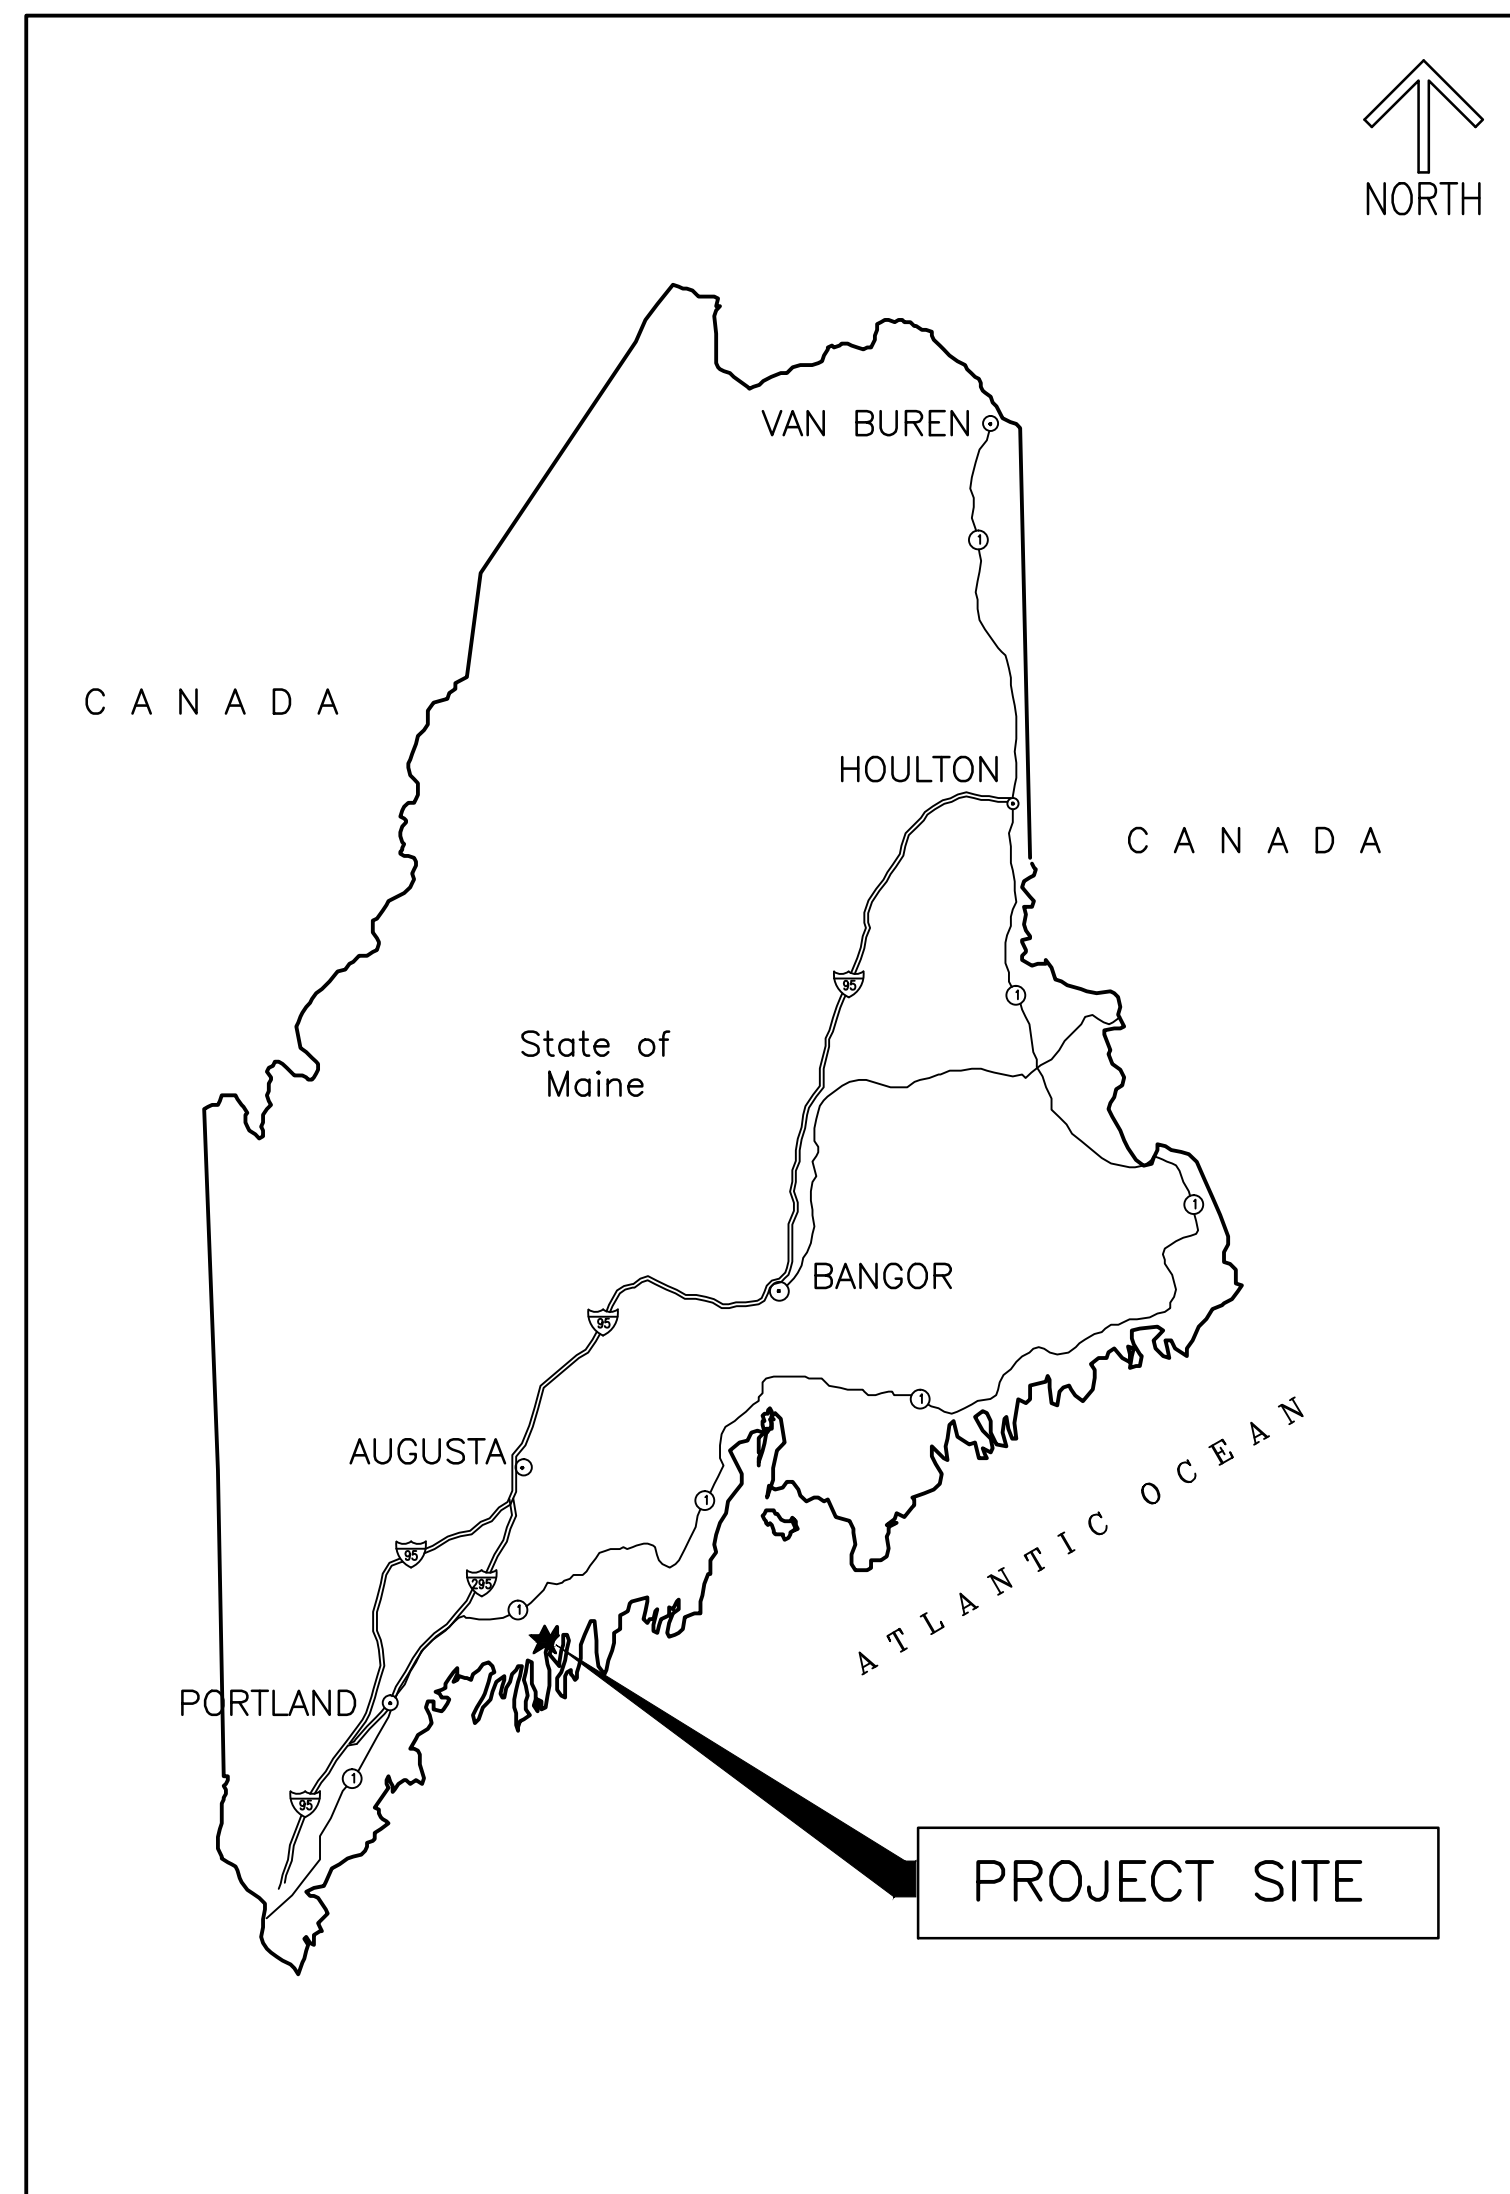

VICINITY MAP
SCALE: N.T.S.

DRAWING INDEX		
DRAWING	TITLE	SHEET NUMBER
G-001	COVER SHEET	1 OF 17
A-3	BUILDING PLAN, DEMOLITION PLANS, FLOOR PLAN, ELEVATIONS	2 OF 17
A-4	SECTIONS, DETAILS, SCHEDULES	3 OF 17
M-001	MECHANICAL LEGEND, ABBREVIATIONS AND GENERAL NOTES	4 OF 17
MS-101	MECHANICAL SITE PLANS	5 OF 17
MD-101	MECHANICAL DEMOLITION PLAN	6 OF 17
MD-401	MECHANICAL DEMOLITION PART PLANS	7 OF 17
M-101	MECHANICAL FIRST FLOOR PLAN - HEATING HOT WATER	8 OF 17
M-102	MECHANICAL FIRST FLOOR PLAN - PLUMBING	9 OF 17
M-401	MECHANICAL PART PLANS	10 OF 17
M-501	MECHANICAL DETAILS	11 OF 17
M-502	MECHANICAL SCHEMATICS	12 OF 17
M-601	MECHANICAL DETAILS	13 OF 17
E-001	ELECTRICAL LEGEND, ABBREVIATIONS AND GENERAL NOTES	14 OF 17
ED-101	ELECTRICAL DEMOLITION PLAN	15 OF 17
E-101	ELECTRICAL PLAN	16 OF 17
E-601	ELECTRICAL SCHEDULES	17 OF 17

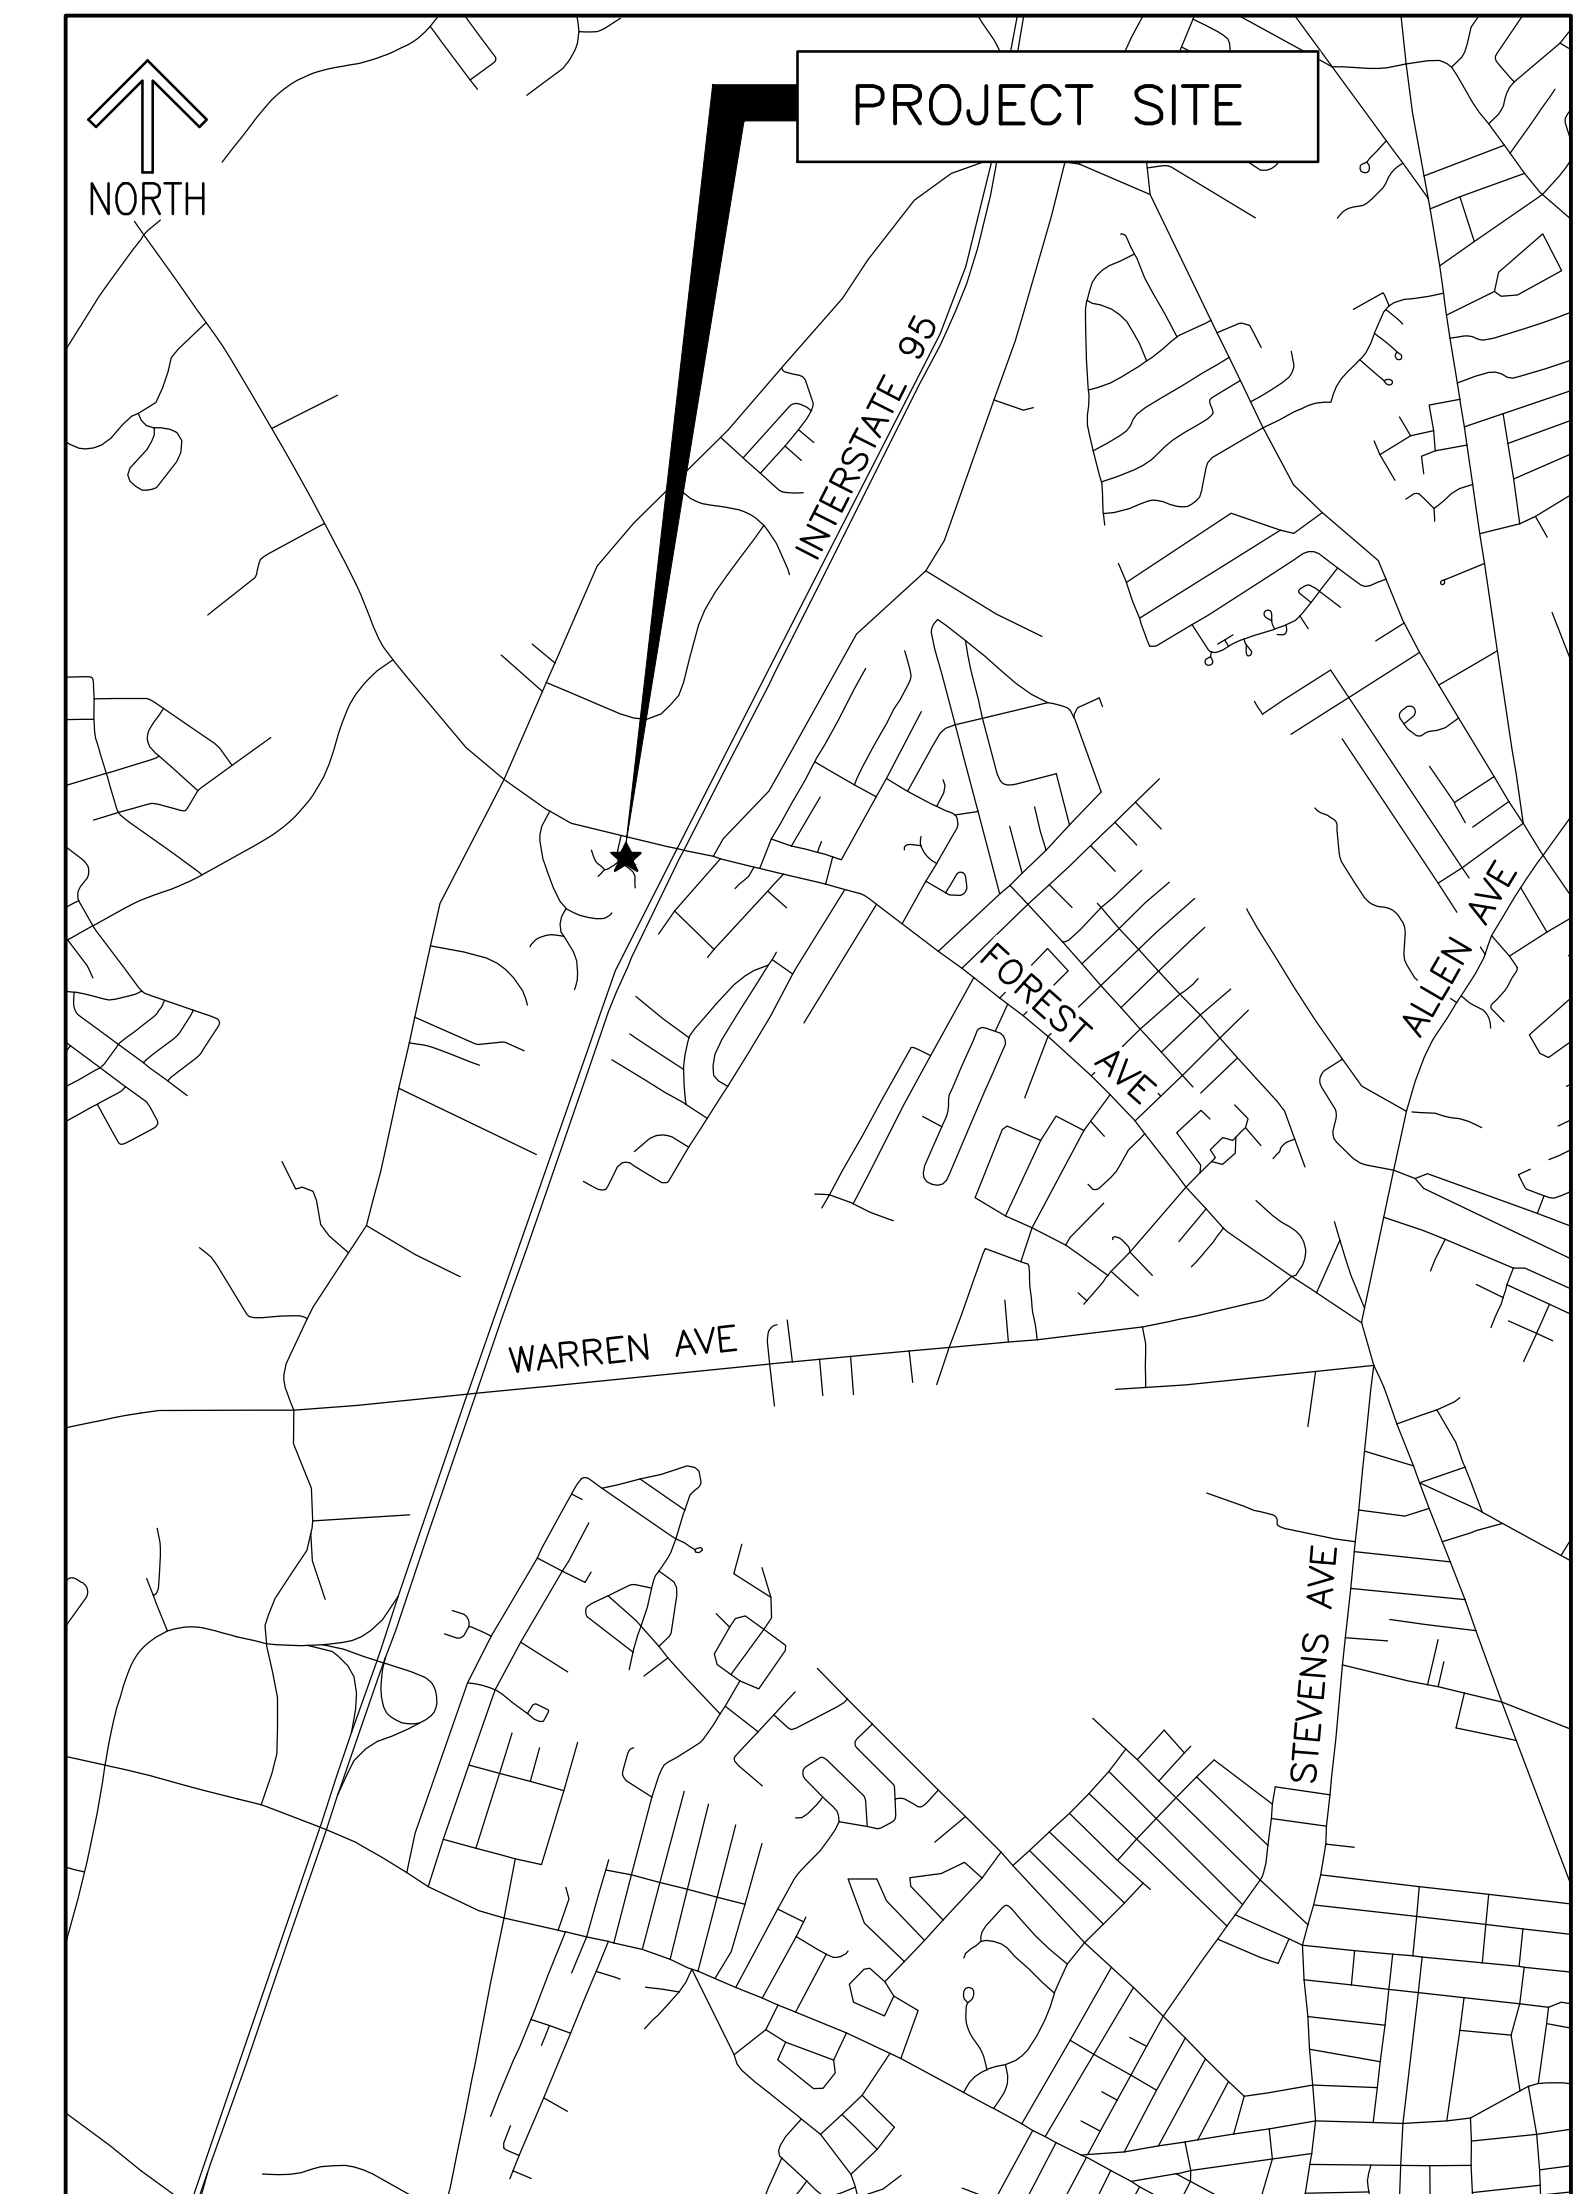

LOCATION MAP
SCALE: N.T.S.

				PORTLAND HOUSING AUTHORITY PORTLAND, MAINE			
				RIVERTON BOILER REPLACEMENTS BUILDING NOS 12,17,25			
				COVER SHEET			
0	ISSUED FOR CONSTRUCTION	CSS	ERP	9-8-15			
REV	DESCRIPTION	DWN	APP	DATE			
PLEASE NOTE: THIS DOCUMENT MAY NOT ACCURATELY REPRESENT THE FINAL DOCUMENT. ONLY AN ENGINEER, ARCHITECT OR SURVEYOR SIGNED, SEALED AND DATED PAPER COPY, PROVIDED BY THIS OFFICE, MAY BE UTILIZED FOR BIDDING OR CONSTRUCTION PURPOSES.				SIZE: ANSI D DATE: 9-8-15 DES BY: ERP DWN BY: CSS CKD BY: MIF		PROJECT NO. 218.011.001 SHEET 1 OF 17	
				G-001			