


PORTLAND HOUSING AUTHORITY

Portland, Maine

ISSUE FOR BID


RIVERTON HEAD START BUILDING NO. 14

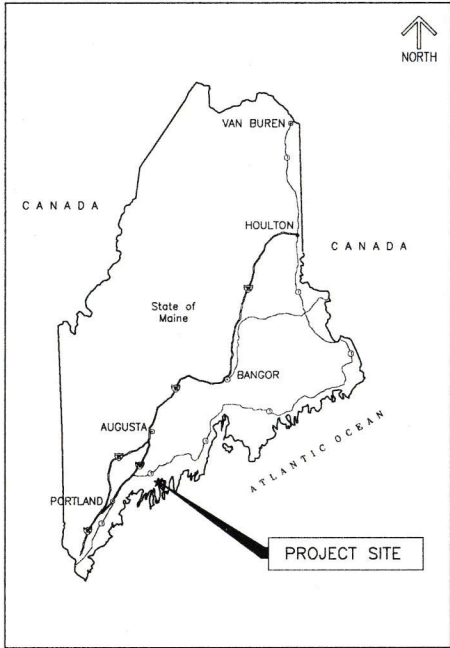

VICINITY MAP
SCALE: N.T.S.

DRAWING INDEX		
DRAWING	TITLE	SHEET NUMBER
G-001	COVER SHEET	1 OF 16
G-101	GENERAL SITE LAYOUT	2 OF 16
LS-101	LIFE SAFETY PLAN	3 OF 16
S-001	STRUCTURAL GENERAL NOTES	4 OF 16
S-101	STRUCTURAL FLOOR PLANS	5 OF 16
S-501	STRUCTURAL DETAILS	6 OF 16
A-001	NOTES, LEGEND, ABBREVIATIONS AND SPECIFICATIONS	7 OF 16
A-002	TYPICAL ACCESSIBLE CLEARANCES	8 OF 16
AD-101	ARCHITECTURAL DEMOLITION PLANS	9 OF 16
A-101	ARCHITECTURAL FLOOR PLANS	10 OF 16
A-501	ARCHITECTURAL DETAILS	11 OF 16
M-001	MECHANICAL LEGEND, NOTES, ABBREVIATIONS	12 OF 16
MD-101	MECHANICAL DEMOLITION FLOOR PLANS	13 OF 16
M-101	MECHANICAL FLOOR PLANS	14 OF 16
E-001	ELECTRICAL LEGEND, NOTES, ABBREVIATIONS	15 OF 16
E-101	ELECTRICAL FLOOR PLANS	16 OF 16

BID ALTERNATE LIST	
DEDUCTIVE ALTERNATE NO.1:	REMOVE WASHER & DRYER
DEDUCTIVE ALTERNATE NO.2:	REMOVE LED LIGHTING UPGRADE
DEDUCTIVE ALTERNATE NO.3:	REMOVE FIRST FLOOR BATHROOM EXPANSION

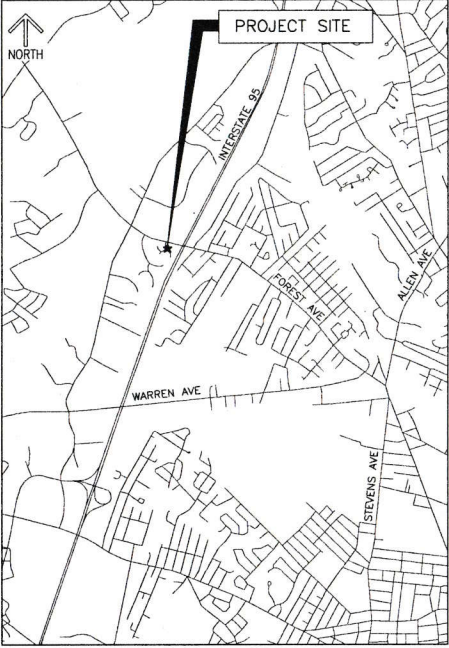

LOCATION MAP
SCALE: N.T.S.

				PORTLAND HOUSING AUTHORITY PORTLAND, MAINE	
				PHA RIVERTON HEAD START BUILDING 14, UNITS 102 AND 104	
				COVER SHEET	
0	ISSUED FOR BID	GJN	DMG	05/10/17	
REV	DESCRIPTION	DWN	APP	DATE	
		SIZE	ANSI D		PROJECT NO.
		DATE	02/28/17		218.021.001
		DES BY	GJN		SHEET
		DWN BY	GJN		01 OF 16
		CHK BY	BLB		

PLEASE NOTE THIS DOCUMENT MAY NOT ACCURATELY REPRESENT THE FINAL DOCUMENT. ONLY AN ENGINEER, ARCHITECT OR SURVEYOR SEIGNED, SEALED AND DATED PAPER COPY PRODUCED BY THIS OFFICE, MAY BE UTILIZED FOR BIDDING OR CONSTRUCTION PURPOSES.



423 Oak Street
Portland, ME 04101
207.557.7077
colbycompany.com

DATE: 02/28/17
DES BY: GJN
DWN BY: GJN
CHK BY: BLB

PROJECT NO. 218.021.001
DRAWING NO. G-001
SHEET 01 OF 16

X:\218 PHA Riverton Head Start\218.021.001 - Riverton Head Start\218.021.001.dwg - 5/10/17 10:42 AM - JAWAC - DE LAJARRA