


GRANT HAYS
ASSOCIATES

ARCHITECTURE & INTERIOR DESIGN
P.O. BOX 6179 FALMOUTH MAINE 04105
207.871.5900 www.granthays.com

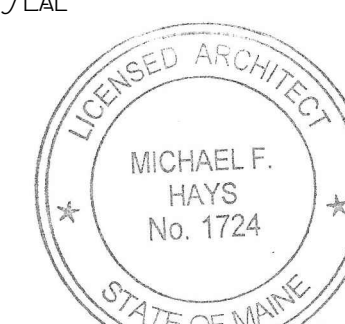

Michael F. Hays

REVISION
10 MAY '16

PROJECT NAME

foundation
BREWING COMPANY
EXPANSION

PORTLAND, MAINE 04103
ONE INDUSTRIAL WAY

SHEET

DEMOLITION
PLAN

DATE
15 MAR '16

SCALE
1/8"=1'-0"

DRAWN
MFH/mgk

JOB NO.
160201


SHEET

A2

COPYRIGHT
REPRODUCTION OR RELIEF OF THIS
DOCUMENT WITHOUT WRITTEN
PERMISSION FROM GRANT HAYS
ASSOCIATES IS PROHIBITED.


DEMOLITION LEGEND

- | | |
|---|--|
| <p>1 REMOVE INTERIOR WALLS, INCLUDING DOOR & FRAME, CEILING FRAMING, FINISHES, AND ANY ASSOCIATED PLUMBING, ELECTRICAL, AND SPRINKLER DROPS. MAINTAIN SPRINKLER COVERAGE AT HIGH CEILING AREA ABOVE.</p> <p>2 REMOVE INTERIOR WALLS, INCLUDING DOOR & FRAME, CEILING FRAMING, FINISHES, PLUMBING FIXTURES, AND ANY ASSOCIATED PLUMBING, ELECTRICAL, AND SPRINKLER DROPS. MAINTAIN SPRINKLER COVERAGE AT HIGH CEILING AREA ABOVE.</p> <p>3 REMOVE DOOR AND FRAME. INFILL WALL TO MATCH ADJACENT CONSTRUCTION. PATCH FINISHED TO MATCH ADJACENT SURFACES.</p> <p>4 REMOVE ROUGH-FRAMED/PLYWOOD STORAGE AREA IN ITS ENTIRETY. PATCH FINISHES TO MATCH ADJACENT SURFACES.</p> <p>5 REMOVE INTERIOR WALL AND DOOR/FRAME. SALVAGE DOOR/FRAME FOR OWNER. STORE AS DIRECTED ON SITE. NOT USED.</p> <p>6 REMOVE INTERIOR WALL, INCLUDING ANY ASSOCIATED PLUMBING & ELECTRICAL. PATCH FINISHES TO MATCH ADJACENT SURFACE.</p> <p>7 REMOVE INTERIOR WALL FOR NEW FORKLIFT OPENING.</p> | <p>8 REMOVE PLUMBING FIXTURES. SALVAGE FOR RELOCATION PER OWNER DIRECTION.</p> <p>9 REMOVE INTERIOR WALLS, INCLUDING DOOR & FRAME, AND ANY ASSOCIATED PLUMBING, AND ELECTRICAL. SALVAGE DOOR AND FRAME FOR RELOCATION. MAINTAIN EXISTING CEILING FRAMING AND FINISHES. SEE PROPOSED FLOOR PLAN FOR STRUCTURAL MODIFICATIONS.</p> <p>10 REMOVE INTERIOR WALLS, INCLUDING DOOR & FRAME, FINISHES, PLUMBING FIXTURES, AND ANY ASSOCIATED ELECTRICAL. SEE PROPOSED FLOOR PLAN FOR NEW BATHROOM.</p> <p>11 NO WORK (NIC).</p> |
|---|--|

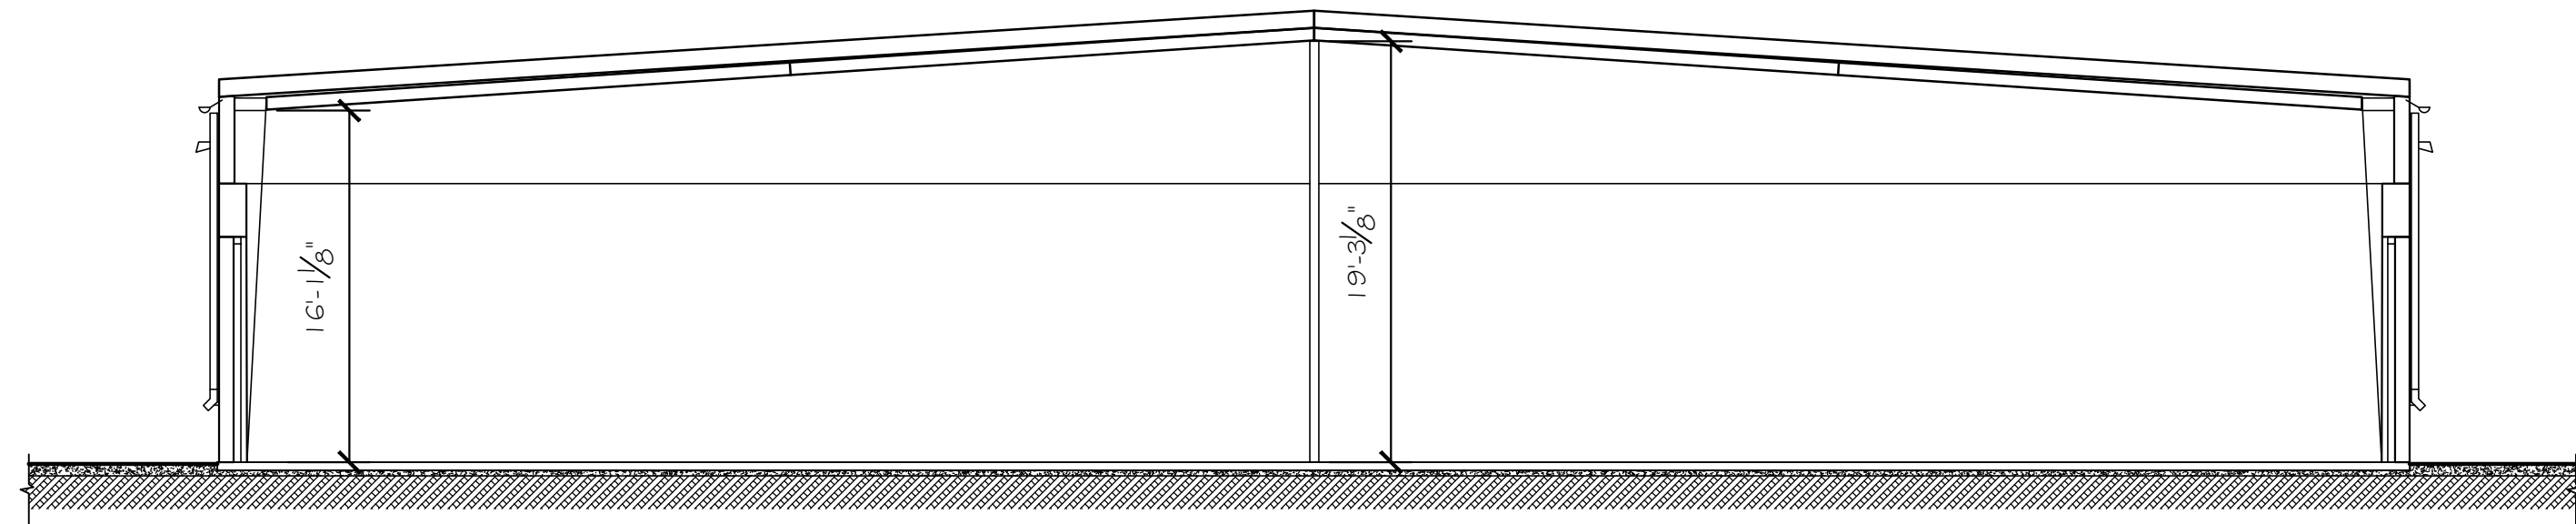

EXISTING BUILDING SECTION
SCALE: 1/8" = 1'-0"

INDUSTRIAL WAY

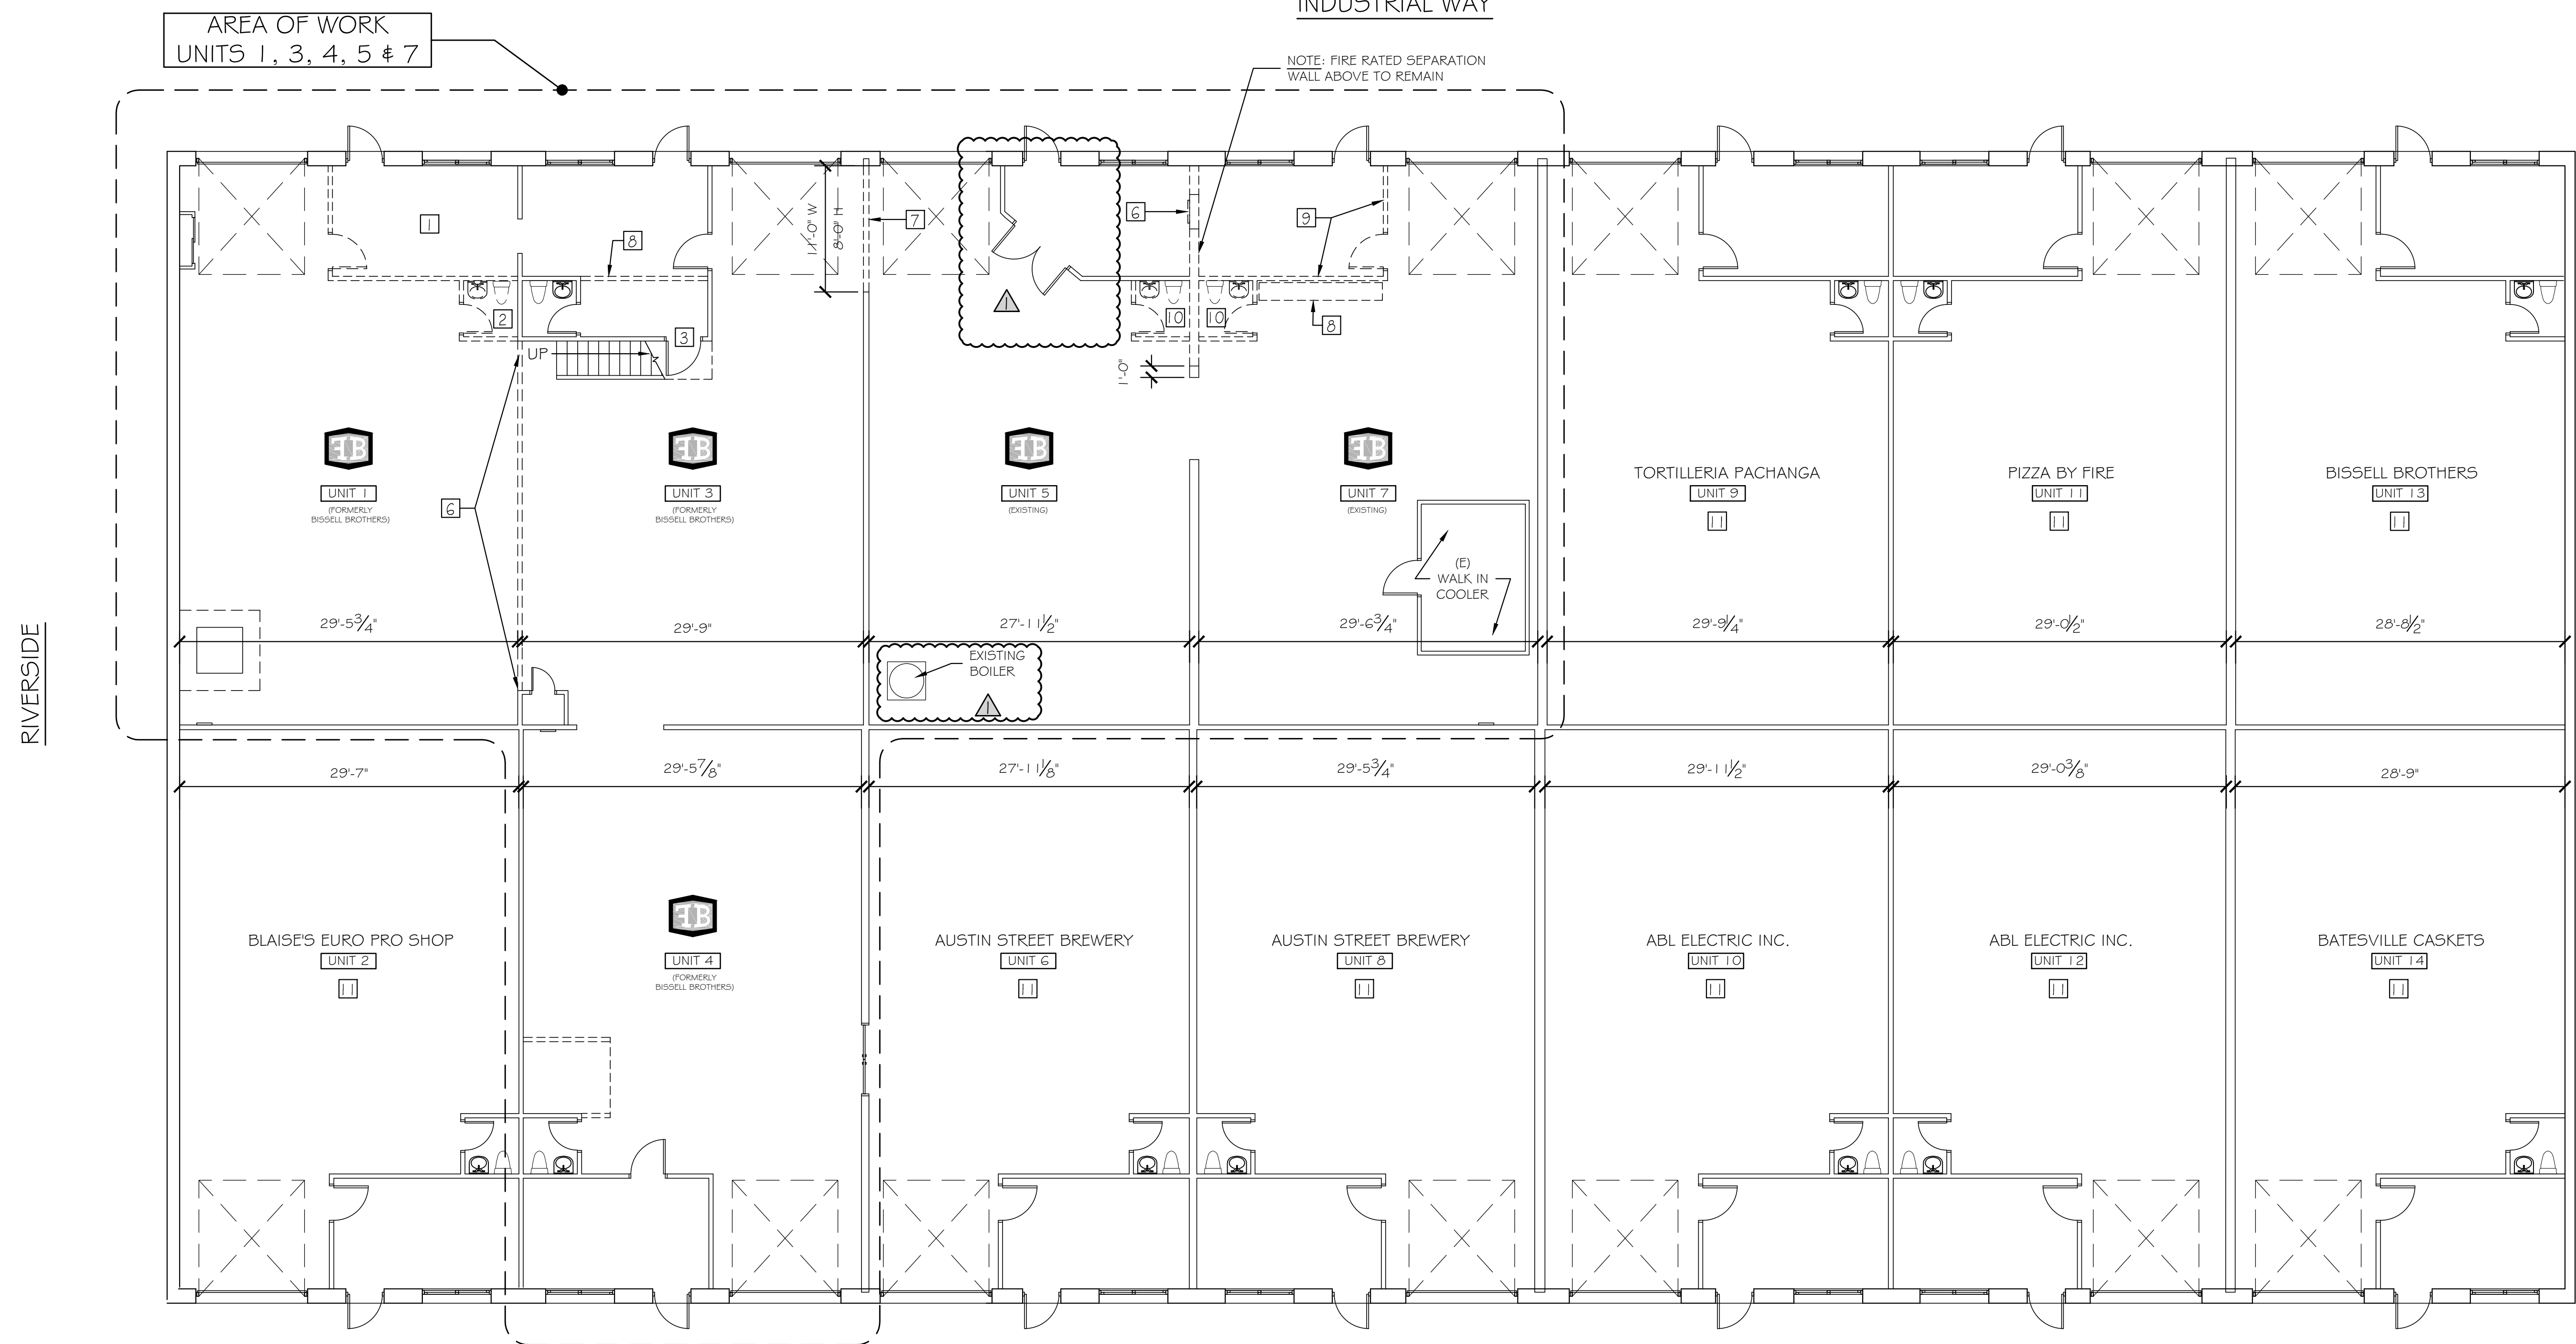

DEMOLITION FLOOR PLAN
SCALE: 1/8" = 1'-0"

