

| REVISION | DESCRIPTION                  | DATE      |
|----------|------------------------------|-----------|
| 0        | ISSUED FOR REVIEW & APPROVAL | 4/21/2016 |

**CUNNINGHAM**  
**Security Systems**  
 10 Princes Point Road, Yarmouth, Maine 04096  
 Office: 207.846.3350 • Fax: 207.846.6080

**FOUNDATION BREWING COMPANY**  
**ONE INDUSTRIAL WAY**  
**PORTLAND, MAINE 04103**  
**FIRE ALARM PLAN**

|          |                                |
|----------|--------------------------------|
| DRAWN    | JPB<br>UNICAD JOB #16253       |
| CHECKED  | WAYNE B. HAWES<br>NCET # 90496 |
| DATE     | 4/21/2016                      |
| REVISION | 0                              |
| SCALE    | 1/8"=1'-0"                     |


**FA-2**

**UNICAD** Inc.  
 Fire Alarm Design & Drafting Services  
 579A W. 40TH ST.  
 PORTLAND, ME 04107  
 OFFICE: 601.865.6410  
 www.unicad.net

**SHEET NOTES:**

- ◇ ADDRESSABLE MONITOR MODULE(S) PROVIDED TO MONITOR ALL WATER FLOW, PRESSURE SWITCHES, WATER SWITCHES AND POS INDICATING VALVES ASSOCIATED WITH THE FIRE SPRINKLER SYSTEM. INSTALLING CONTRACTOR SHALL FIELD VERIFY EXACT MOUNTING, CIRCUITING AND PROGRAMMING REQUIREMENTS. FIELD VERIFY EXACT QUANTITY AND LOCATION(S).

RESERVED FOR CITY STAMP

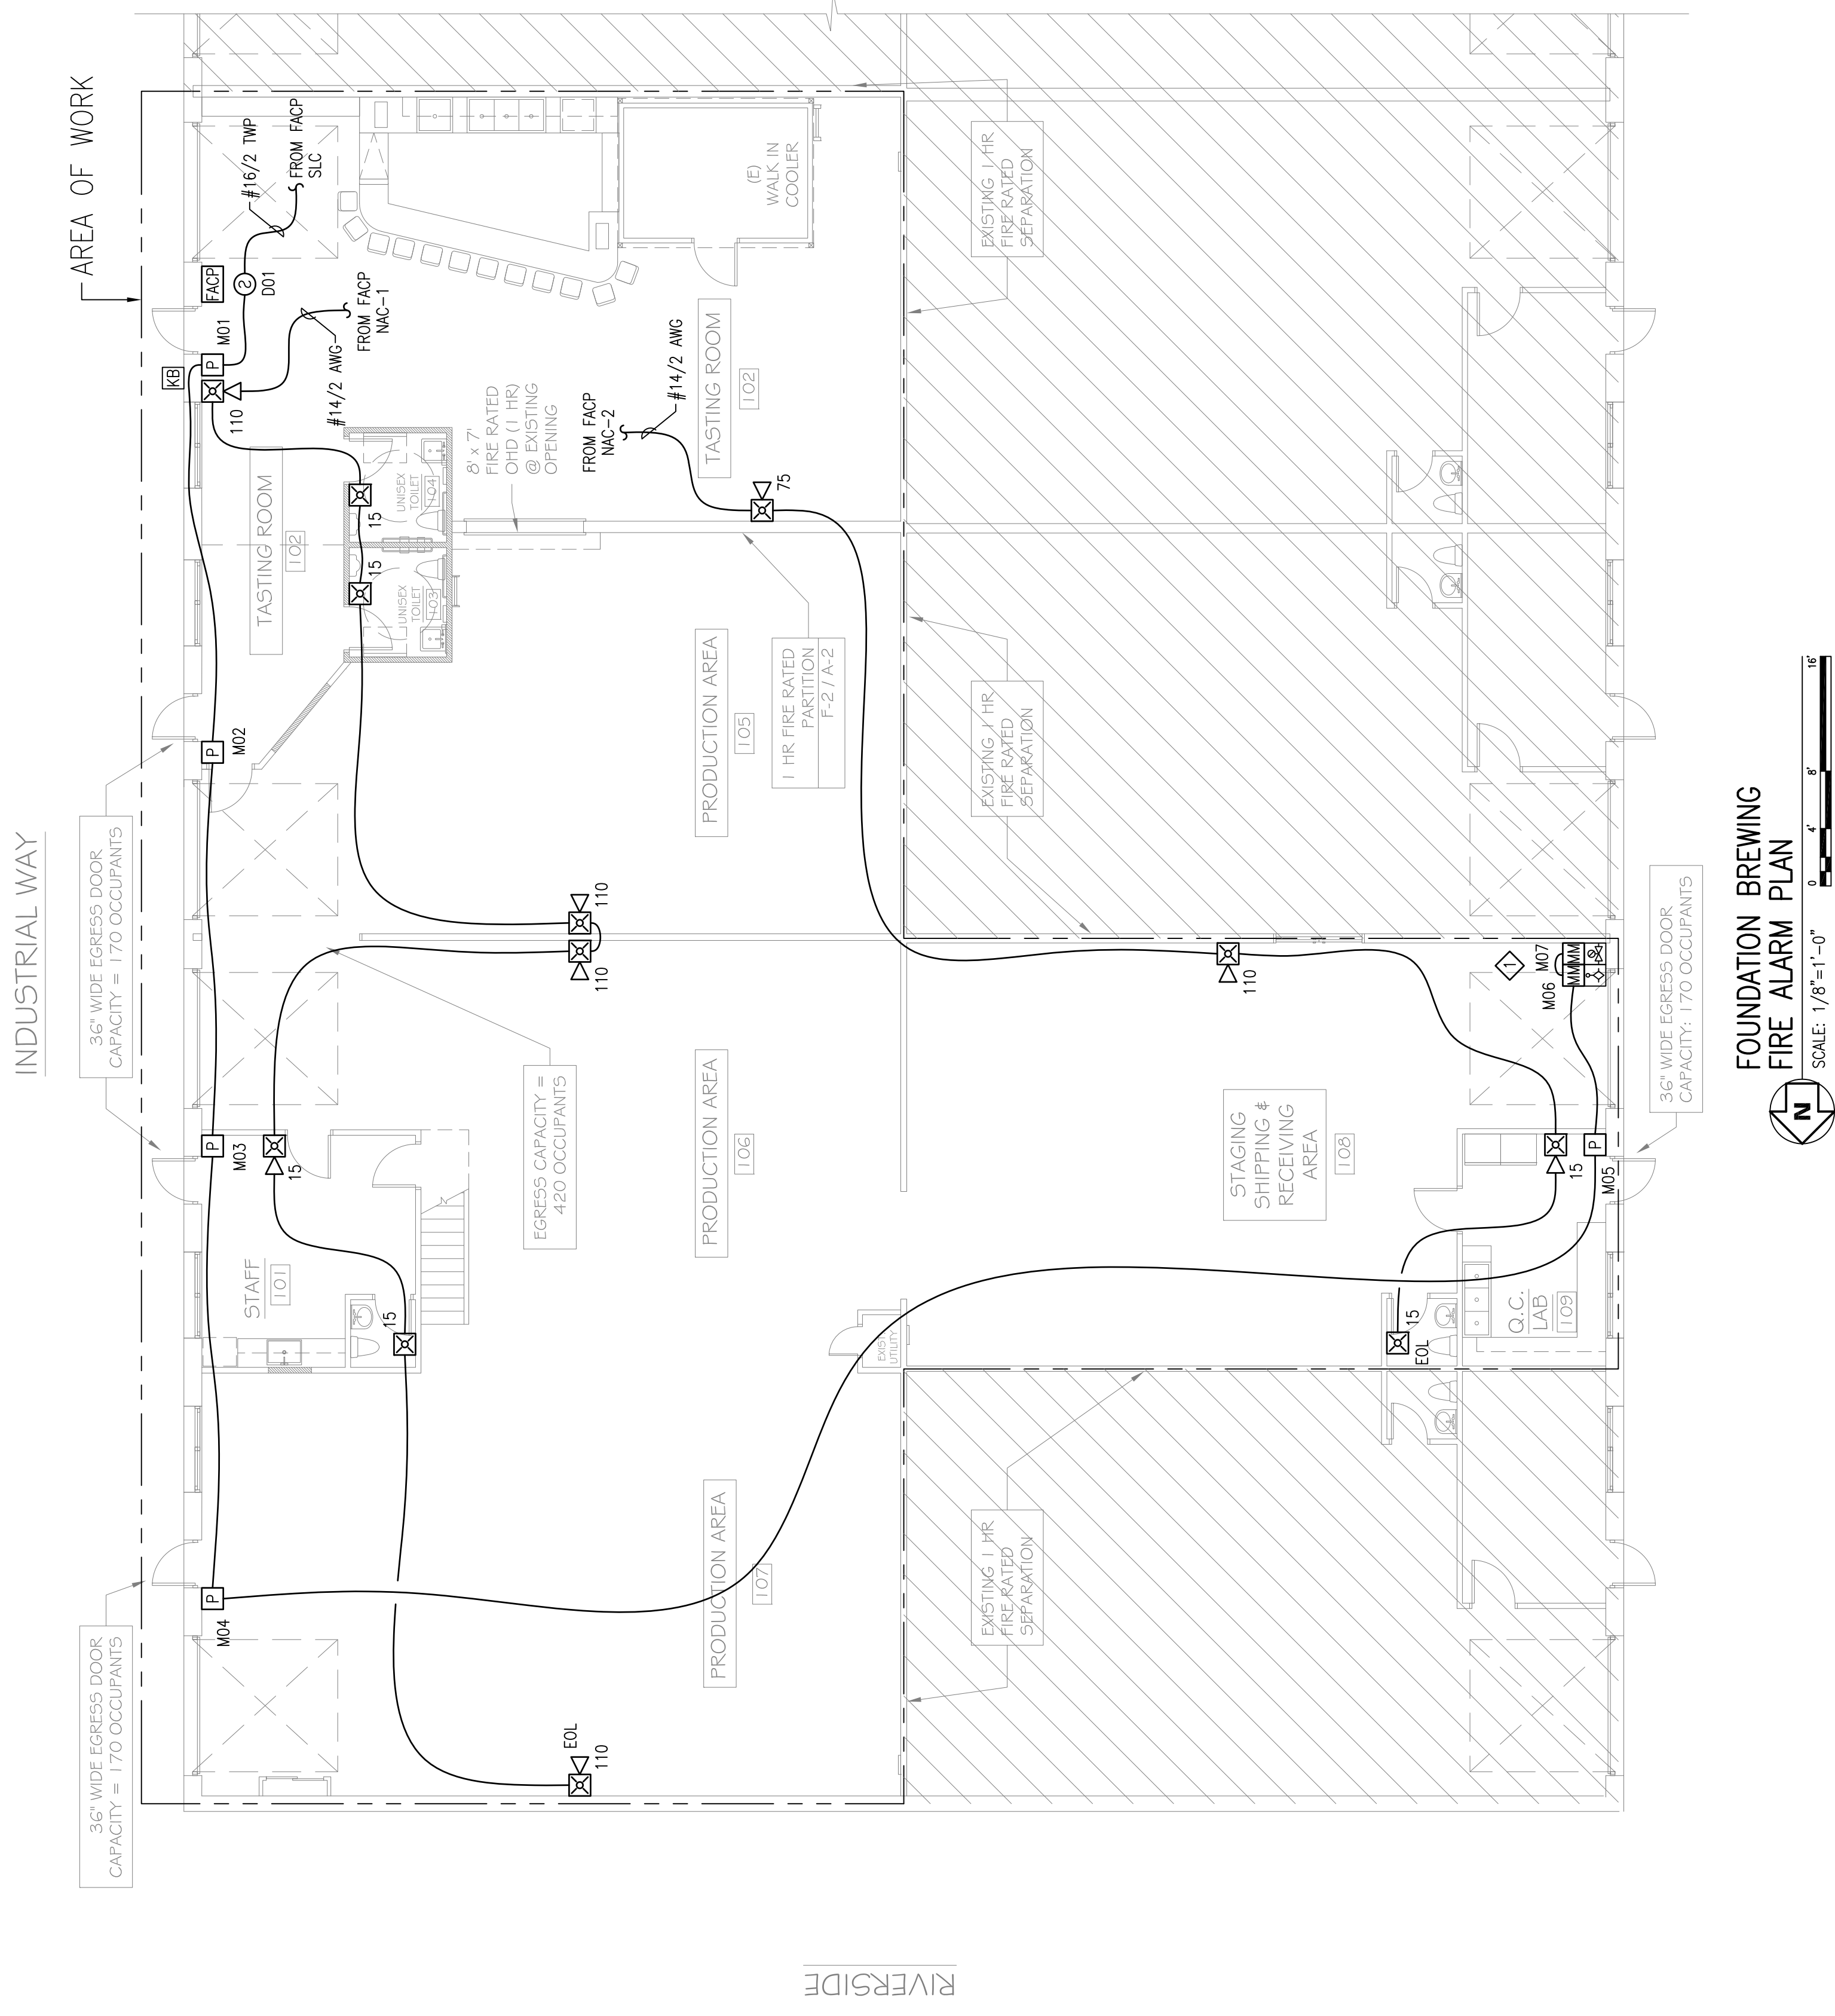

**FOUNDATION BREWING  
 FIRE ALARM PLAN**  
 SCALE: 1/8"=1'-0"



RIVERSIDE