

© 2017 RYAN SENATORE ARCHITECTURE

DEFINITIVE BREWING COMPANY  
35 INDUSTRIAL WAY  
PORTLAND MAINE



RYAN SENATORE  
ARCHITECTURE  
565 CONGRESS STREET  
PORTLAND, MAINE 04101  
207-650-6414  
senatorearchitecture.com

CONSULTANTS:

REVISIONS:

- △ - REVISED - 01/10/18
- △ - REVISED - 01/12/18
- △ - REVISED - 01/17/18
- △ - REVISED - 02/09/18
- △ - REVISED - 03/9/18

DATE: MARCH 6, 2018

PROJECT No. 1772

DRAWN BY: JPF

CHECKED BY: RJS



SCALE: AS NOTED

SHEET TITLE:

FIRST FLOOR  
PLAN

A1-0

WALL LEGEND	
	EXISTING WALL
	NEW WALL

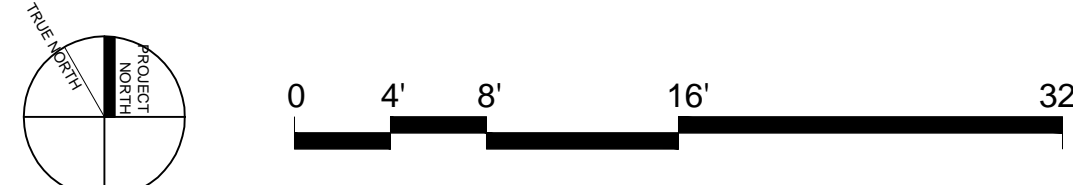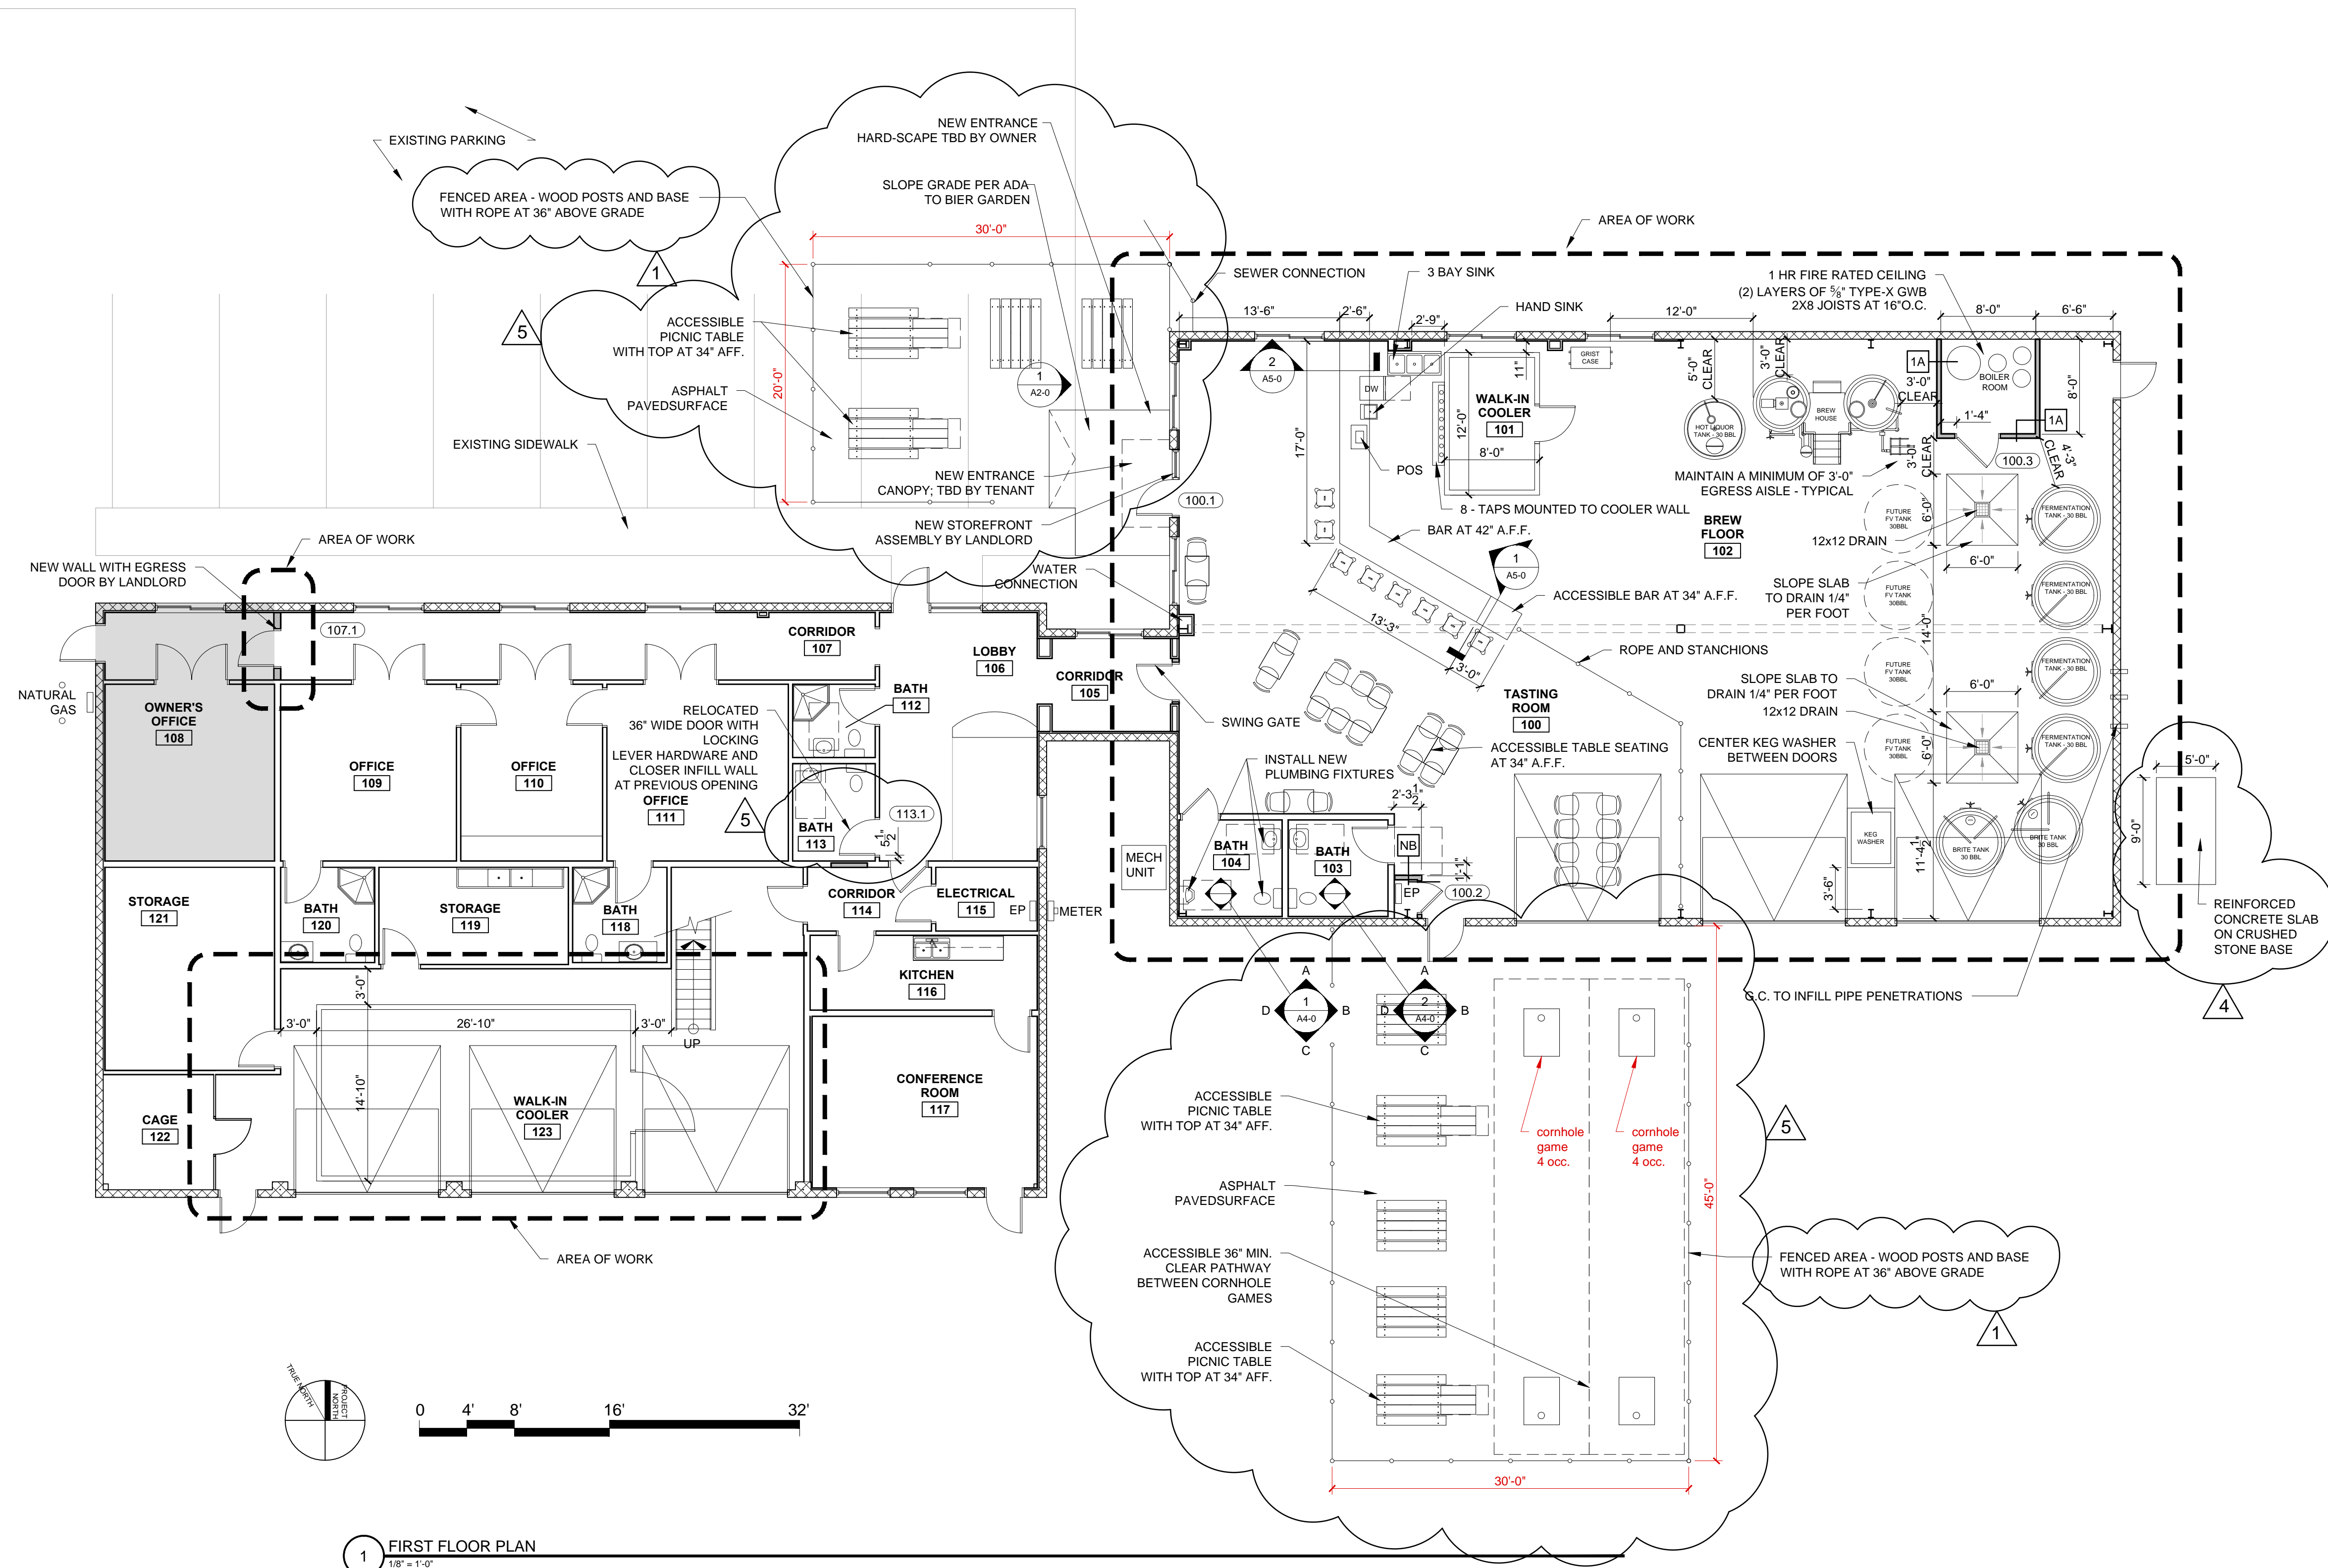

1 FIRST FLOOR PLAN  
1/8" = 1'-0"