



© 2017 RYAN SENATORE ARCHITECTURE

DEFINITIVE BREWING COMPANY
35 INDUSTRIAL WAY
PORTLAND MAINE



RYAN SENATORE
ARCHITECTURE
565 CONGRESS STREET
PORTLAND, MAINE 04101
207-650-8414
senatorearchitecture.com

CONSULTANTS:

REVISIONS:

- △ - REVISED - 01/10/18
- △ - REVISED - 01/12/18
- △ - REVISED - 01/17/18
- △ - REVISED - 02/09/18

DATE: DECEMBER 14, 2017

PROJECT No. 1772

DRAWN BY: JPF

CHECKED BY: RJS



SCALE: AS NOTED

SHEET TITLE:

FIRST FLOOR PLAN

A1-0

WALL LEGEND	
	EXISTING WALL
	NEW WALL

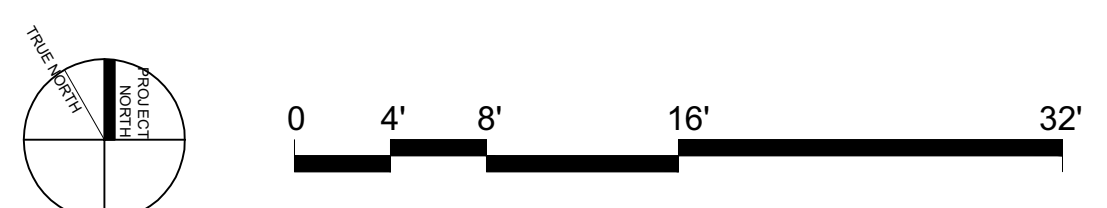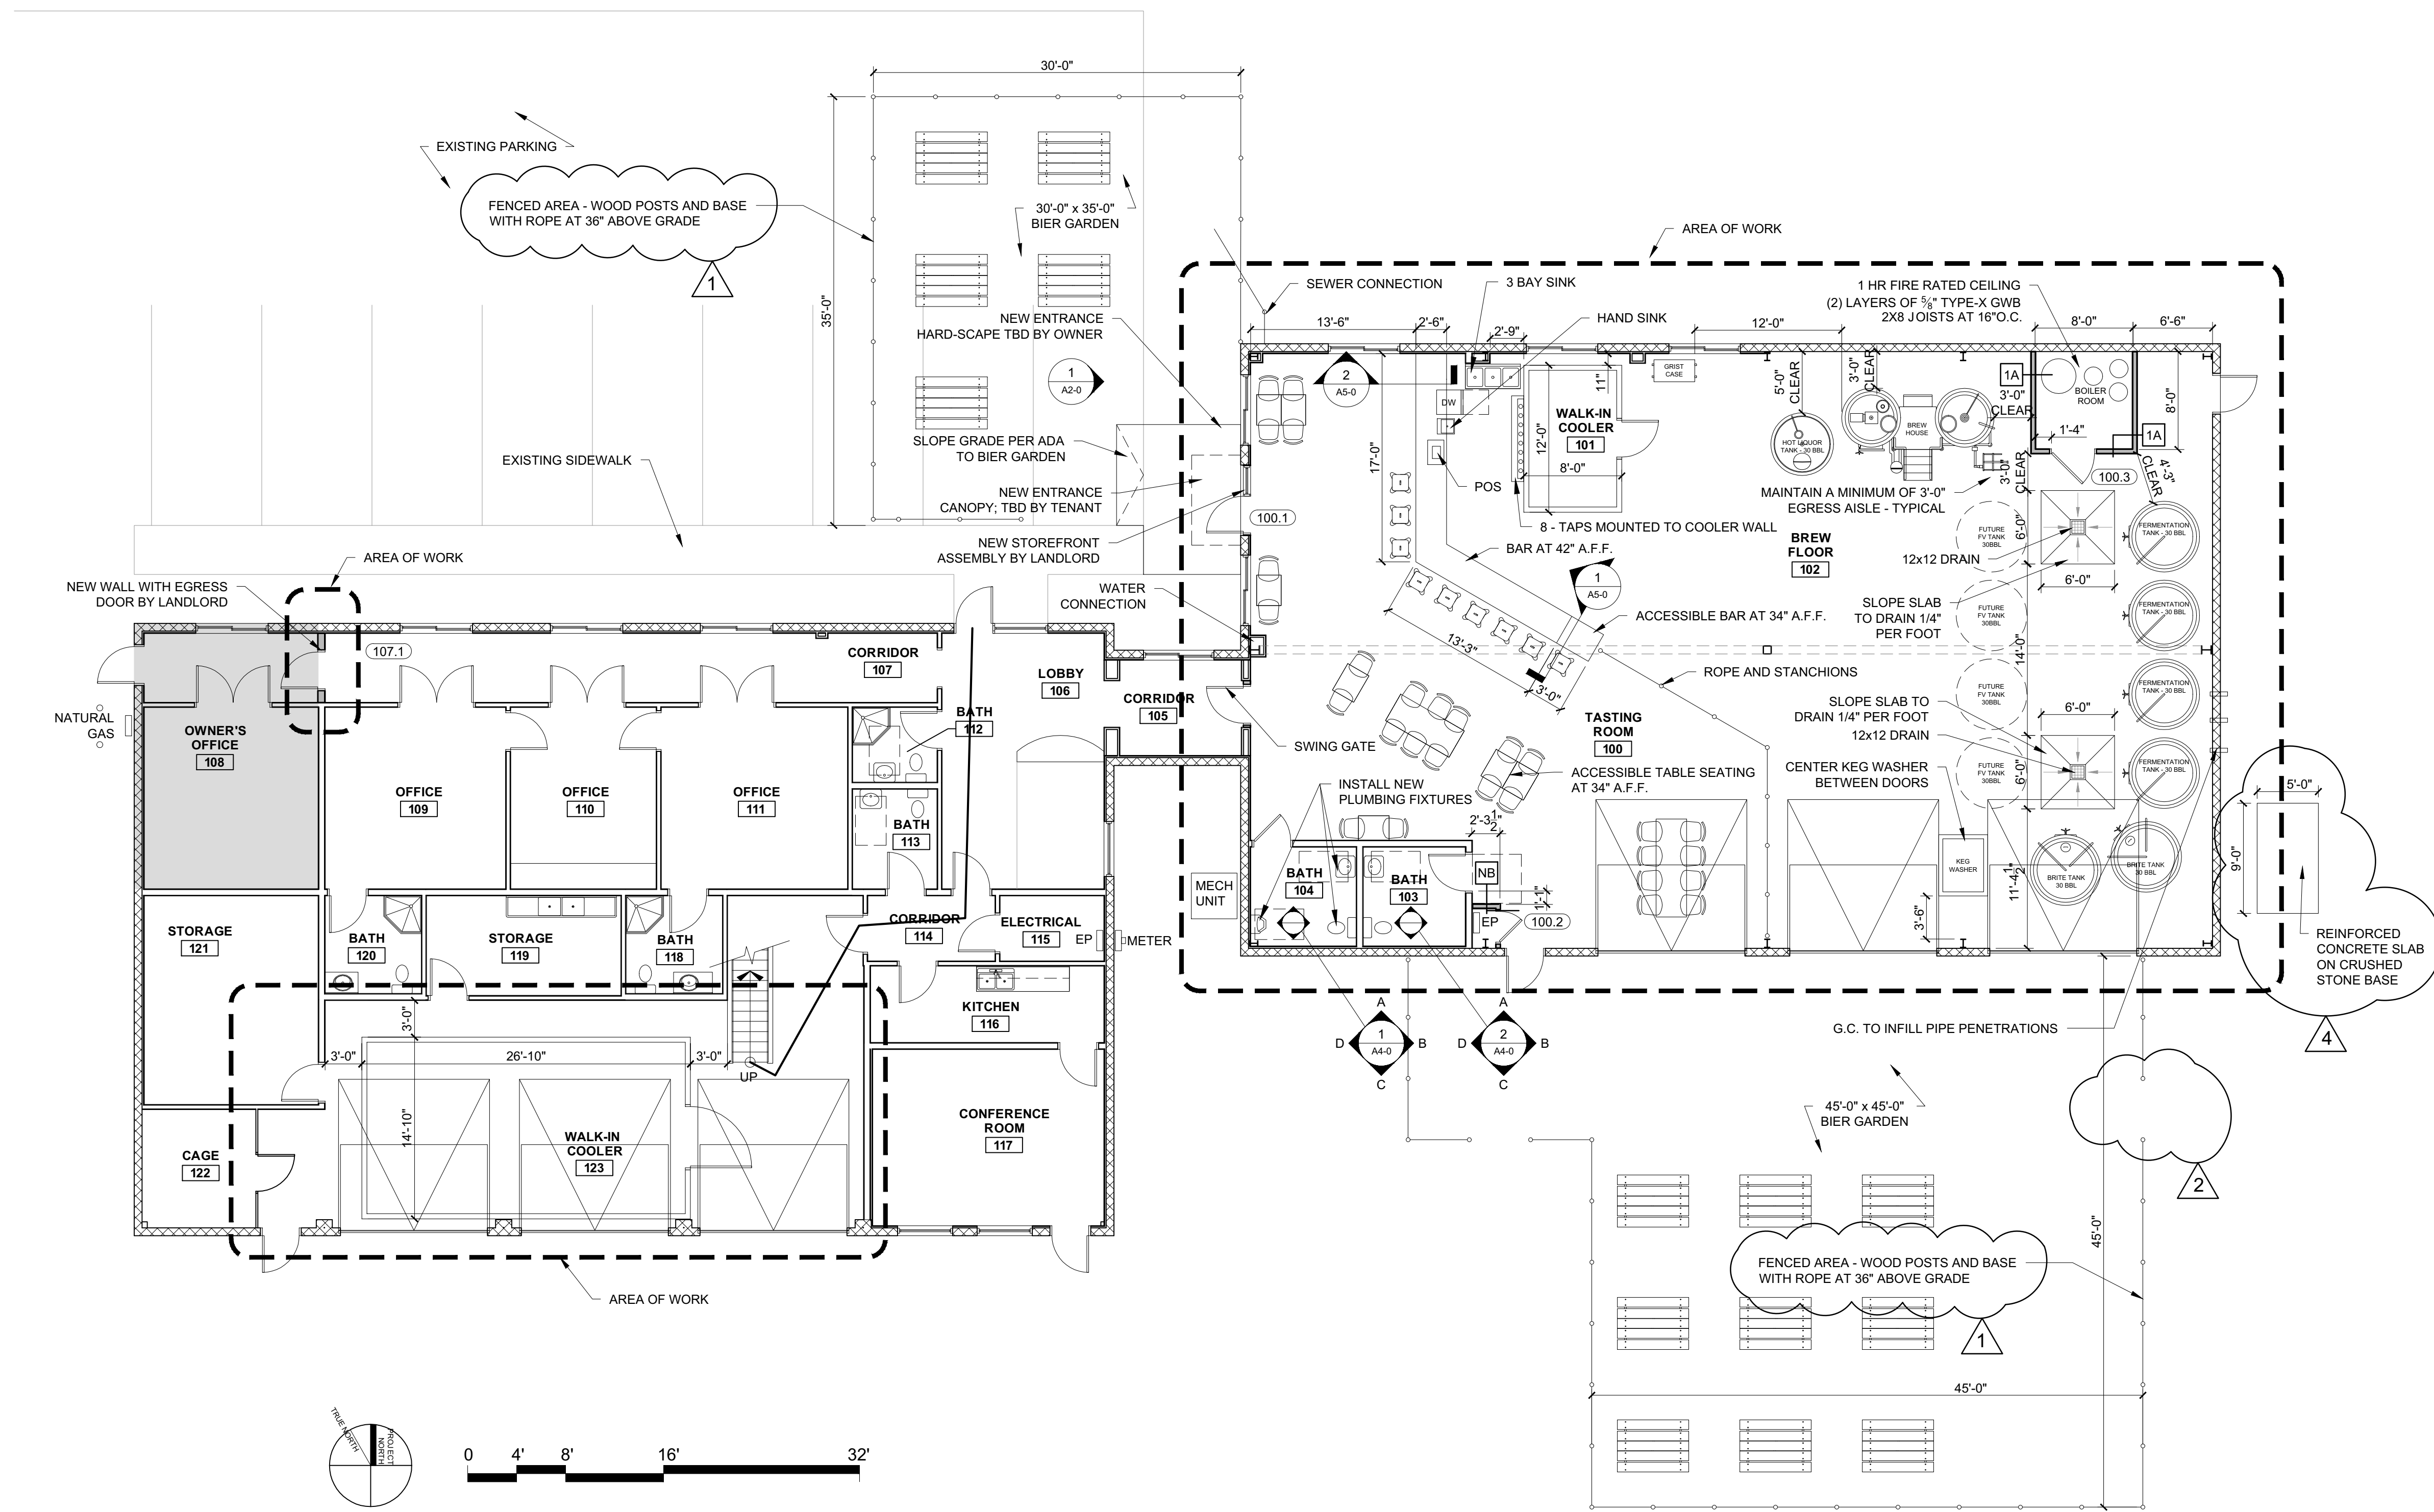

1 FIRST FLOOR PLAN
1/8" = 1'-0"