


REVISIONS		
NO.	DATE	REMARKS
0	12-15-17	PRELIMINARY DESIGN DEVELOPMENT

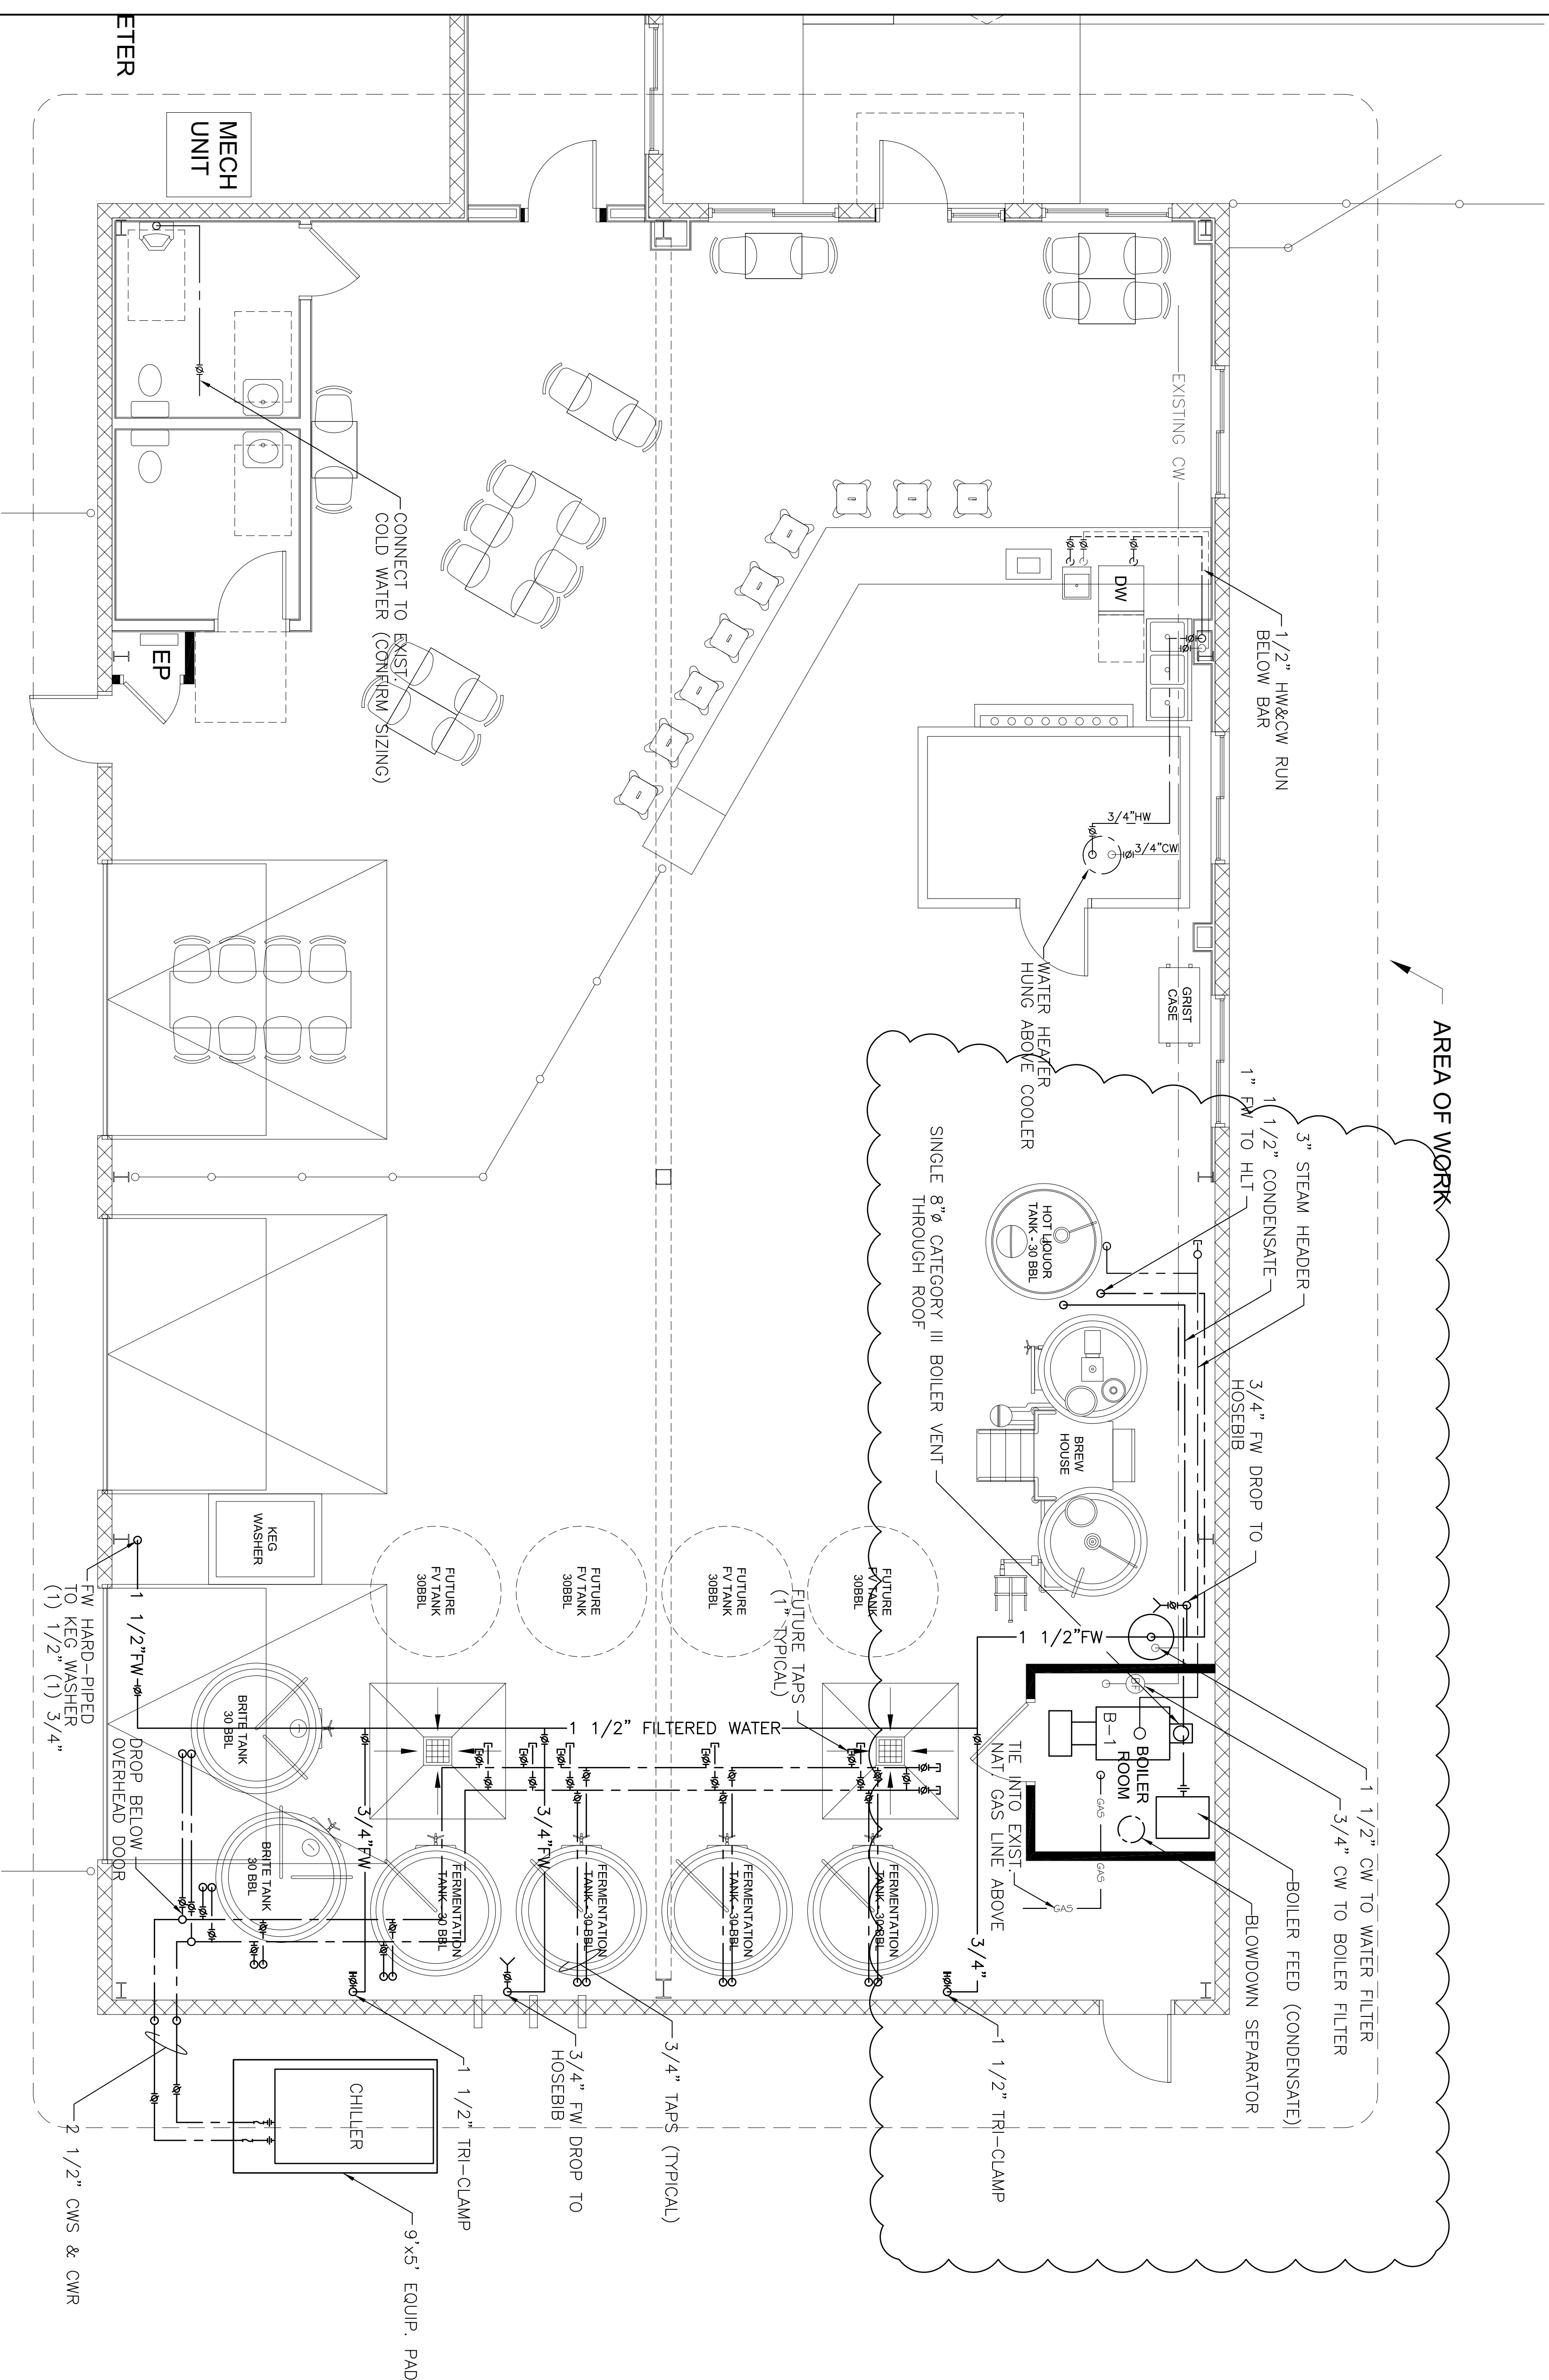

M-101
MECHANICAL PLAN

SCALE: 1/4"=1'-0"

PROJECT: DEFINITIVE BREWERY

PORTLAND, MAINE

Mechanical Systems

Auburn, Maine 207-782-0727

SHEET TITLE: MECHANICAL PLAN BREWERY

SCALE: AS NOTED DATE: 1-15-18

ENGINEER: MEM GRAPHIC SCALE: 0" 1"

DRAWN: MEM

CHECKED BY: THG

CAD FILE: M-101

PROJECT NO: 17-XXX

SHEET NO: M-101