


REVISIONS		
NO.	DATE	REMARKS
0	12-15-17	PRELIMINARY DESIGN DEVELOPMENT

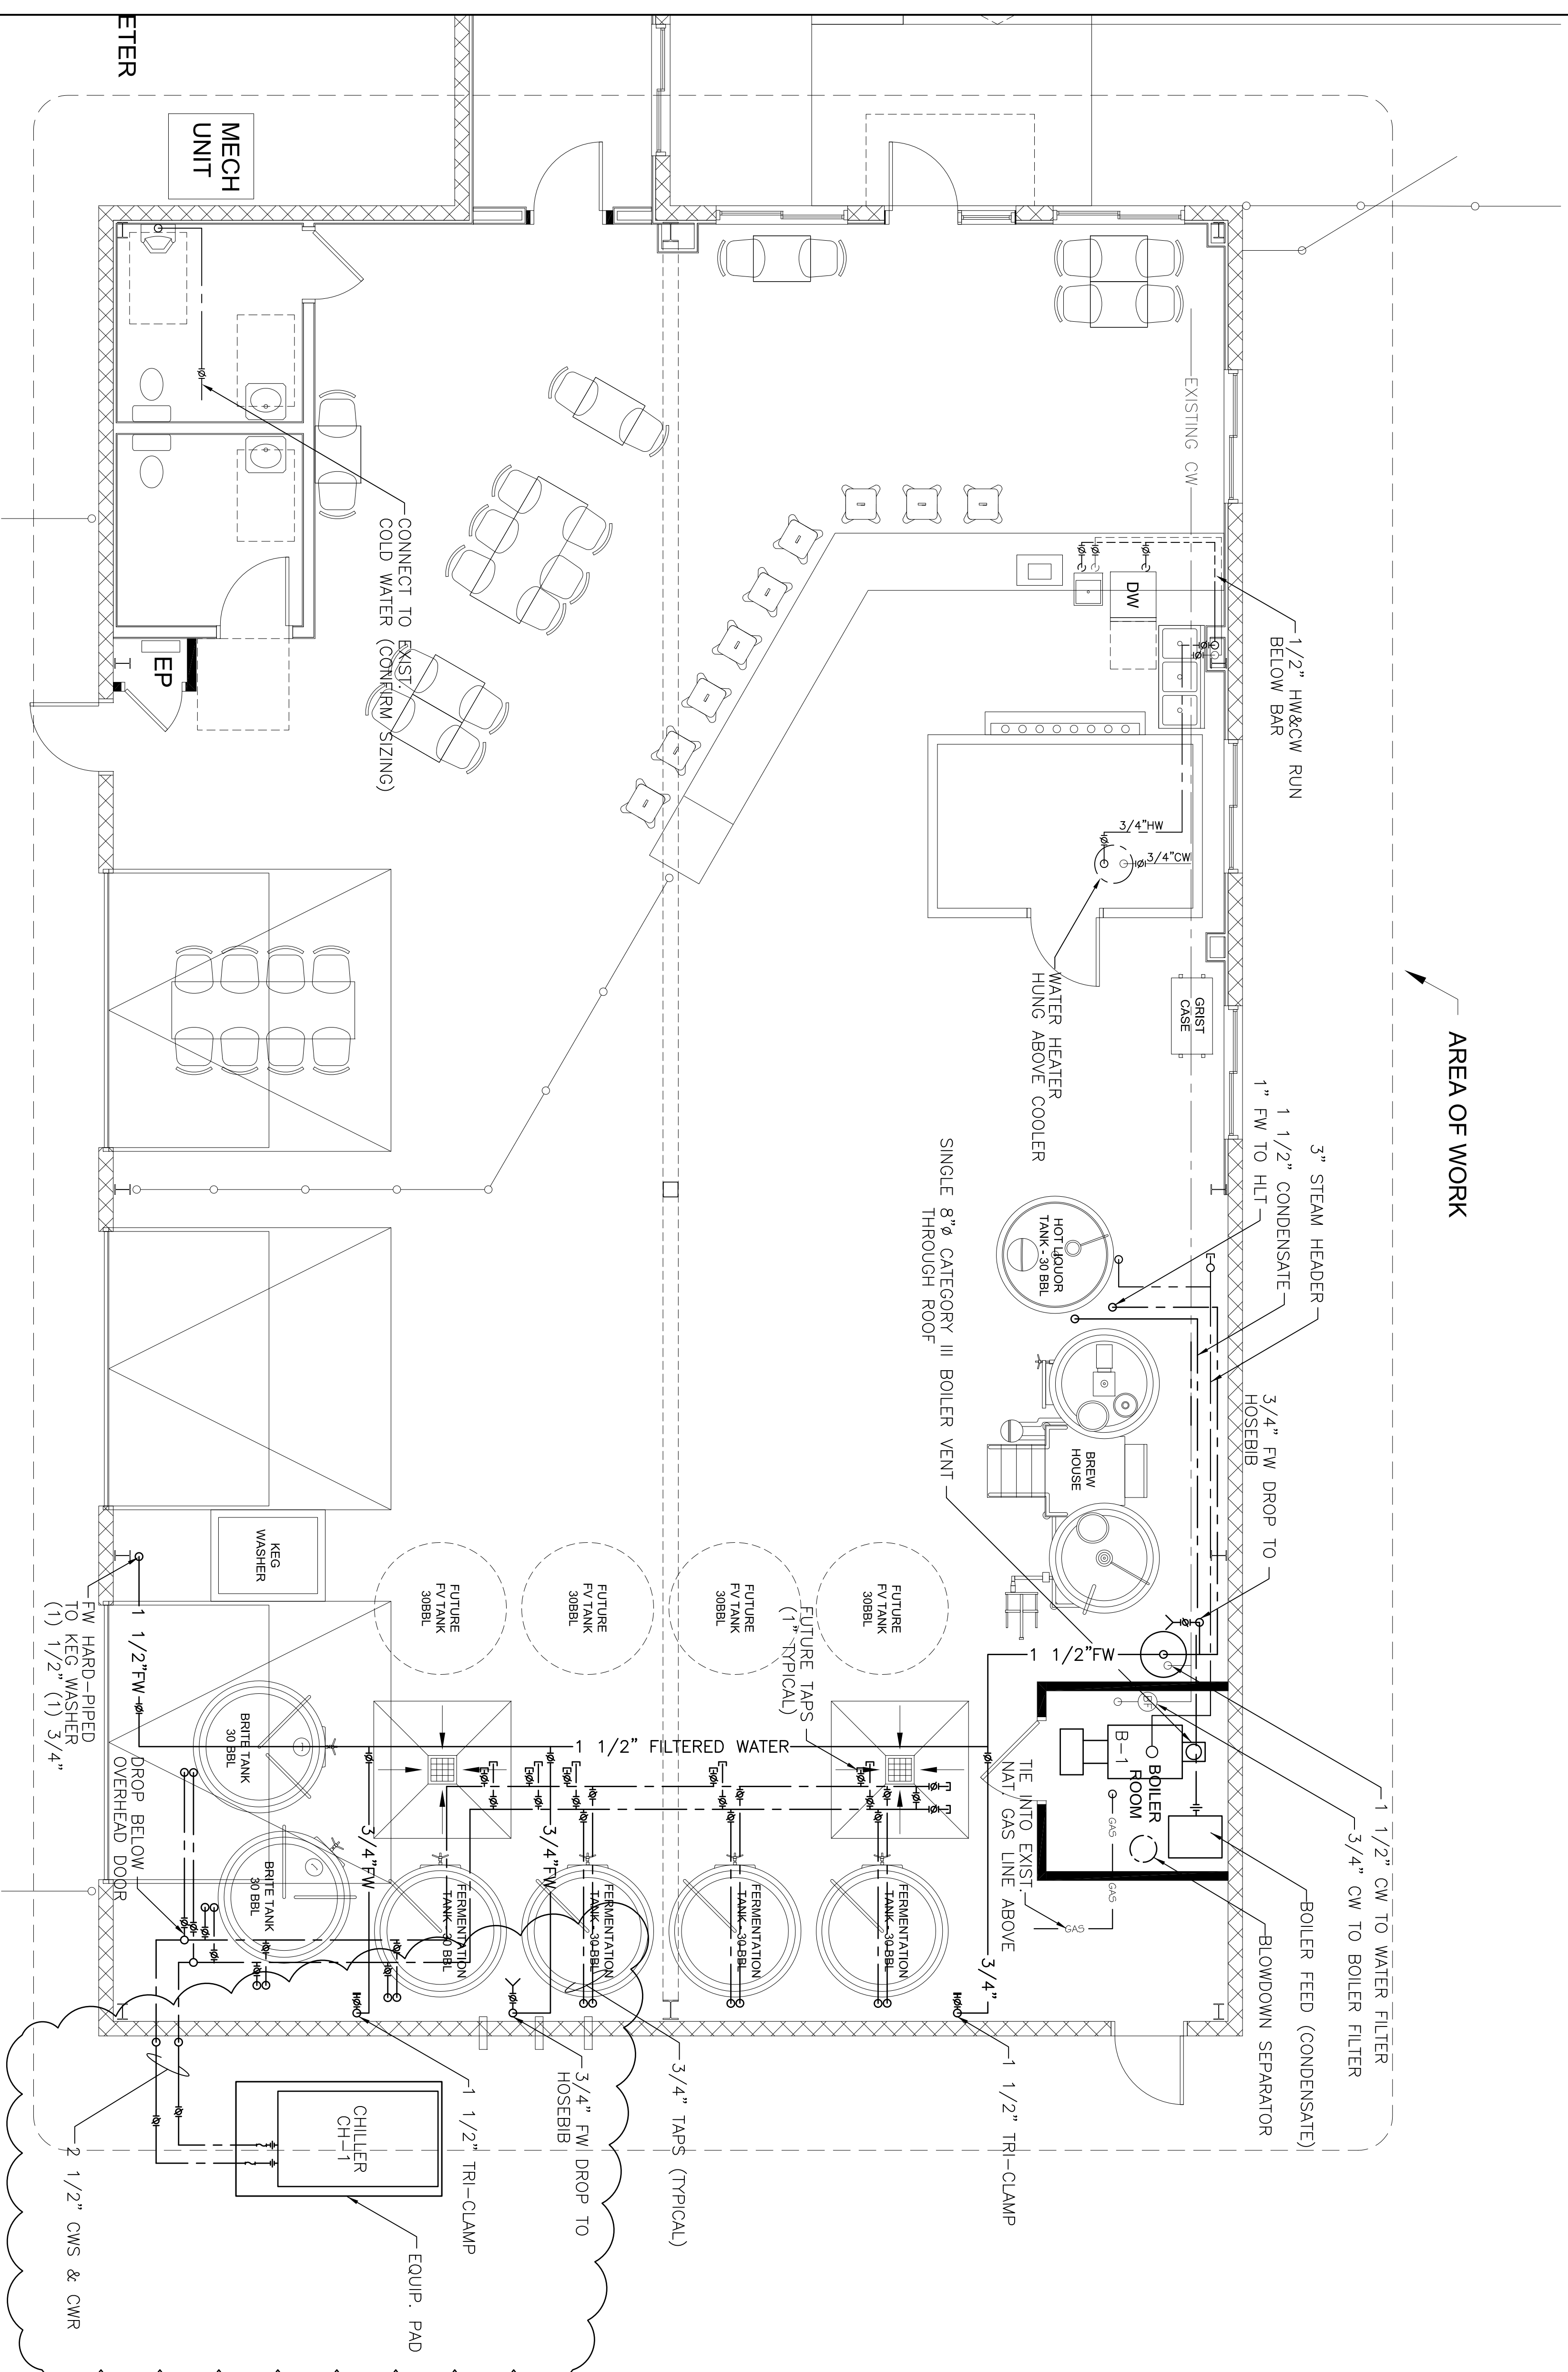

MECHANICAL PLAN

M-101

SCALE: 1/4" = 1'-0"

MECHANICAL PLAN

PROJECT: DEFINITIVE BREWERY

PORTLAND, MAINE

Nason
MECHANICAL SYSTEMS
Auburn, Maine 207-782-0727

SHEET TITLE: MECHANICAL PLAN BREWERY

SCALE: AS NOTED

ENGINEER: MEM

DRAWN: THG

CAD FILE: M-101

PROJECT No. 17-XXX

DATE: 1-15-18

GRAPHIC SCALE: 0" 1"

SHEET No. M-101