

HARRIMAN


AUBURN PORTLAND MANCHESTER

IMMUCELL CORPORATION ADDITION


PORTLAND, MAINE

Harriman Project No. 14326

Key Plan Proj North

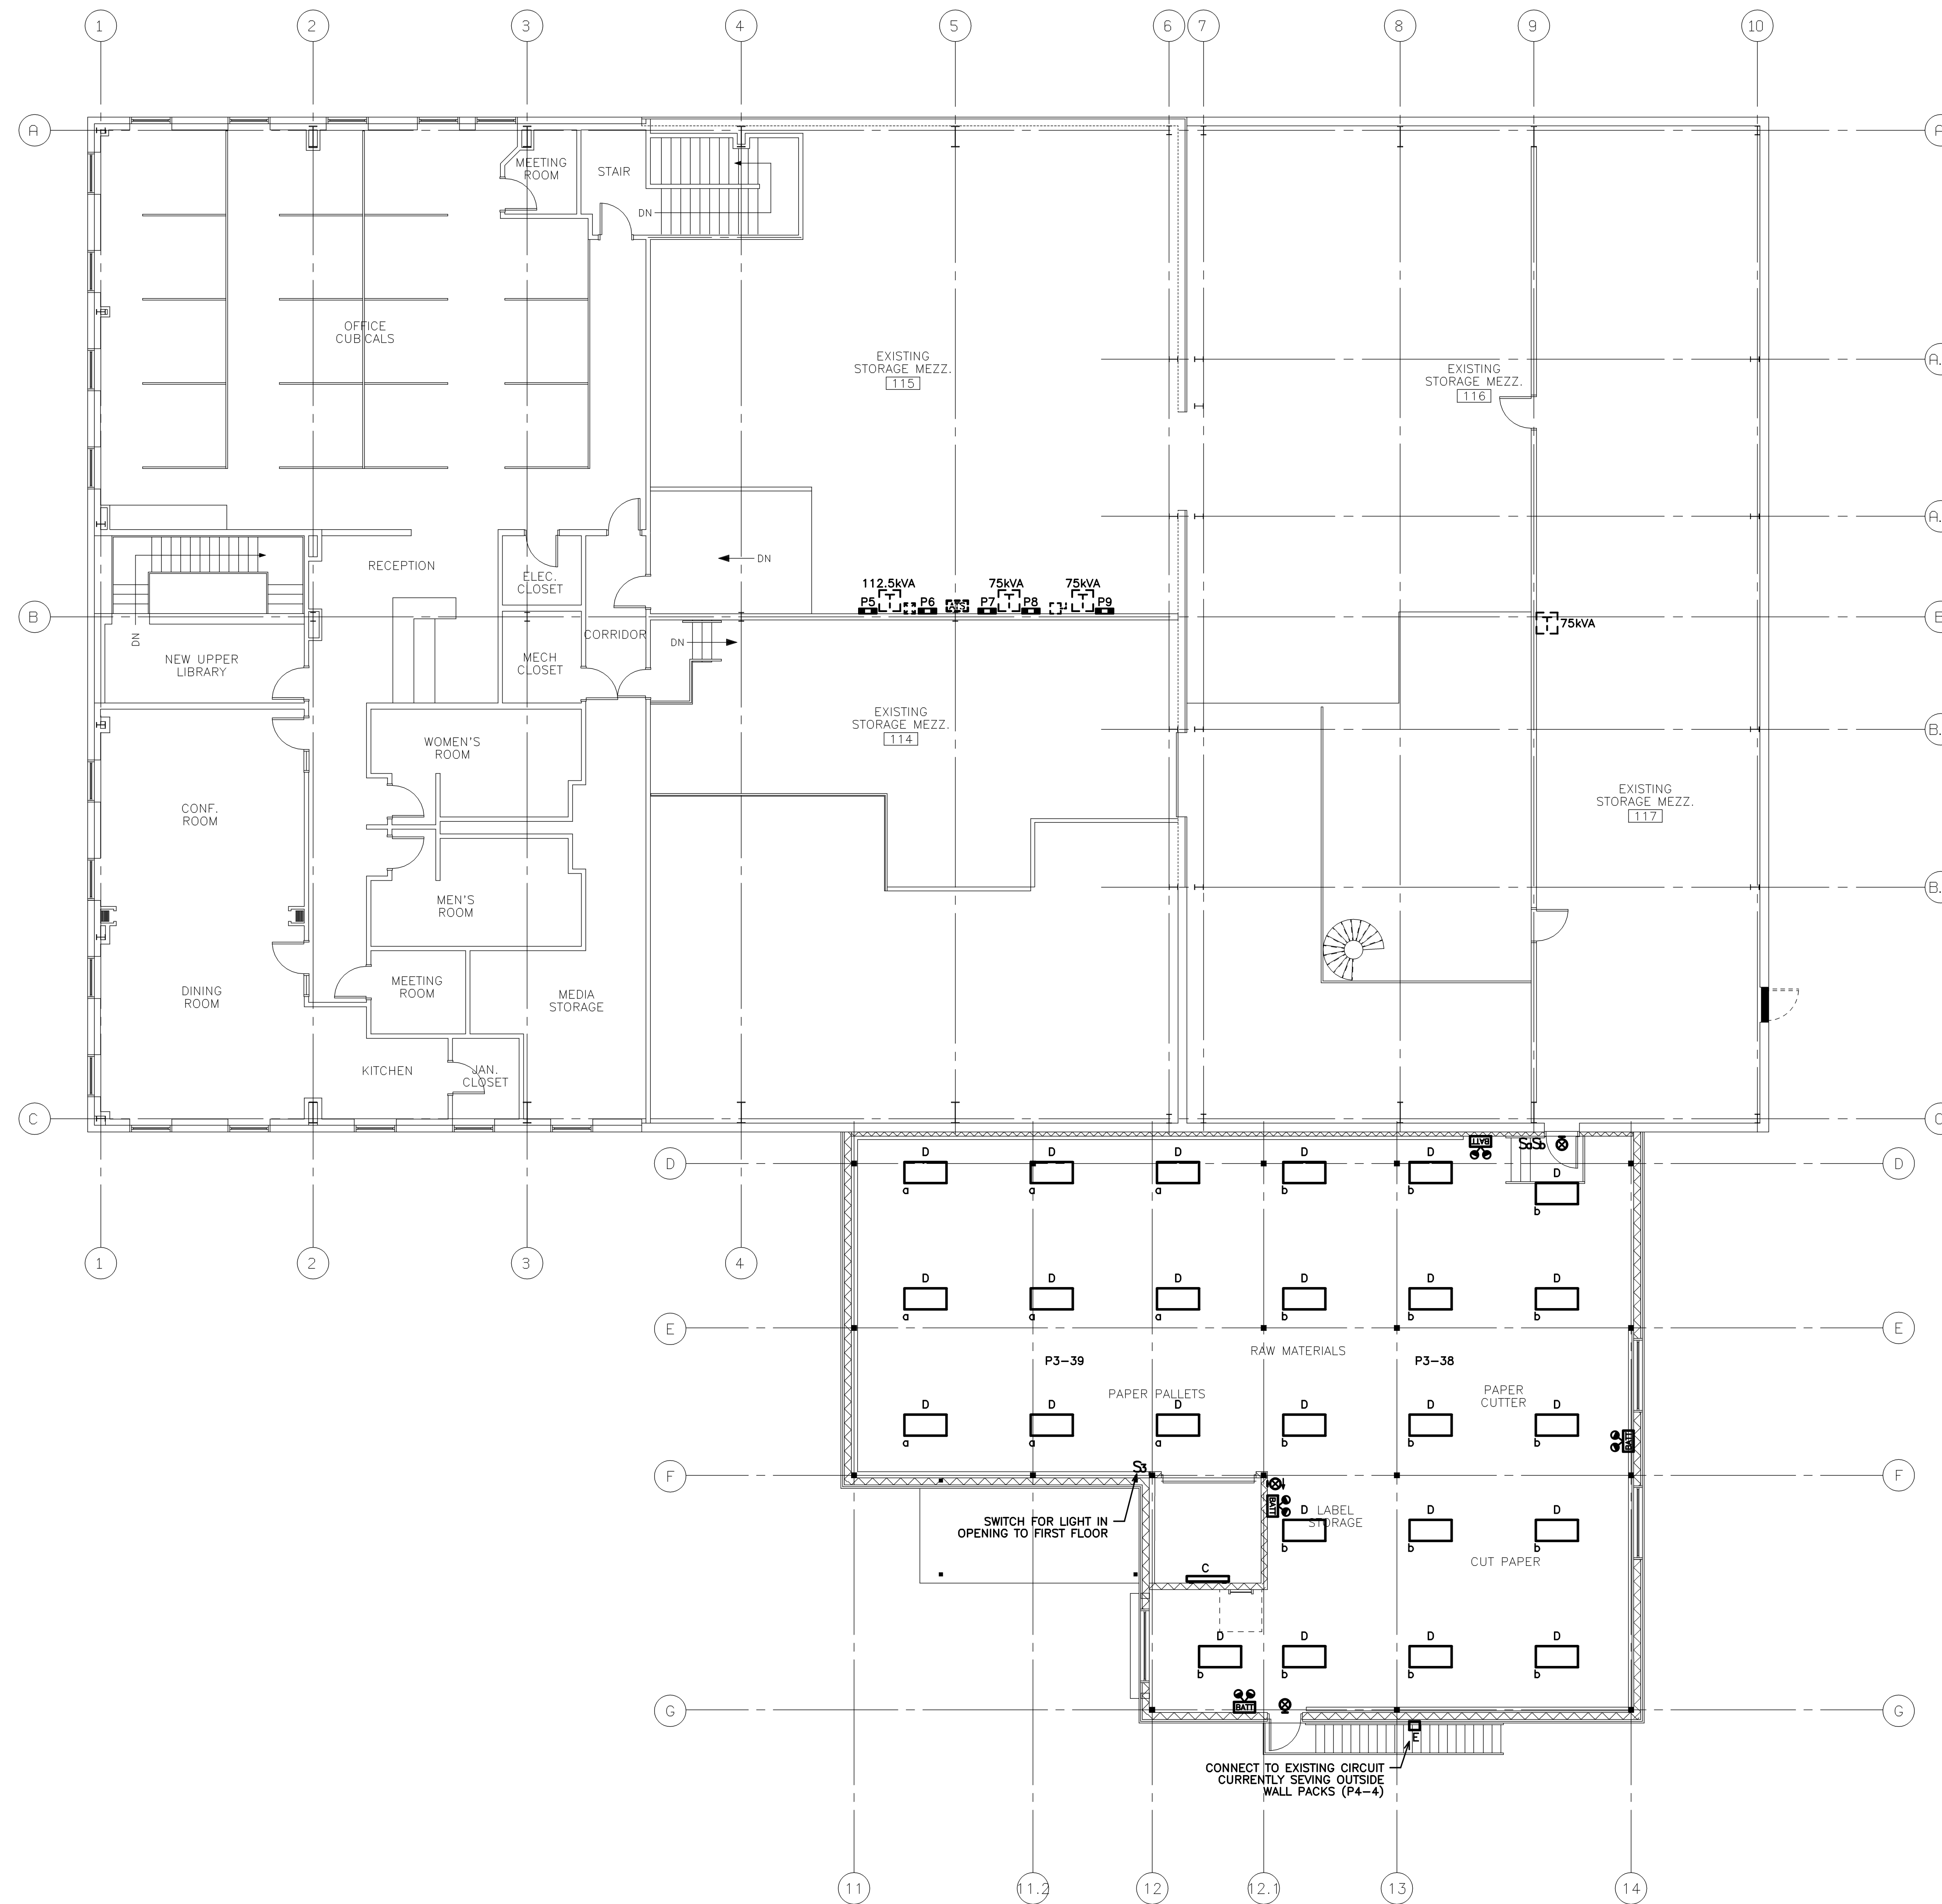

Mark	Date	Description
-	07-01-14	PROGRESS
-	07-25-14	ISSUED FOR CONSTRUCTION

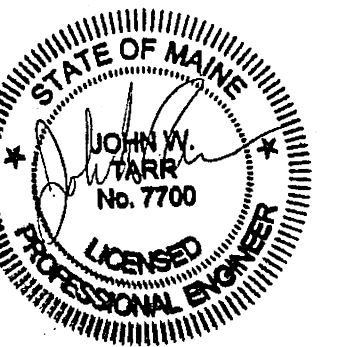

PA / PE: **JWT**
Drawn By: **BSO** © 2014 Harriman Associates

ELECTRICAL SECOND FLOOR LIGHTING PLAN

E10.2