

HARRIMAN


AUBURN PORTLAND MANCHESTER

IMMUCELL CORPORATION ADDITION

PORTLAND, MAINE


Harriman Project No. 14326

Key Plan Proj North

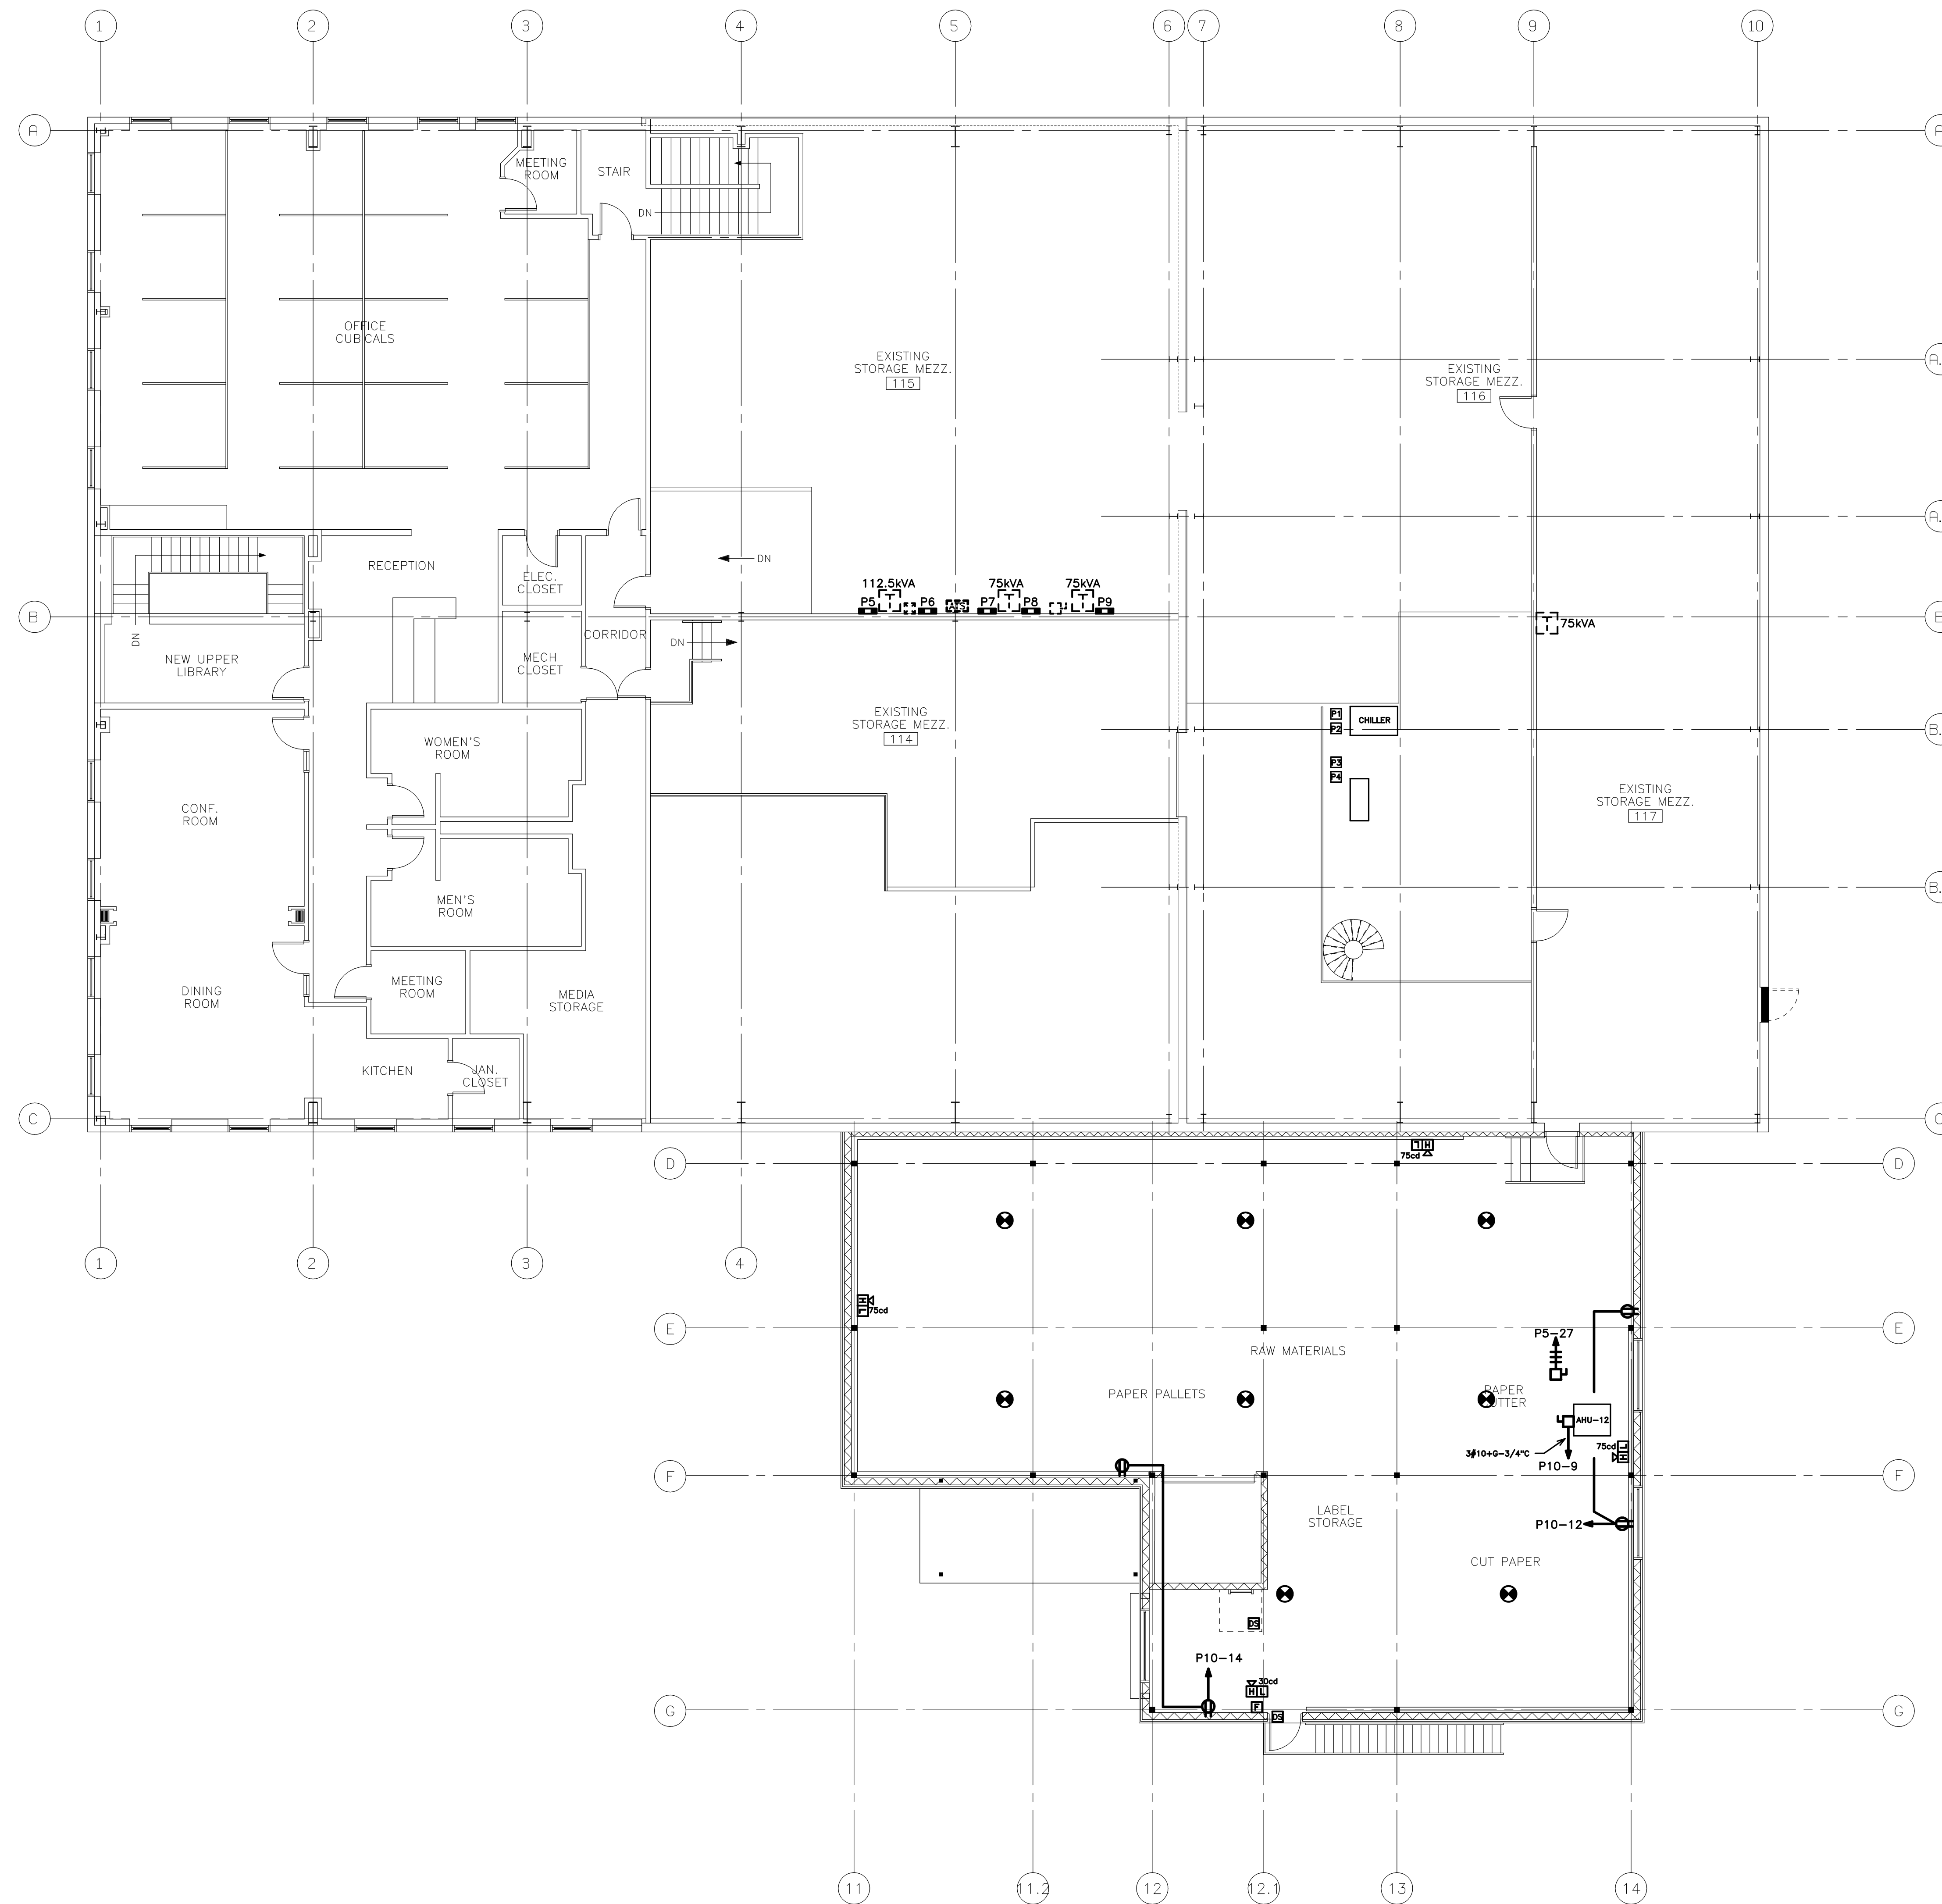

NOTES:
ALL NEW FIRE ALARM DEVICES SHALL BE TIED INTO EXISTING HONEYWELL FIRE ALARM SYSTEM.

Issue or Revisions		
Mark	Date	Description
-	07-01-14	PROGRESS
-	07-25-14	ISSUED FOR CONSTRUCTION

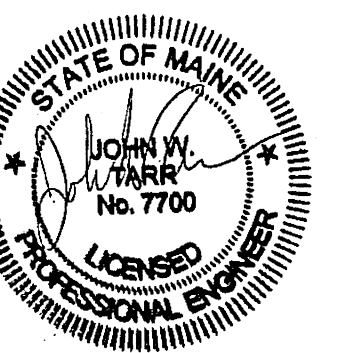

PA / PE: **JWT**
Drawn By: **BSO** © 2014 Harriman Associates

ELECTRICAL SECOND FLOOR POWER PLAN

E20.2