

PROJECT INFORMATION

SCOPE OF WORK: UNMANNED TELECOMMUNICATIONS FACILITY MODIFICATIONS
 SITE ADDRESS: 220 RIVERSIDE INDUSTRIAL PARKWAY
 PORTLAND, ME 04103
 LATITUDE: 43.70606
 LONGITUDE: -70.31068
 JURISDICTION: NATIONAL, STATE & LOCAL CODES OR ORDINANCES
 CURRENT USE: TELECOMMUNICATIONS FACILITY
 PROPOSED USE: TELECOMMUNICATIONS FACILITY
 DESIGN GUIDELINE: 2C

SITE NAME: ME267/DORLER TOWER (ATS)


220 RIVERSIDE INDUSTRIAL PARKWAY
 PORTLAND, ME 04103
 CUMBERLAND COUNTY
 SITE NUMBER: 4DN2267B

DRAWING INDEX

REV

G-1 TITLE SHEET	2
G-2 GENERAL NOTES	2
C-1 COMPOUND & EQUIPMENT PLAN	2
C-2 ELEVATION & ANTENNA PLAN	2
C-3 DETAILS	2
E-1 GROUNDING, ONE-LINE DIAGRAM & DETAILS	2

LOCUS MAP

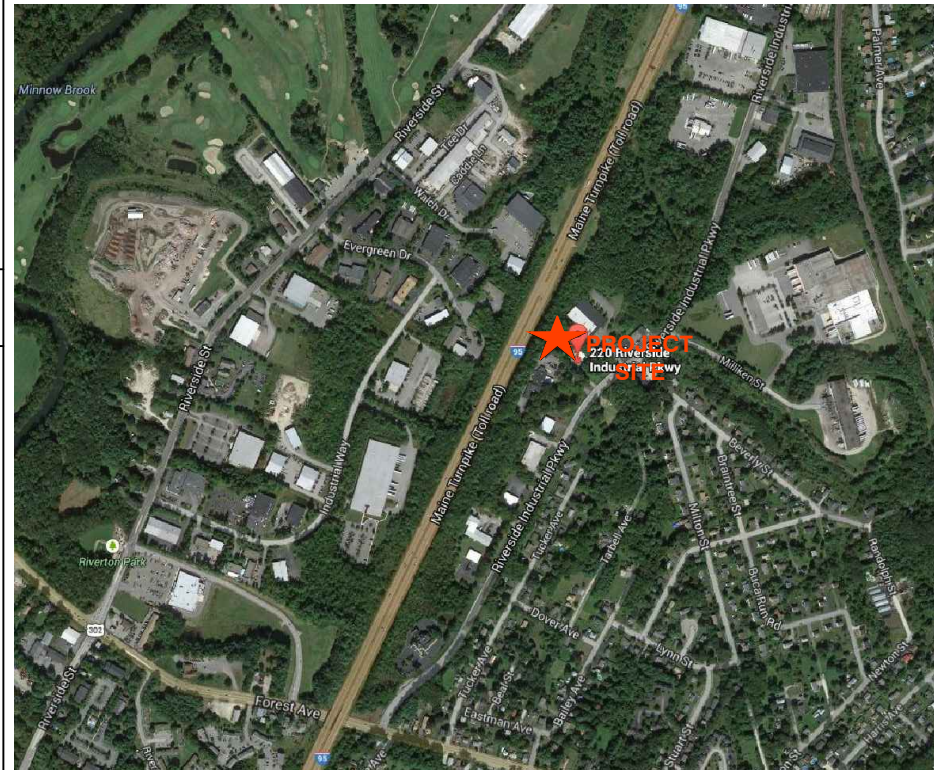


GENERAL NOTES

- THIS DOCUMENT IS THE CREATION, DESIGN, PROPERTY AND COPYRIGHTED WORK OF T-MOBILE NORTHEAST, LLC. ANY DUPLICATION OR USE WITHOUT EXPRESS WRITTEN CONSENT IS STRICTLY PROHIBITED. DUPLICATION AND USE BY GOVERNMENT AGENCIES FOR THE PURPOSES OF CONDUCTING THEIR LAWFULLY AUTHORIZED REGULATORY AND ADMINISTRATIVE FUNCTIONS IS SPECIFICALLY ALLOWED.
- THE FACILITY IS AN UNMANNED PRIVATE AND SECURED EQUIPMENT INSTALLATION. IT IS ONLY ACCESSED BY TRAINED TECHNICIANS FOR PERIODIC ROUTINE MAINTENANCE AND THEREFORE DOES NOT REQUIRE ANY WATER OR SANITARY SEWER SERVICE. THE FACILITY IS NOT GOVERNED BY REGULATIONS REQUIRING PUBLIC ACCESS PER ADA REQUIREMENTS.
- CONTRACTOR SHALL VERIFY ALL PLANS AND EXISTING DIMENSIONS AND CONDITIONS ON THE JOB SITE AND SHALL IMMEDIATELY NOTIFY THE T-MOBILE REPRESENTATIVE IN WRITING OF DISCREPANCIES BEFORE PROCEEDING WITH THE WORK OR BE RESPONSIBLE FOR SAME.

SIGNATURES

CONSTRUCTION	DATE	OPERATIONS	DATE
RF ENGINEERING	DATE	LAND OWNER	DATE
ZONING / SITE ACQ.	DATE		

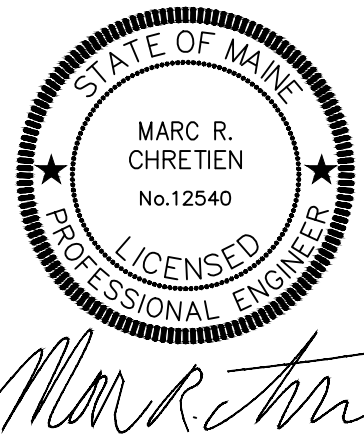

CALL

BEFORE YOU DIG



CALL TOLL FREE 811 OR 888-DIG-SAFE

UNDERGROUND SERVICE ALERT



SITE NUMBER: 4DN2267B
SITE NAME: ME267/DORLER TOWER (ATS)
 220 RIVERSIDE INDUSTRIAL PARKWAY
 PORTLAND, ME 04103

T-MOBILE NORTHEAST LLC
 15 COMMERCE WAY, SUITE B
 NORTON, MA 02766
 OFFICE: (508) 286-2700
 FAX: (508) 286-2893

							T-MOBILE	
2	05/15/14	REVISIONS	JTG	SNA	SNA	TITLE SHEET		
1	04/10/14	REVISIONS	JTG	SNA	SNA			
0	03/26/14	ISSUED FOR REVIEW	JTG	SNA	SNA			
NO.	DATE	REVISIONS	BY	CHK	APP'D	JOB NUMBER	DRAWING NUMBER	REV
		SCALE: AS SHOWN	DESIGNED BY: SNA	DRAWN BY: JTG		4DN2267B	G-1	2