



AIR HANDLING UNIT SCHEDULE													
TAG	AREA SERVED	COOLING TONS	HEATING MBH IN	MANUFACTURER	MODEL NUMBER	ELECTRIC VOLTS/PHASE	MCA AMPS	MAX FUSE	WEIGHT	STAGES	CFM	MIN O.A. CFM	REMARKS
AHU-1	LEFT SIDE OFFICES	5.0	120	YORK	GY9S120D20DH11	120 / 1	17.3	20.0	250 LBS	1H 1C	2,075	205	
AHU-2	RIGHT SIDE OFFICES	4.0	80	YORK	GY9S080C16DH11	120 / 1	17.3	20.0	250 LBS	1H 1C	1,600	160	

REMARKS:

CONDENSING UNIT SCHEDULE											
TAG	AREA SERVED	COOLING TONS	HEATING MBH IN	MANUFACTURER	MODEL NUMBER	ELECTRIC VOLTS/PHASE	MCA AMPS	MAX FUSE	WEIGHT	STAGES	REMARKS
CU-1	AHU-1	5.0	----	YORK	H1RA060S25	230 / 3	21.3	35.0	228 LBS	1C	
CU-2	AHU-2	4.0	----	YORK	H1RA048S25	230 / 3	17.3	30.0	206 LBS	1C	

REMARKS:

AIR DEVICE SCHEDULE					
TAG	SIZE	MAX CFM	MAX NC	THROW @500 FPM	REMARKS
CD-1	6"	98-157	<15-15	1-2-4	
CD-2	8"	175-279	<15-19	2-3-6	
CD-3	10"	273-436	<15-21	3-4-8	
RG	12" X 12"	----	----	----	
TG-1	12" X 12"	----	----	----	
EG-1	10" X 10"	----	----	----	


 
UNIT HEATER SCHEDULE										
TAG	AREA SERVED	COOLING TONS	HEATING MBH IN	MANUFACTURER	MODEL NUMBER	ELECTRIC VOLTS/PHASE	MCA AMPS	WEIGHT	STAGES	REMARKS
UH-1	WAREHOUSE	----	200	DAYTON	4LX60	115 / 1	<15	165 LBS	1H	

REMARKS:

EXHAUST FAN SCHEDULE								
TAG	AREA SERVED	CFM	MANUFACTURER	MODEL NUMBER	ELECTRIC VOLTS/PHASE	AMPS	WEIGHT	REMARKS
EF-1	TOILET	350	FANTECH	FP-225	115 / 1	1.5	10 LBS	4" PCB E FDD

SYMBOL LEGEND

-  4-WAY SUPPLY DIFFUSER
-  RETURN REGISTER
-  CEILING EXHAUST FAN
-  ROOF MOUNTED EXHAUST FAN
-  ELBOW WITH TURNING VANES
-  SQUARE TO ROUND TRANSITION
-  STANDARD SIZE REDUCTION
-  SPIN-IN TAKE-OFF WITH DAMPER
-  FLEX DUCT

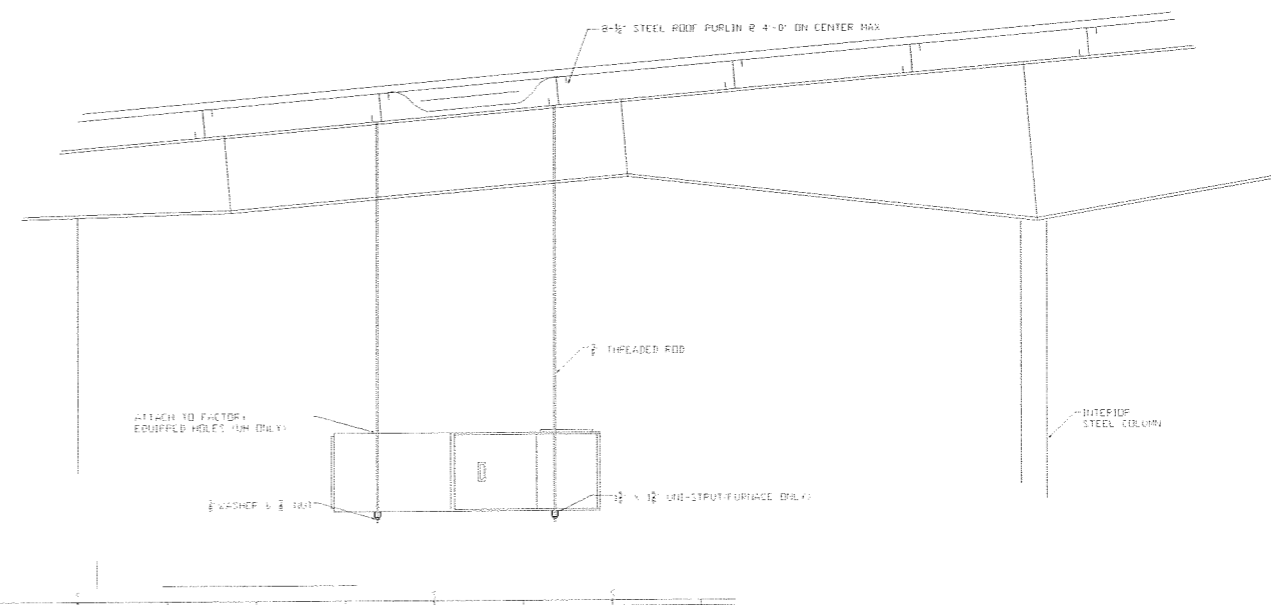

1 FURNACE & UNIT HEATER HANGING DETAIL  
SCALE: N.T.S

01	ISSUED FOR THE OWNER TO PERMIT
02	

AIRTEMP MECHANICAL CONTRACTORS  
11 WALLACE AVE.  
SOUTH PORTLAND, MAINE

Michael R. Charek  
Architect  
25 Hartley Street  
Portland, Maine 04103  
(207) 761-0556



IMAGISTICS  
1039 RIVERSIDE ST. BLDG#3  
PORTLAND, MAINE

CLIENT  
DATE  
DRWN BY  
CHKD BY  
DATE NOV. 02, 2006

SHEET TITLE  
MECHANICAL SCHEDULES

SCALE  
N.T.S

DRAWING  
M-2