

AIR HANDLING UNIT SCHEDULE											
TAG	AREA SERVED	COOLING TONS	HEATING MBH IN	MANUFACTURER	MODEL NUMBER	ELECTRIC VOLTS/PHASE	MCA AMPS	MAX FUSE	WEIGHT	STAGES	REMARKS
AHU-1	OPEN OFFICE	4	100	LENNOX/AIPE-FLO	AF90MPE100U4	115 / 1	10.6	15	158 LBS	1H / 1C	1
AHU-2	OFFICES	2	50	LENNOX/AIPE-FLO	AF90MPE050U3	115 / 1	9.2	15	152 LBS	1H / 1C	1
CU-1	AHU-1	4	----	LENNOX/AIPE-FLO	AFAIR10B48	208 / 1	26.9	45	----	----	
CU-2	AHU-2	2	----	LENNOX/AIPE-FLO	AFAIR10B24	208 / 1	14.4	25	----	----	



REMARKS: 1. LP KIT

EXHAUST FAN SCHEDULE								
TAG	AREA SERVED	CFM	MANUFACTURER	MODEL NUMBER	ELECTRIC VOLTS/PHASE	AMPS	WEIGHT	REMARKS
EF-1	TOILET	75	COOK	GC-120	115 / 1	<15	13 LBS	CEILING MOUNTED
EF-2	TOILET	75	COOK	GC-120	115 / 1	<15	13 LBS	CEILING MOUNTED

AIR DEVICE SCHEDULE					
TAG	SIZE	MAX CFM	MAX NC	THROW @500 FPM	REMARKS
CD-1	6"	98-157	<15-15	1-2-4	SQUARE CONE DIFFUSER T-BAR LAY-IN
CD-2	8"	175-279	<15-19	2-3-6	SQUARE CONE DIFFUSER T-BAR LAY-IN
CD-3	10"	273-436	<15-21	3-4-8	SQUARE CONE DIFFUSER T-BAR LAY-IN
RG	24" X 24"	----	----	----	EGGCRATE RETURN GRILLE T-BAR LAY-IN

UNIT HEATER SCHEDULE										
TAG	AREA SERVED	COOLING TONS	HEATING MBH IN	MANUFACTURER	MODEL NUMBER	ELECTRIC VOLTS/PHASE	MCA AMPS	WEIGHT	STAGES	REMARKS
UH-1	WAREHOUSE	----	200	LENNOX	LF-24-200	115 / 1	<15	175 LBS	1H	1
UH-2	WAREHOUSE	----	200	LENNOX	LF-24-200	115 / 1	<15	175 LBS	1H	1


REMARKS: 1. LP KIT

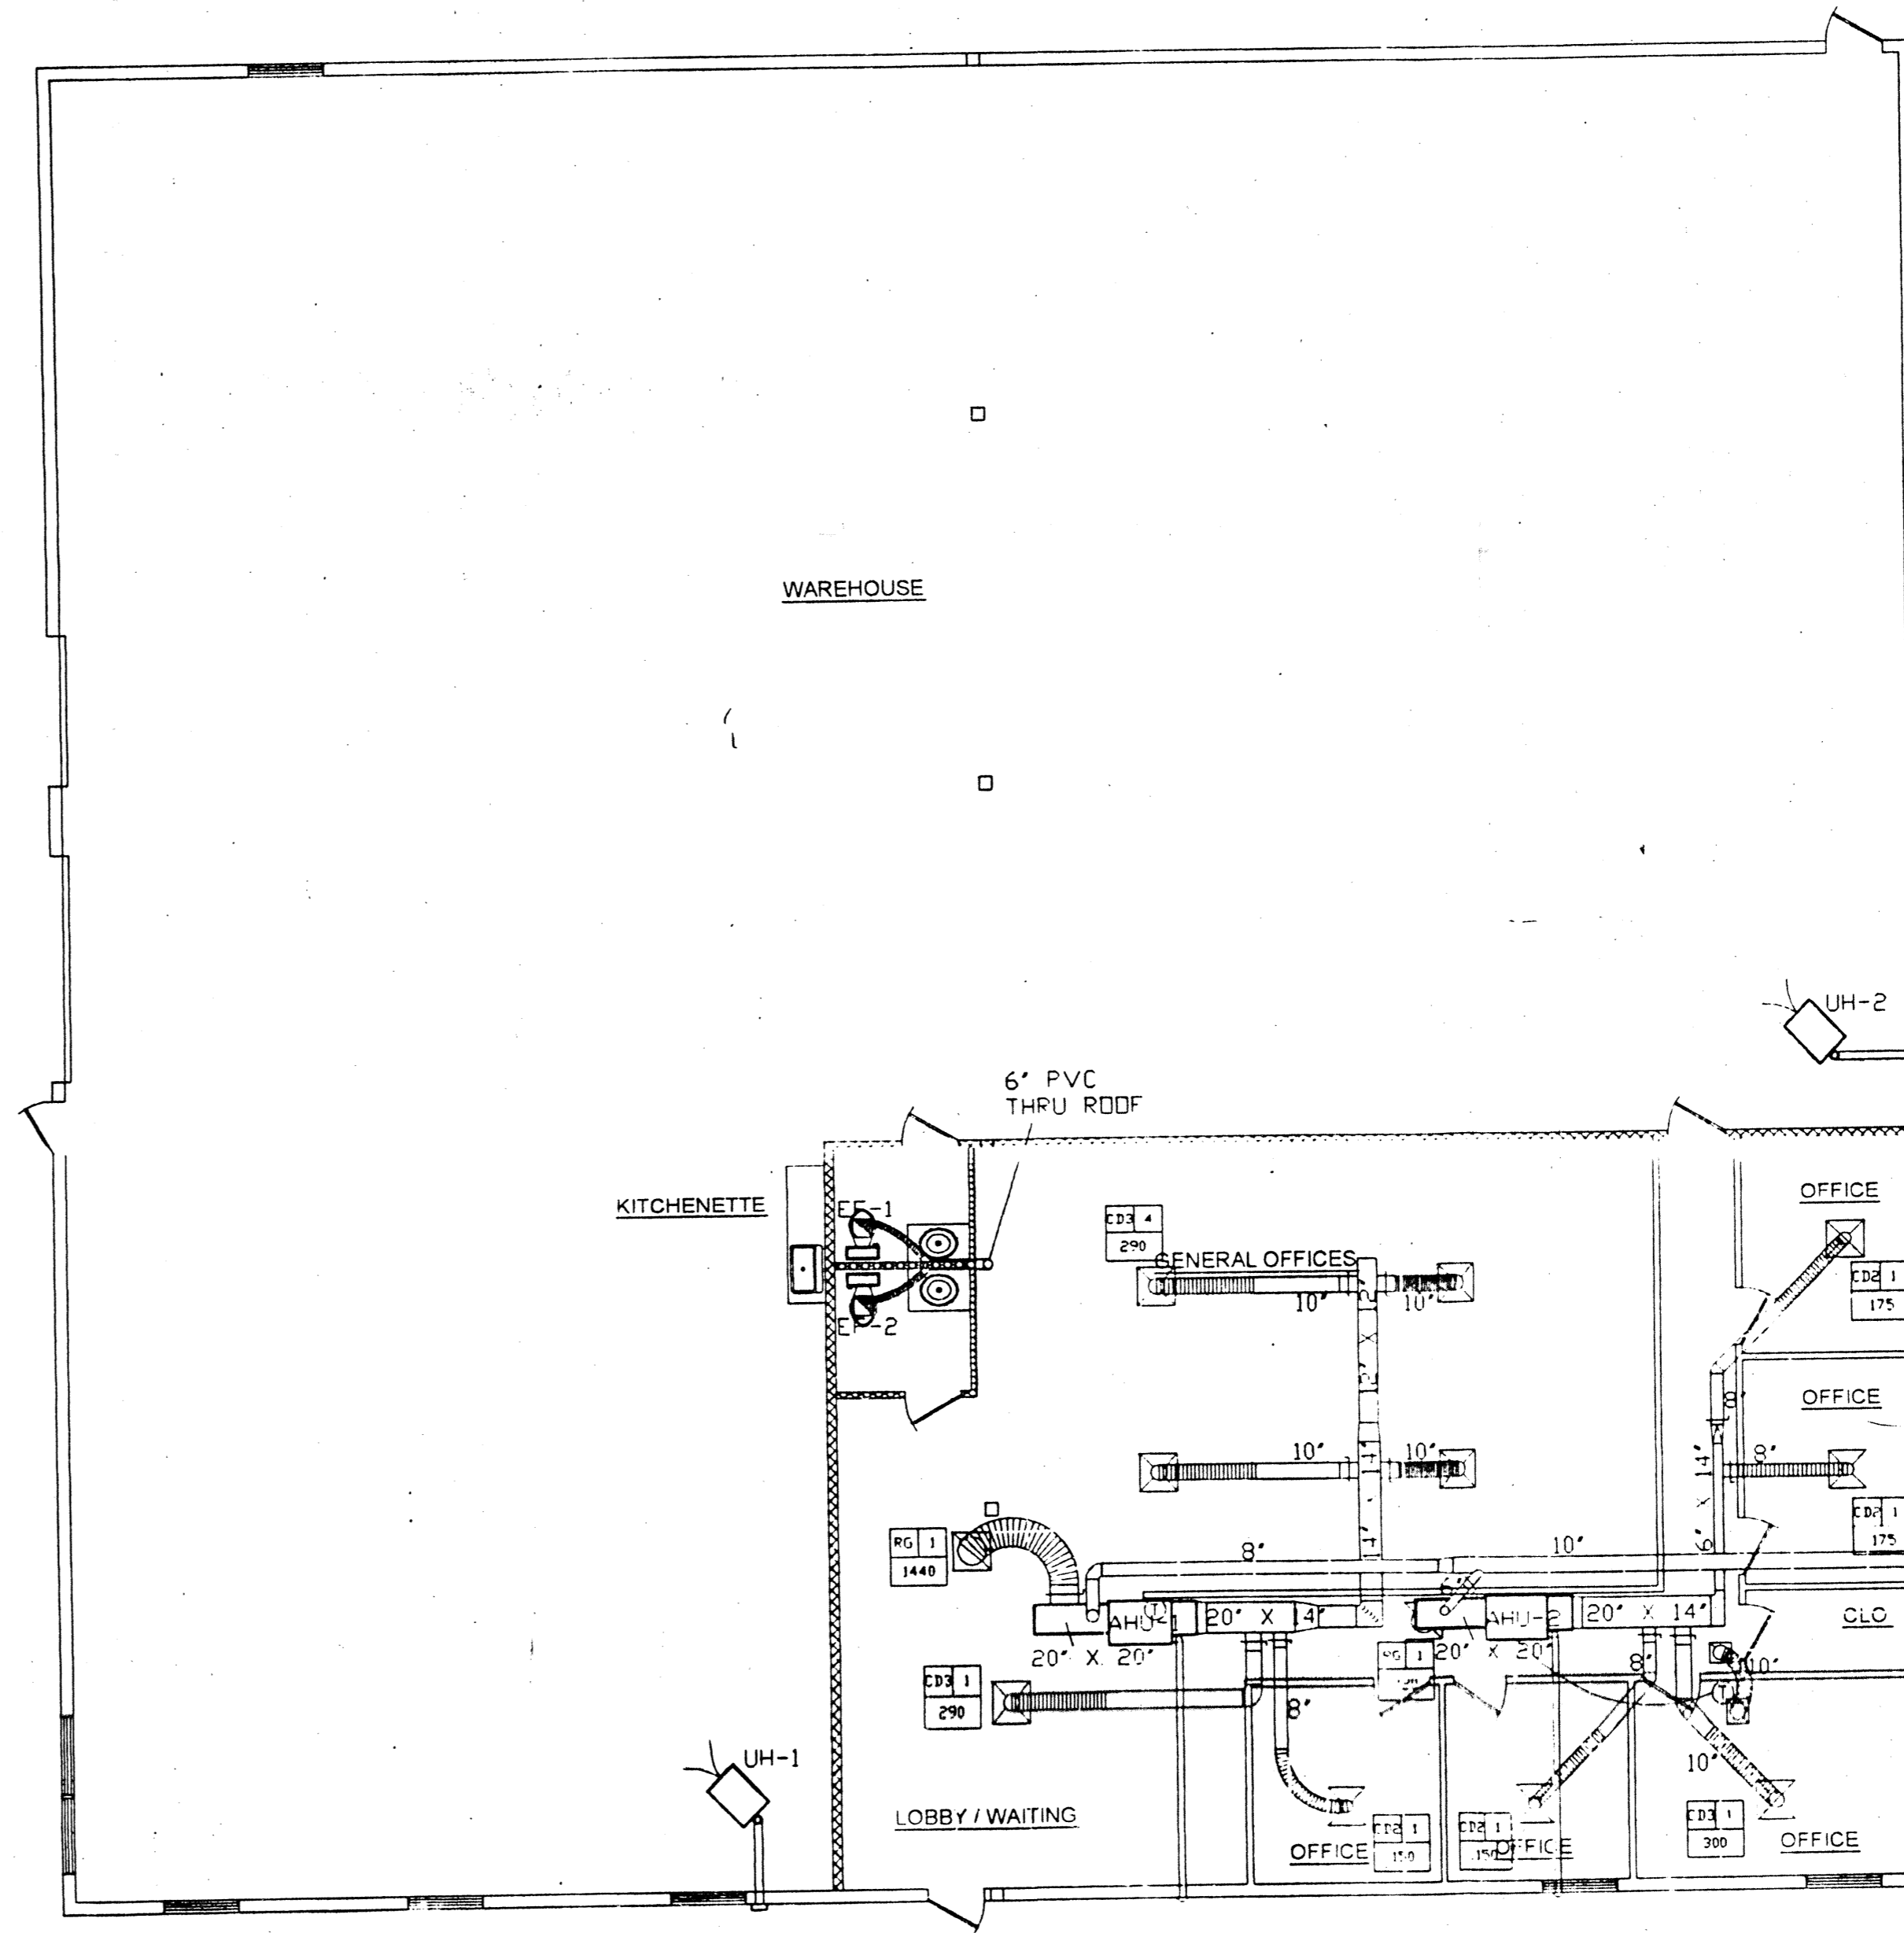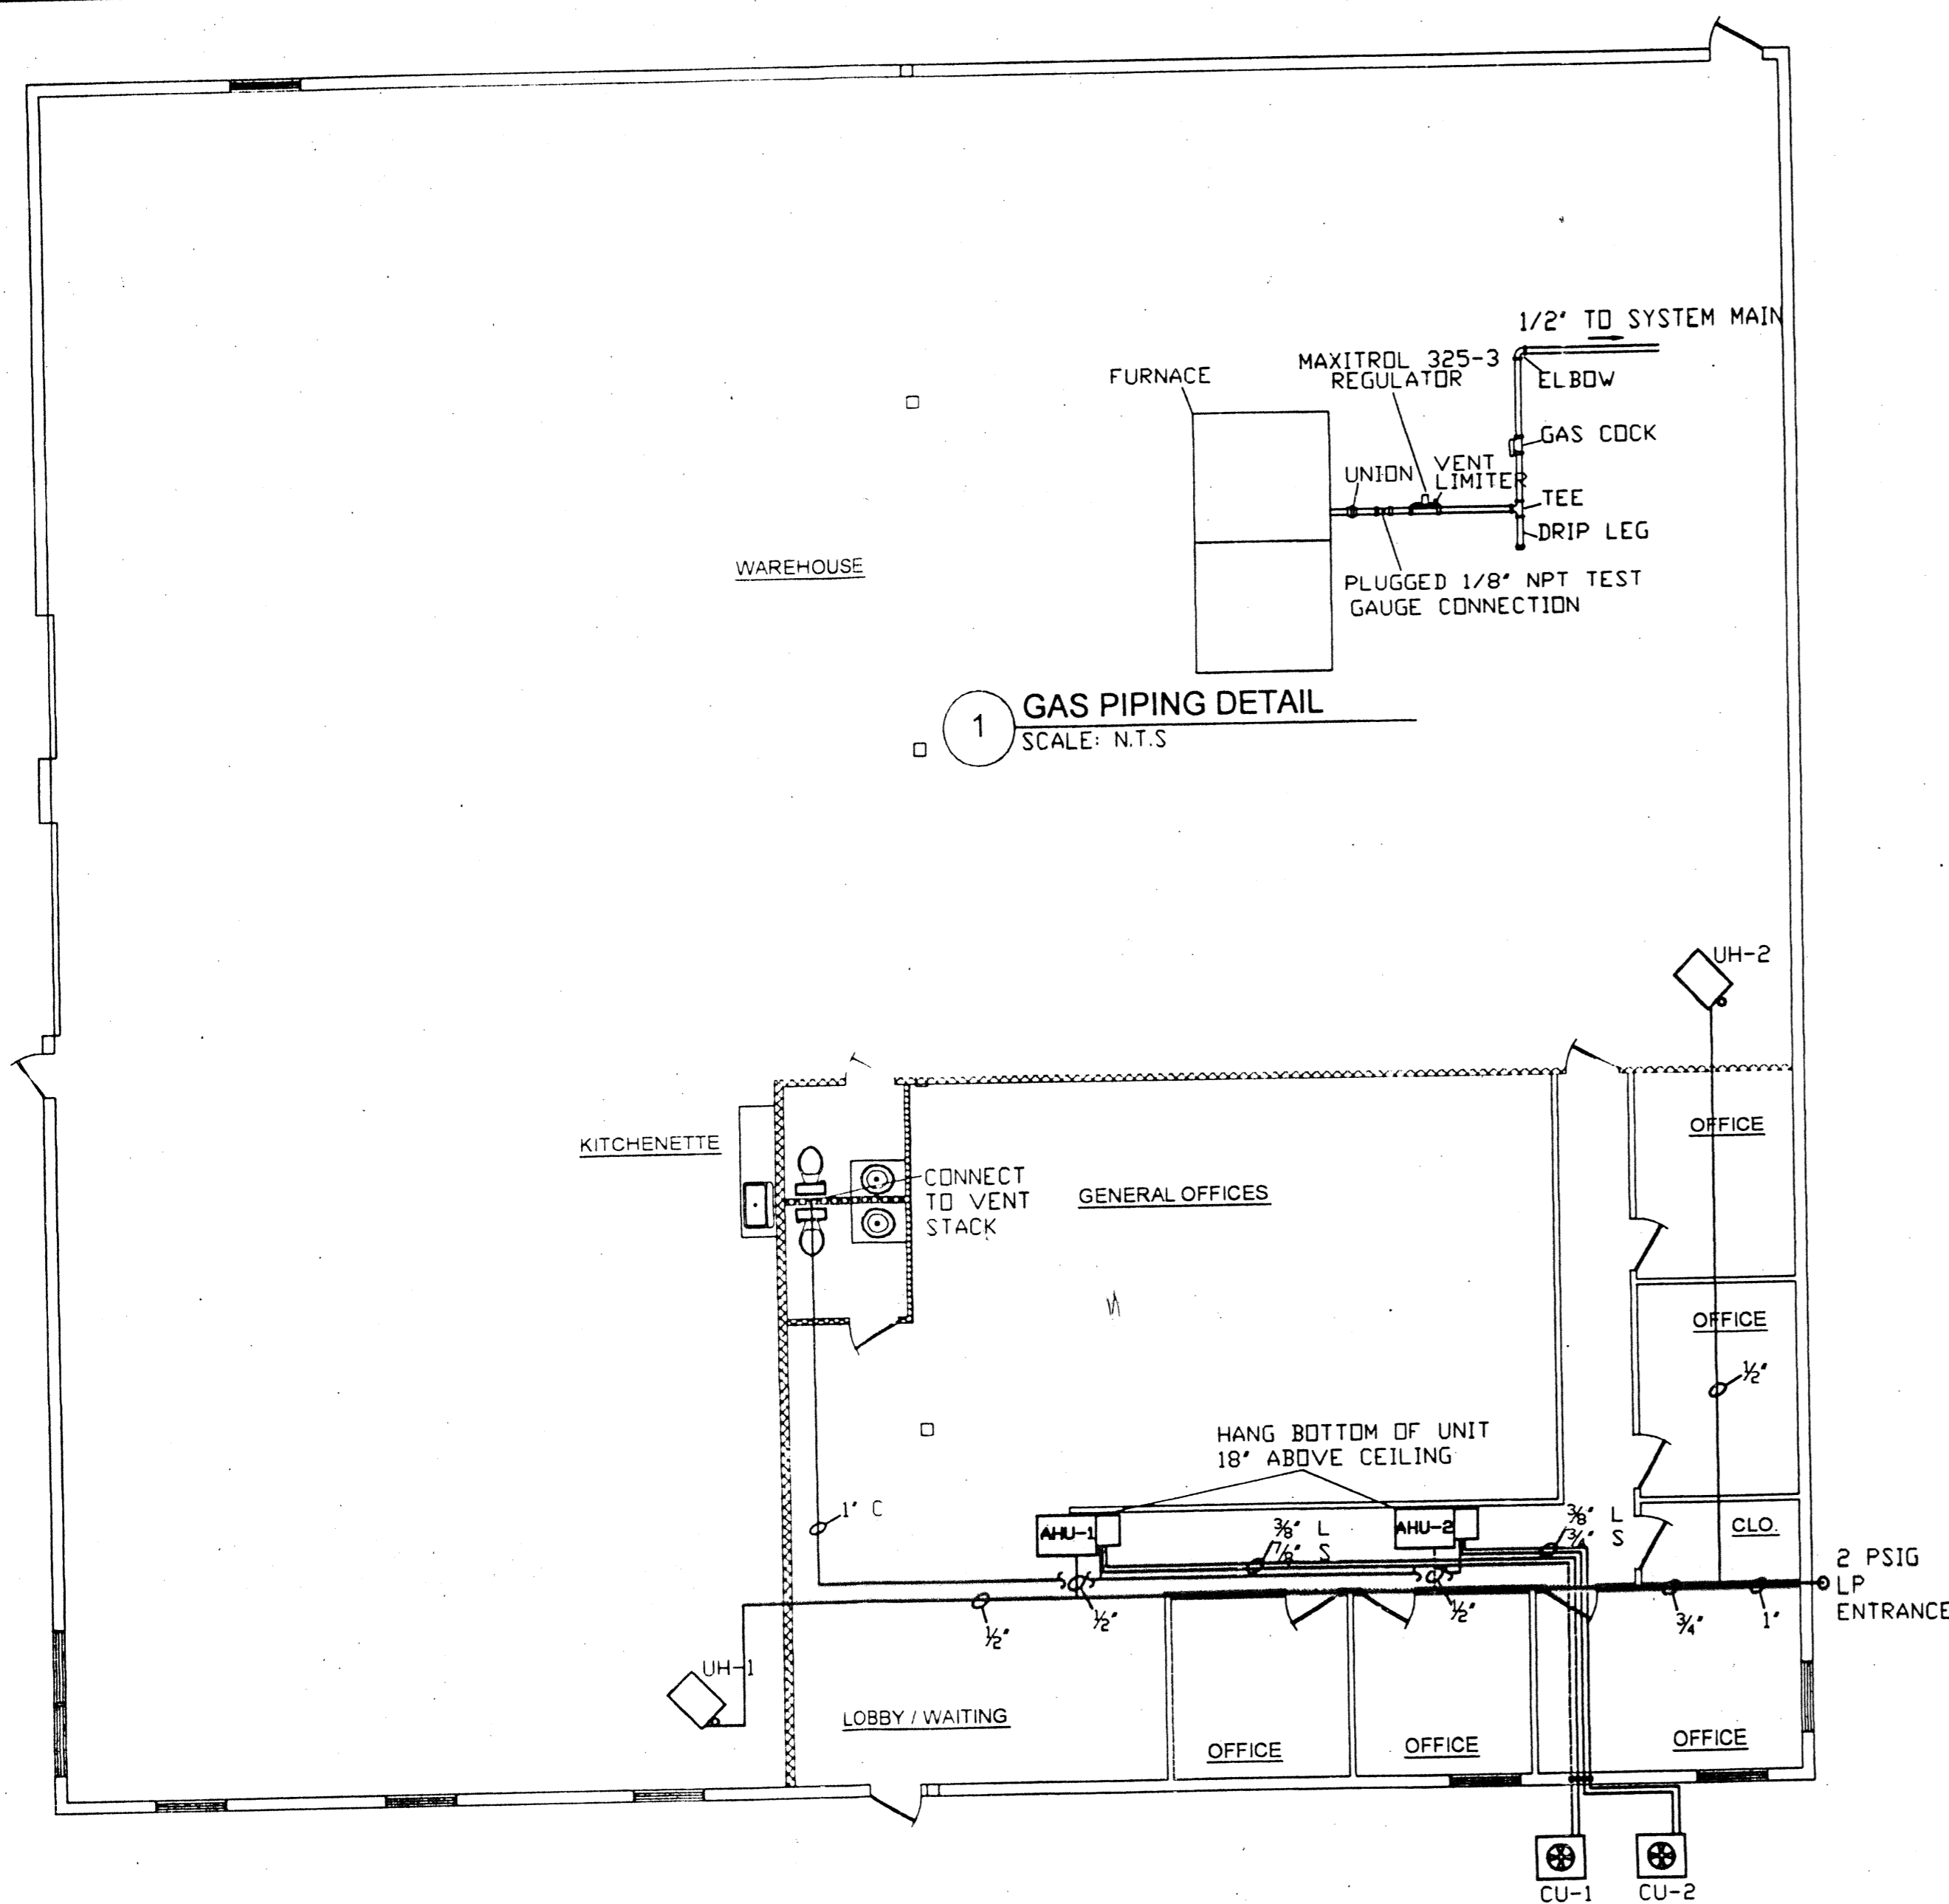

job # 451

01	ISSUED FOR PERMITTING	APR 12, 2005
02		
03		
04		
05		

AIRTEMP MECHANICAL CONTRACTORS
 11 WALLACE AVENUE
 SOUTH PORTLAND, MAINE 04106

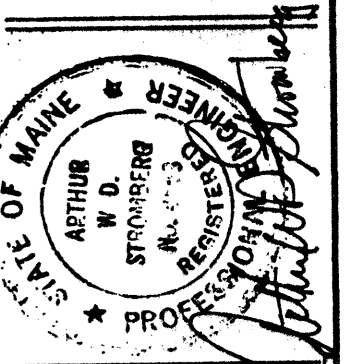

DIRECTECH
 83 WALCH DRIVE
 PORTLAND, MAINE

CLIENT: _____
 DATE: _____
 DRAWN BY: DRL
 CHECKED BY: _____
 DATE: APR 7, 2005
 SHEET TITLE: MECHANICAL FLOOR PLAN

SCALE: 1/8" = 1'
 M-1