

REVISION	DESCRIPTION	DATE
0	ISSUED FOR REVIEW & APPROVAL	3/10/2017


RESERVED FOR CITY STAMP

CUNNINGHAM
 Security Systems
 10 Princes Point Road, Yarmouth, Maine 04096
 Office: 207.846.3350 • Fax: 207.846.6080

PURESTAT EXTRUSIONS, LLC
 75 WALCH DRIVE
 PORTLAND, MAINE 04103
FIRE ALARM PLAN

DRAWN	JPB UNICAD JOB #17126
CHECKED	WAYNE B. HAWES NCET # 90496
DATE	3/10/2017
REVISION	0
SCALE	AS NOTED

FA-2

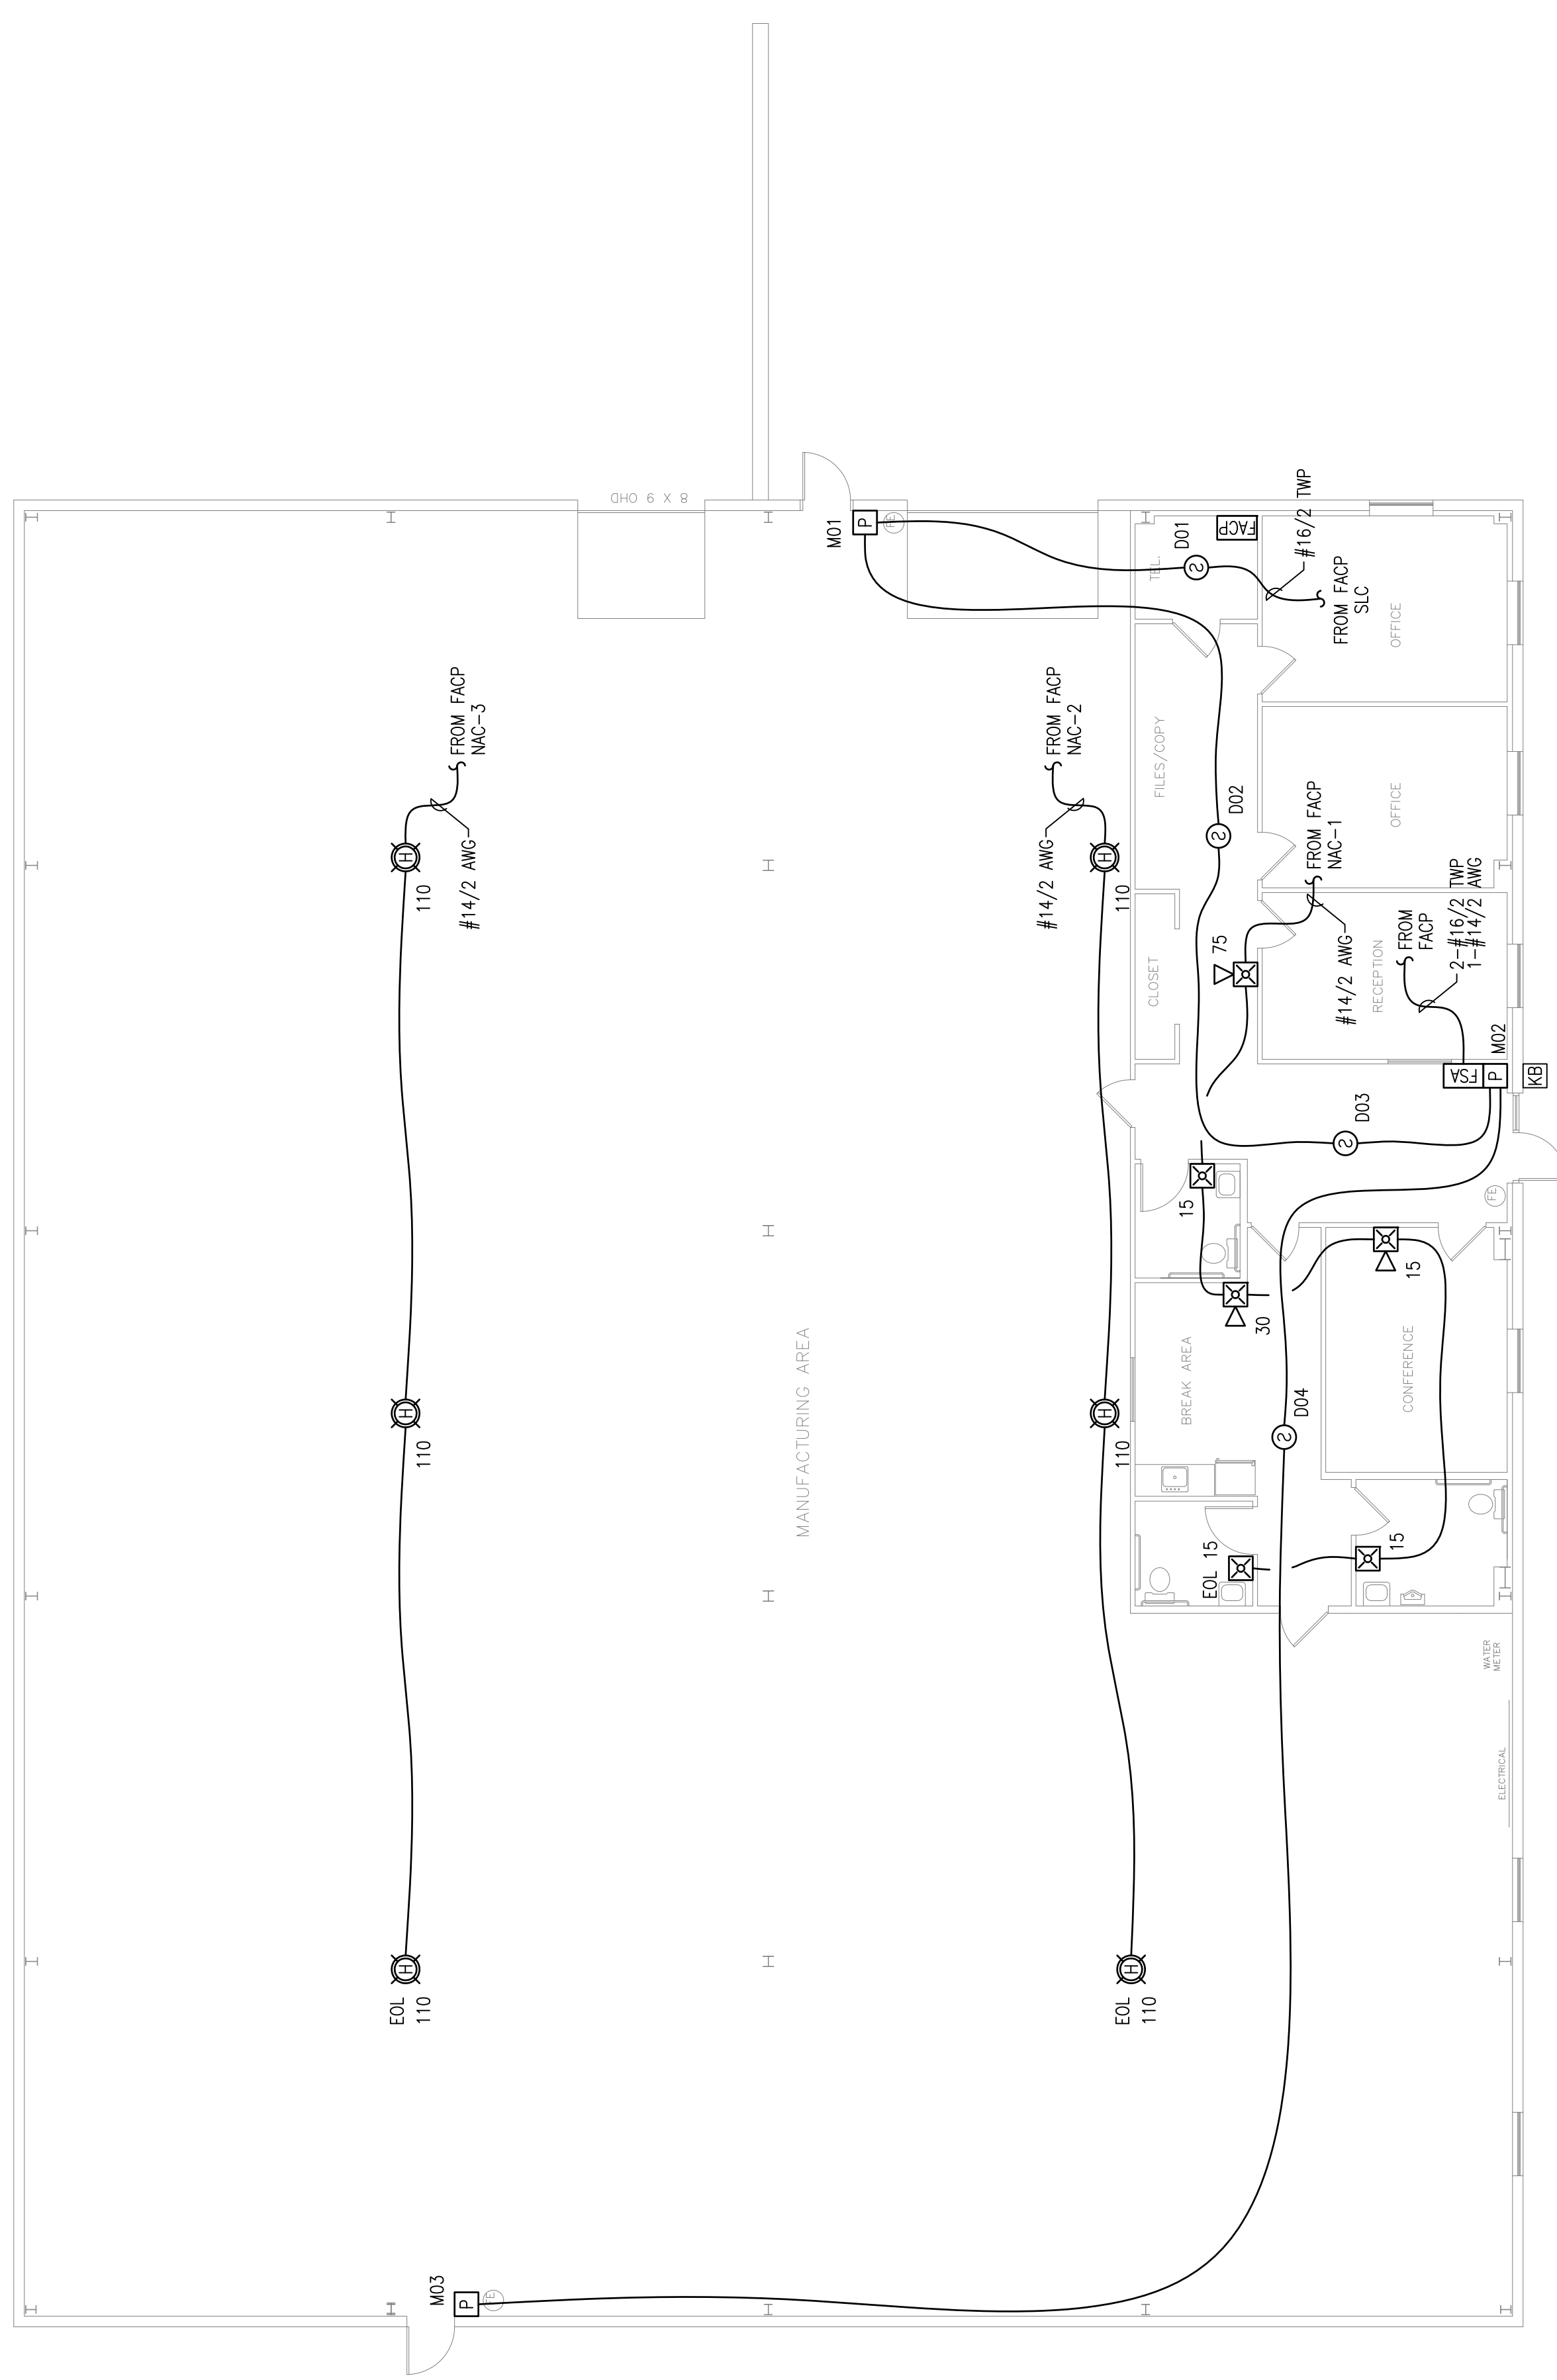

FIRE ALARM PLAN
 SCALE: 1/8"=1'-0"

UNICAD Inc.
 575 W. 400th St.
 Portland, ME 04106
 www.unicad.net
 Fire Alarm Design & Drafting Services