


ImmuCell

**Lot 11 - Second Tee Business Park
1039 Riverside Street
Portland, Maine 04103**

Stantec Project #: 191504176

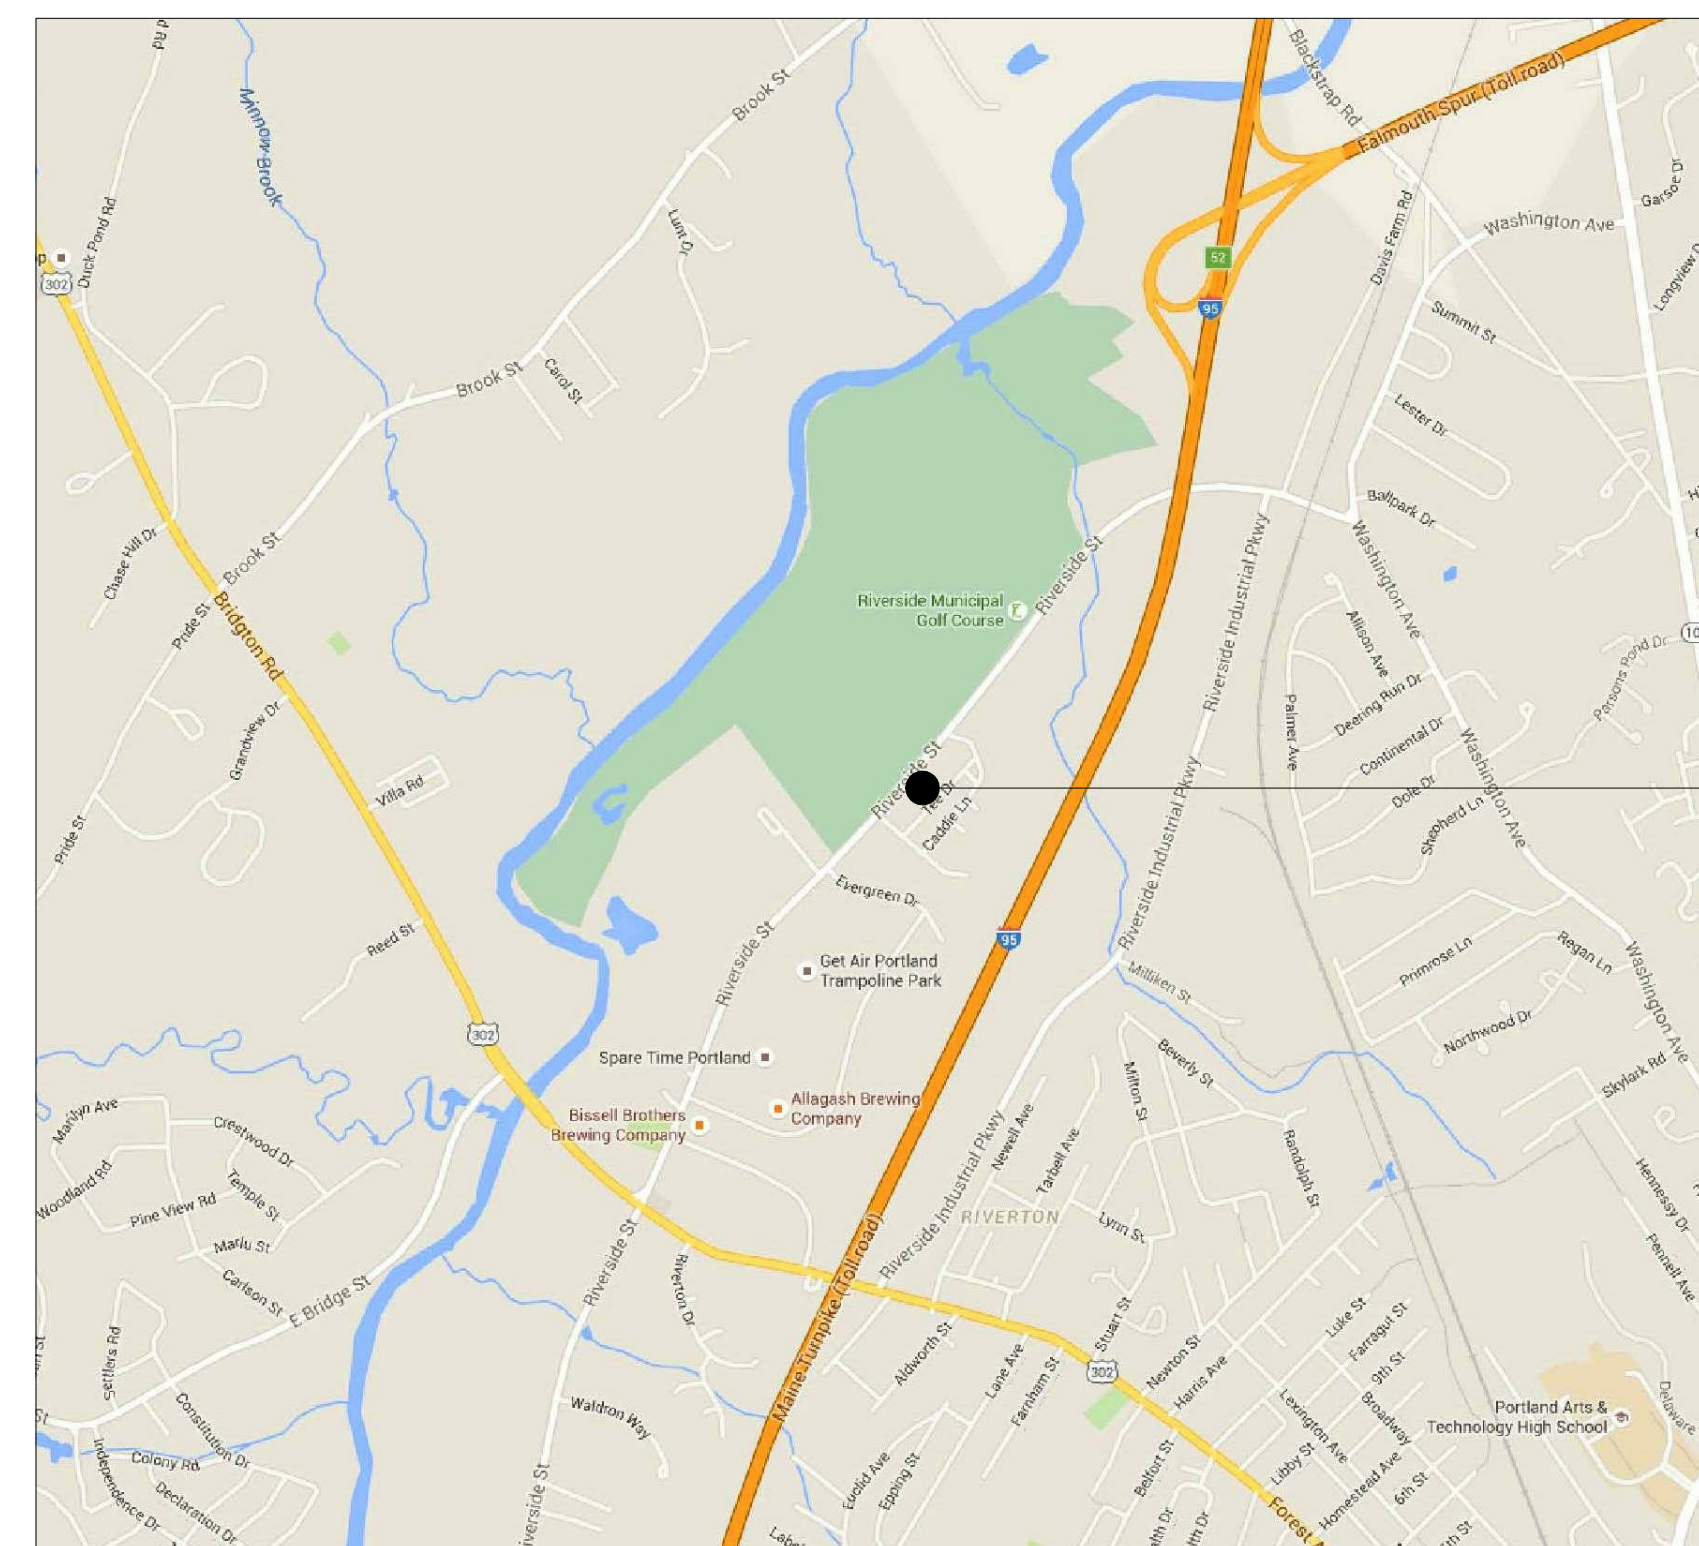

Lot 11 - Second Tee Business Park
1039 Riverside Street
Portland, Maine 04103

LOCATION MAP



NORTH

DRAWING INDEX - PACKAGE C				
NO.	DRAWING NAME	REV.	REV. DATE	REV. DESCRIPTION
GENERAL				
G-01-C	CODE SUMMARY	0	08/19/2016	INTERIOR FIT OUT - ISSUED FOR CONSTRUCTION
G-10-C	FIRST FLOOR CODE PLAN	0	08/19/2016	INTERIOR FIT OUT - ISSUED FOR CONSTRUCTION
G-102-C	SECOND FLOOR CODE PLAN	0	08/19/2016	INTERIOR FIT OUT - ISSUED FOR CONSTRUCTION
G-103-C	FIRST FLOOR GENERAL ARRANGEMENT	0	08/19/2016	INTERIOR FIT OUT - ISSUED FOR CONSTRUCTION
G-104-C	SECOND FLOOR GENERAL ARRANGEMENT	0	08/19/2016	INTERIOR FIT OUT - ISSUED FOR CONSTRUCTION
G-105-C	ROOF GENERAL ARRANGEMENT	0	08/19/2016	INTERIOR FIT OUT - ISSUED FOR CONSTRUCTION
G-106-C	FIRST FLOOR PERSONNEL FLOW DIAGRAM	0	08/19/2016	INTERIOR FIT OUT - ISSUED FOR CONSTRUCTION
G-107-C	FIRST FLOOR WASTE FLOW DIAGRAM	0	08/19/2016	INTERIOR FIT OUT - ISSUED FOR CONSTRUCTION
G-108-C	FIRST FLOOR MATERIAL FLOW DIAGRAM	0	08/19/2016	INTERIOR FIT OUT - ISSUED FOR CONSTRUCTION
G-109-C	FIRST FLOOR PRODUCT FLOW DIAGRAM	0	08/19/2016	INTERIOR FIT OUT - ISSUED FOR CONSTRUCTION
G-110-C	SECOND FLOOR PERSONNEL FLOW DIAGRAM	0	08/19/2016	INTERIOR FIT OUT - ISSUED FOR CONSTRUCTION
G-111-C	SECOND FLOOR WASTE FLOW DIAGRAM	0	08/19/2016	INTERIOR FIT OUT - ISSUED FOR CONSTRUCTION
G-112-C	SECOND FLOOR MATERIAL FLOW DIAGRAM	0	08/19/2016	INTERIOR FIT OUT - ISSUED FOR CONSTRUCTION
G-113-C	SECOND FLOOR PRODUCT FLOW DIAGRAM	0	08/19/2016	INTERIOR FIT OUT - ISSUED FOR CONSTRUCTION
STRUCTURE				
S-300-C	STRUCTURAL NOTES AND SPECIFICATIONS	0	08/19/2016	INTERIOR FIT OUT - ISSUED FOR CONSTRUCTION
S-401-C	PLATFORM FRAMING PLANS	0	08/19/2016	INTERIOR FIT OUT - ISSUED FOR CONSTRUCTION
S-402-C	PLATFORM FRAMING PLANS	0	08/19/2016	INTERIOR FIT OUT - ISSUED FOR CONSTRUCTION
S-510-C	PLATFORM DETAILS	0	08/19/2016	INTERIOR FIT OUT - ISSUED FOR CONSTRUCTION
ARCHITECTURE				
A-101-C	ARCHITECTURAL LEAD SHEET	0	08/19/2016	INTERIOR FIT OUT - ISSUED FOR CONSTRUCTION
A-101-C	FIRST FLOOR PLAN	0	08/19/2016	INTERIOR FIT OUT - ISSUED FOR CONSTRUCTION
A-102-C	SECOND FLOOR PLAN	0	08/19/2016	INTERIOR FIT OUT - ISSUED FOR CONSTRUCTION
A-103-C	ROOF PLAN	0	08/19/2016	INTERIOR FIT OUT - ISSUED FOR CONSTRUCTION
A-104-C	FIRST FLOOR REFLECTED CEILING PLAN	0	08/19/2016	INTERIOR FIT OUT - ISSUED FOR CONSTRUCTION
A-105-C	SECOND FLOOR REFLECTED CEILING PLAN	0	08/19/2016	INTERIOR FIT OUT - ISSUED FOR CONSTRUCTION
A-301-C	BUILDING SECTIONS	0	08/19/2016	INTERIOR FIT OUT - ISSUED FOR CONSTRUCTION
A-302-C	SECTIONS AND DETAILS	0	08/19/2016	INTERIOR FIT OUT - ISSUED FOR CONSTRUCTION
A-401-C	ENLARGED PLANS	0	08/19/2016	INTERIOR FIT OUT - ISSUED FOR CONSTRUCTION
A-402-C	ENLARGED PLANS	0	08/19/2016	INTERIOR FIT OUT - ISSUED FOR CONSTRUCTION
A-501-C	WALL TYPES	0	08/19/2016	INTERIOR FIT OUT - ISSUED FOR CONSTRUCTION
A-502-C	DETAILS	0	08/19/2016	INTERIOR FIT OUT - ISSUED FOR CONSTRUCTION
A-503-C	DETAILS	0	08/19/2016	INTERIOR FIT OUT - ISSUED FOR CONSTRUCTION
A-504-C	DETAILS	0	08/19/2016	INTERIOR FIT OUT - ISSUED FOR CONSTRUCTION
A-601-C	DOOR AND WINDOW SCHEDULE	0	08/19/2016	INTERIOR FIT OUT - ISSUED FOR CONSTRUCTION
A-602-C	DOOR AND WINDOW DETAILS	0	08/19/2016	INTERIOR FIT OUT - ISSUED FOR CONSTRUCTION
A-603-C	FINISH SCHEDULE	0	08/19/2016	INTERIOR FIT OUT - ISSUED FOR CONSTRUCTION
MECHANICAL				
M-000-C	MECHANICAL LEAD SHEET	0	08/19/2016	INTERIOR FIT OUT - ISSUED FOR CONSTRUCTION
MH-101-C	FIRST FLOOR - AHU ZONING PLAN	0	08/19/2016	INTERIOR FIT OUT - ISSUED FOR CONSTRUCTION
MH-102-C	SECOND FLOOR - AHU ZONING PLAN	0	08/19/2016	INTERIOR FIT OUT - ISSUED FOR CONSTRUCTION
MH-201-C	PRESSURIZATION AND CLASSIFICATION PLAN	0	08/19/2016	INTERIOR FIT OUT - ISSUED FOR CONSTRUCTION
MH-301-C	FIRST FLOOR - SUPPLY DUCTWORK PLAN	0	08/19/2016	INTERIOR FIT OUT - ISSUED FOR CONSTRUCTION
MH-302-C	SECOND FLOOR - SUPPLY DUCTWORK PLAN	0	08/19/2016	INTERIOR FIT OUT - ISSUED FOR CONSTRUCTION
MH-401-C	FIRST FLOOR - RETURN DUCTWORK PLAN	0	08/19/2016	INTERIOR FIT OUT - ISSUED FOR CONSTRUCTION
MH-402-C	SECOND FLOOR - RETURN DUCTWORK PLAN	0	08/19/2016	INTERIOR FIT OUT - ISSUED FOR CONSTRUCTION
MH-403-C	ROOF - MECHANICAL DUCTWORK PLAN	0	08/19/2016	INTERIOR FIT OUT - ISSUED FOR CONSTRUCTION
MH-800-C	MECHANICAL HVAC SCHEDULES	0	08/19/2016	INTERIOR FIT OUT - ISSUED FOR CONSTRUCTION
MH-801-C	MECHANICAL DUCTWORK DETAILS	0	08/19/2016	INTERIOR FIT OUT - ISSUED FOR CONSTRUCTION
MH-802-C	MECHANICAL DUCTWORK DETAILS	0	08/19/2016	INTERIOR FIT OUT - ISSUED FOR CONSTRUCTION
MECHANICAL - PIPING				
MP-102-C	SECOND FLOOR - CHILLED GLYCOL PIPING PLAN	0	08/19/2016	INTERIOR FIT OUT - ISSUED FOR CONSTRUCTION
MP-201-C	FIRST FLOOR - HEATING HOT GLYCOL PIPING PLAN	0	08/19/2016	INTERIOR FIT OUT - ISSUED FOR CONSTRUCTION
MP-202-C	SECOND FLOOR - HEATING HOT GLYCOL PIPING PLAN	0	08/19/2016	INTERIOR FIT OUT - ISSUED FOR CONSTRUCTION
MP-301-C	FIRST FLOOR - STEAM PIPING PLAN	0	08/19/2016	INTERIOR FIT OUT - ISSUED FOR CONSTRUCTION
MP-302-C	SECOND FLOOR - STEAM PIPING PLAN	0	08/19/2016	INTERIOR FIT OUT - ISSUED FOR CONSTRUCTION
MP-401-C	FIRST FLOOR - CONDENSATE PIPING PLAN	0	08/19/2016	INTERIOR FIT OUT - ISSUED FOR CONSTRUCTION
MP-402-C	SECOND FLOOR - CONDENSATE PIPING PLAN	0	08/19/2016	INTERIOR FIT OUT - ISSUED FOR CONSTRUCTION
MP-502-C	SECOND FLOOR - HEAT RECOVERY PIPING PLAN	0	08/19/2016	INTERIOR FIT OUT - ISSUED FOR CONSTRUCTION
MP-603-C	ROOF - MECHANICAL PIPING PLAN	0	08/19/2016	INTERIOR FIT OUT - ISSUED FOR CONSTRUCTION
MP-702-C	MECHANICAL ROOM ENLARGED PIPING PLAN	0	08/19/2016	INTERIOR FIT OUT - ISSUED FOR CONSTRUCTION
MP-800-C	MECHANICAL PIPING SCHEDULES	0	08/19/2016	INTERIOR FIT OUT - ISSUED FOR CONSTRUCTION
MP-801-C	MECHANICAL PIPING SCHEDULES	0	08/19/2016	INTERIOR FIT OUT - ISSUED FOR CONSTRUCTION
MP-802-C	MECHANICAL PIPING DETAILS	0	08/19/2016	INTERIOR FIT OUT - ISSUED FOR CONSTRUCTION
FIRE PROTECTION				
FP-000-C	FIRE PROTECTION LEAD SHEET	0	08/19/2016	INTERIOR FIT OUT - ISSUED FOR CONSTRUCTION
FP-101-C	FIRST FLOOR - FIRE PROTECTION ZONING PLAN	0	08/19/2016	INTERIOR FIT OUT - ISSUED FOR CONSTRUCTION
FP-102-C	SECOND FLOOR - FIRE PROTECTION ZONING PLAN	0	08/19/2016	INTERIOR FIT OUT - ISSUED FOR CONSTRUCTION
FP-103-C	ROOF - FIRE PROTECTION ZONING PLAN	0	08/19/2016	INTERIOR FIT OUT - ISSUED FOR CONSTRUCTION
FP-201-C	FIRST FLOOR - FIRE PROTECTION REFLECTIVE CEILING PLAN	0	08/19/2016	INTERIOR FIT OUT - ISSUED FOR CONSTRUCTION
FP-202-C	SECOND FLOOR - FIRE PROTECTION REFLECTIVE CEILING PLAN	0	08/19/2016	INTERIOR FIT OUT - ISSUED FOR CONSTRUCTION
FP-203-C	ROOF - FIRE PROTECTION REFLECTIVE CEILING PLAN	0	08/19/2016	INTERIOR FIT OUT - ISSUED FOR CONSTRUCTION
FP-800-C	FIRE PROTECTION DETAIL SHEET	0	08/19/2016	INTERIOR FIT OUT - ISSUED FOR CONSTRUCTION
PLUMBING				
P-000-C	PLUMBING AND PROCESS LEAD SHEET	0	08/19/2016	INTERIOR FIT OUT - ISSUED FOR CONSTRUCTION
PL-101-C	FIRST FLOOR - SANITARY, STORM, AND PROCESS DRAIN PLAN	0	08/19/2016	INTERIOR FIT OUT - ISSUED FOR CONSTRUCTION
PL-102-C	SECOND FLOOR - SANITARY, STORM, AND PROCESS DRAIN PLAN	0	08/19/2016	INTERIOR FIT OUT - ISSUED FOR CONSTRUCTION
PL-201-C	FIRST FLOOR - DOMESTIC WATER PIPING PLAN	0	08/19/2016	INTERIOR FIT OUT - ISSUED FOR CONSTRUCTION
PL-202-C	SECOND FLOOR - DOMESTIC WATER PIPING PLAN	0	08/19/2016	INTERIOR FIT OUT - ISSUED FOR CONSTRUCTION
PL-403-C	ROOF - PLUMBING PIPING PLAN	0	08/19/2016	INTERIOR FIT OUT - ISSUED FOR CONSTRUCTION
PL-800-C	PLUMBING DETAILS SHEET	0	08/19/2016	INTERIOR FIT OUT - ISSUED FOR CONSTRUCTION
PL-801-C	PLUMBING SCHEDULES	0	08/19/2016	INTERIOR FIT OUT - ISSUED FOR CONSTRUCTION
PL-900-C	PLUMBING ISOMETRIC PLAN	0	08/19/2016	INTERIOR FIT OUT - ISSUED FOR CONSTRUCTION
ELECTRICAL				
E-000-C	ELECTRICAL LEAD SHEET	0	08/19/2016	INTERIOR FIT OUT - ISSUED FOR CONSTRUCTION
E-101-C	ELECTRICAL SITE PLAN	0	08/19/2016	INTERIOR FIT OUT - ISSUED FOR CONSTRUCTION
E-101-C	FIRST FLOOR - POWER PLAN	0	08/19/2016	INTERIOR FIT OUT - ISSUED FOR CONSTRUCTION
E-102-C	SECOND FLOOR - POWER PLAN	0	08/19/2016	INTERIOR FIT OUT - ISSUED FOR CONSTRUCTION
E-103-C	ROOF PLAN - POWER PLAN	0	08/19/2016	INTERIOR FIT OUT - ISSUED FOR CONSTRUCTION
E-201-C	FIRST FLOOR - LIGHTING PLAN	0	08/19/2016	INTERIOR FIT OUT - ISSUED FOR CONSTRUCTION
E-202-C	SECOND FLOOR - LIGHTING PLAN	0	08/19/2016	INTERIOR FIT OUT - ISSUED FOR CONSTRUCTION
E-311-C	FIRST FLOOR - TELECOMMUNICATIONS & SECURITY PLAN	0	08/19/2016	INTERIOR FIT OUT - ISSUED FOR CONSTRUCTION
E-302-C	SECOND FLOOR - TELECOMMUNICATIONS & SECURITY PLAN	0	08/19/2016	INTERIOR FIT OUT - ISSUED FOR CONSTRUCTION
E-400-C	FIRE ALARM SYMBOLS, NOTES & RISER	0	08/19/2016	INTERIOR FIT OUT - ISSUED FOR CONSTRUCTION
E-401-C	FIRST FLOOR - FIRE ALARM PLAN	0	08/19/2016	INTERIOR FIT OUT - ISSUED FOR CONSTRUCTION
E-402-C	SECOND FLOOR - FIRE ALARM PLAN	0	08/19/2016	INTERIOR FIT OUT - ISSUED FOR CONSTRUCTION
E-501-C	HAZARDOUS CLASSIFICATION PLAN	0	08/19/2016	INTERIOR FIT OUT - ISSUED FOR CONSTRUCTION
E-601-C	FIRST FLOOR GROUNDING AND CONDUIT ROUTING	0	08/19/2016	INTERIOR FIT OUT - ISSUED FOR CONSTRUCTION
E-800-C	ELECTRICAL DETAILS	0	08/19/2016	INTERIOR FIT OUT - ISSUED FOR CONSTRUCTION
E-801-C	LIGHTING DETAILS	0	08/19/2016	INTERIOR FIT OUT - ISSUED FOR CONSTRUCTION
E-802-C	PANEL SCHEDULES (1 OF 3)	0	08/19/2016	INTERIOR FIT OUT - ISSUED FOR CONSTRUCTION
E-803-C	PANEL SCHEDULES (2 OF 3)	0	08/19/2016	INTERIOR FIT OUT - ISSUED FOR CONSTRUCTION
E-804-C	PANEL SCHEDULES (3 OF 3)	0	08/19/2016	INTERIOR FIT OUT - ISSUED FOR CONSTRUCTION
E-805-C	COMMUNICATION RISER DIAGRAMS	0	08/19/2016	INTERIOR FIT OUT - ISSUED FOR CONSTRUCTION
E-806-C	DOOR INTERLOCK MATRIX AND DETAILS	0	08/19/2016	INTERIOR FIT OUT - ISSUED FOR CONSTRUCTION
E-800-C	ONE LINE DIAGRAM	0	08/19/2016	INTERIOR FIT OUT - ISSUED FOR CONSTRUCTION
PROCESS				
DP-101-C	FIRST FLOOR - COMPRESSED AIR PIPING PLAN	0	08/19/2016	INTERIOR FIT OUT - ISSUED FOR CONSTRUCTION
DP-102-C	SECOND FLOOR - COMPRESSED AIR PIPING PLAN	0	08/19/2016	INTERIOR FIT OUT - ISSUED FOR CONSTRUCTION
DP-201-C	FIRST FLOOR - CLEAN STEAM AND CONDENSATE PIPING PLAN	0	08/19/2016	INTERIOR FIT OUT - ISSUED FOR CONSTRUCTION
DP-202-C	SECOND FLOOR - CLEAN STEAM AND CONDENSATE PIPING PLAN	0	08/19/2016	INTERIOR FIT OUT - ISSUED FOR CONSTRUCTION

Seal Block



Copyright Reserved
The Contractor shall verify and be responsible for all dimensions, DO NOT scale the drawing - any errors or omissions shall be reported to Stantec, without delay.
The Copyrights to all designs and drawings are the property of Stantec. Reproduction or use for any purpose other than that authorized by Stantec is prohibited.

Revision	By	App'd	MM/DD/YYYY
0	JLB	KJM	08/19/2016
PACKAGE C - INTERIOR FIT-OUT			
PACKAGE B - SUPERSTRUCTURE & SHELL			
PACKAGE A - FOUNDATIONS & BELOW SLAB			
Issued	By	App'd	MM/DD/YYYY

Title
PACKAGE C - COVER

Project No.
191504176

Scale

Revision
0

Drawing No.

COVER C