

Revision	By	App'd	DD.MM.YYYY
0	INTERIOR FIT OUT - ISSUED FOR CONSTRUCTION		08/19/2016
	PACKAGE C - INTERIOR FIT-OUT		08.19.2016
	PACKAGE B - SUPERSTRUCTURE & SHELL		08.05.2016
	PACKAGE A - FOUNDATIONS & BELOW SLAB		07.22.2016
	Issued		07.22.2016


Permit-Seal

Client/Project
 IMMUCELL

Lot 11 - Second Tee Business Park
 1039 Riverside Street
 Portland, Maine 04103

Title
 SECOND FLOOR - COMPRESSED AIR PIPING PLAN

Project No. 191504176
 Scale 1/4" = 1'-0"
 Revision 0
 Drawing No.

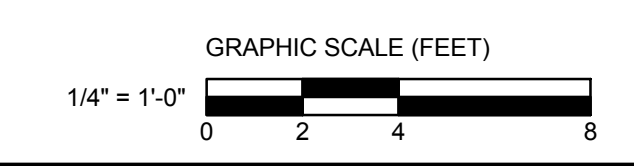

DP-102-C

ORIGINAL SHEET: A08 E (3/14/16)