

Revision	By	App'd	DD.MM.YYYY
0			08/19/2016
INTERIOR FIT-OUT - ISSUED FOR CONSTRUCTION			
1			08/19/2016
PACKAGE C - INTERIOR FIT-OUT			
2			08/05/2016
PACKAGE B - SUPERSTRUCTURE & SHELL			
3			07/22/2016
PACKAGE A - FOUNDATIONS & BELOW SLAB			
4			07/22/2016
Issued			

Permit-Seal

Client/Project
 IMMUCELL


Lot 11 - Second Tee Business Park
 1039 Riverside Street
 Portland, Maine 04103

Title
 FIRST FLOOR - CLEAN STEAM AND CONDENSATE PIPING PLAN

Project No.
 191504176
 Revision
 0

Scale
 1/4" = 1'-0"
 Drawing No.

DP-201-C

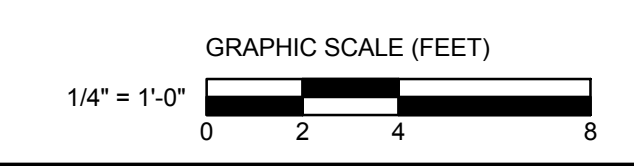

ORIGINAL SHEET: A/B (3/14/16)