

**GENERAL NOTES**

- PERFORM ALL WORK IN ACCORDANCE WITH THE NATIONAL ELECTRICAL CODE, NFPA 72 AND AUTHORITY HAVING JURISDICTION.
- REFER TO DRAWING E-402-C FOR FIRE ALARM SYMBOLS, NOTES, RISER DIAGRAM AND ADDITIONAL INFORMATION.
- ELECTRICAL CONTRACTOR TO FURNISH AND WIRE DUCT MOUNTED SMOKE DETECTORS. MECHANICAL CONTRACTOR TO INSTALL PER MANUFACTURER'S RECOMMENDATIONS. COORDINATE EXACT LOCATION WITH MECHANICAL DRAWINGS AND CONTRACTOR (TYPICAL).

Revision	By	App'd	DD.MM.YYYY
0			08/19/2016
INTERIOR FIT-OUT - ISSUED FOR CONSTRUCTION			
<b>PACKAGE C - INTERIOR FIT-OUT</b>			
<b>PACKAGE B - SUPERSTRUCTURE &amp; SHELL</b>			
<b>PACKAGE A - FOUNDATIONS &amp; BELOW SLAB</b>			
Issued			

Permit-Seal



Client/Project  
**IMMUCELL**

Lot 11 - Second Tee Business Park  
 1039 Riverside Street  
 Portland, Maine 04103


Title  
**SECOND FLOOR - FIRE ALARM PLAN**

Project No.  
 191504176

Scale  
 1/4" = 1'-0"

Revision  
 0

Drawing No.  
**E-402-C**

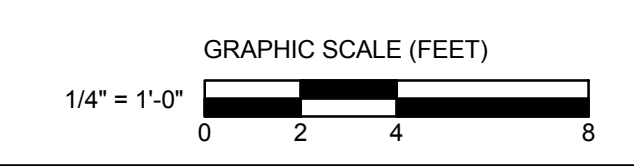

**1 SECOND FLOOR - FIRE ALARM PLAN**  
 1/4" = 1'-0"

E:\Projects\191504176\191504176\_01\_02\Fire Alarm\191504176\_01\_02\_01.dwg  
 8/19/2016 10:42:23 AM  
 User: jk  
 Plot Date: 8/19/2016 10:42:23 AM  
 Original Sheet: A0-E (of 4)