




1 DUCT PENETRATION THRU WALL DETAIL
MH-801-C N.T.S.

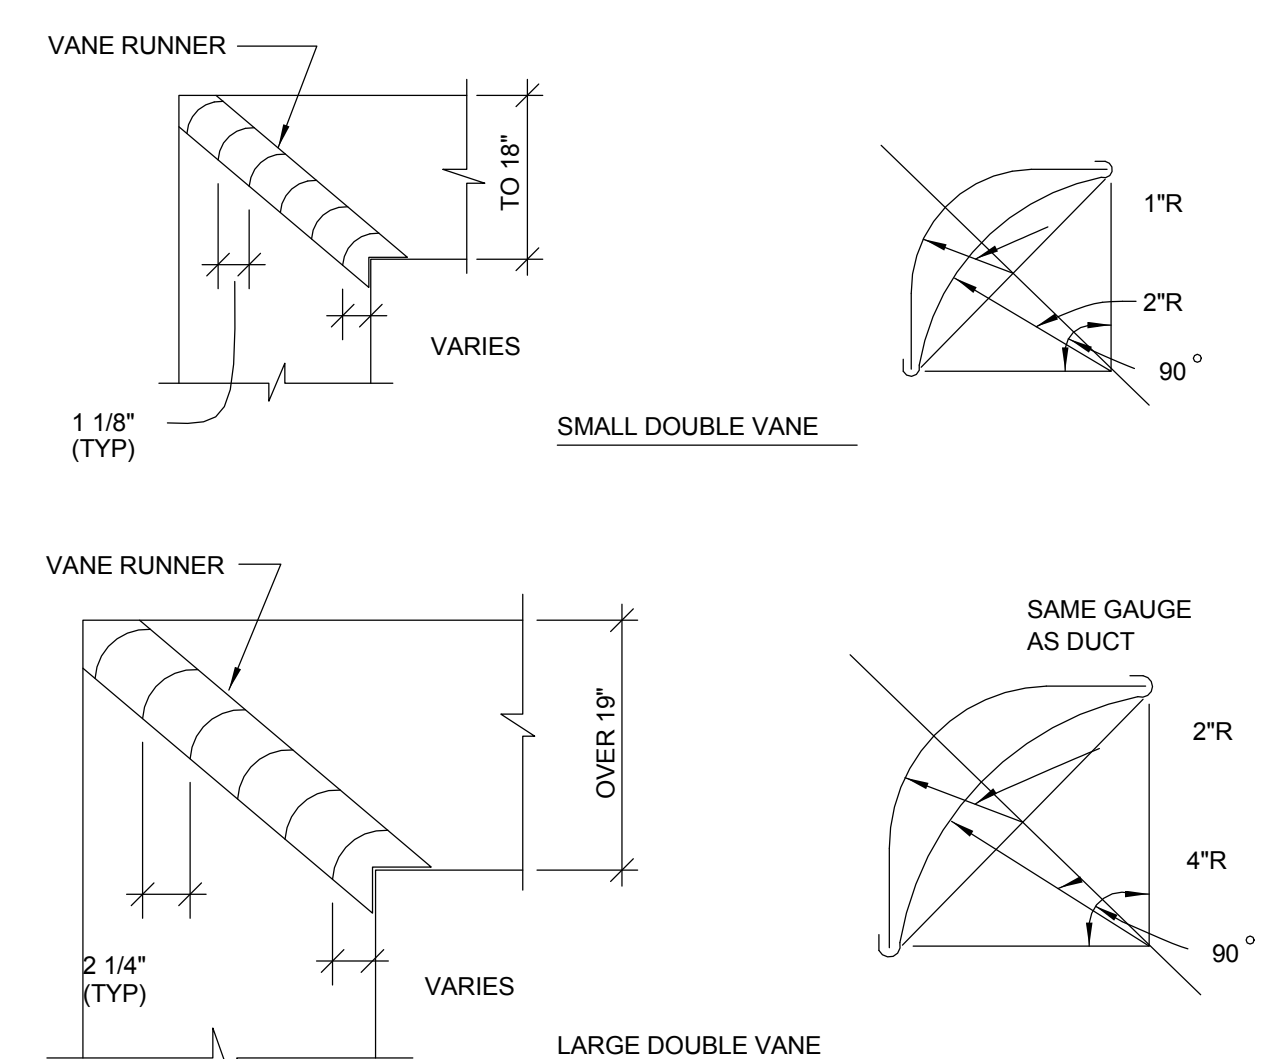


2 DUCT-TURN INSTALLATION DETAIL
MH-801-C N.T.S.

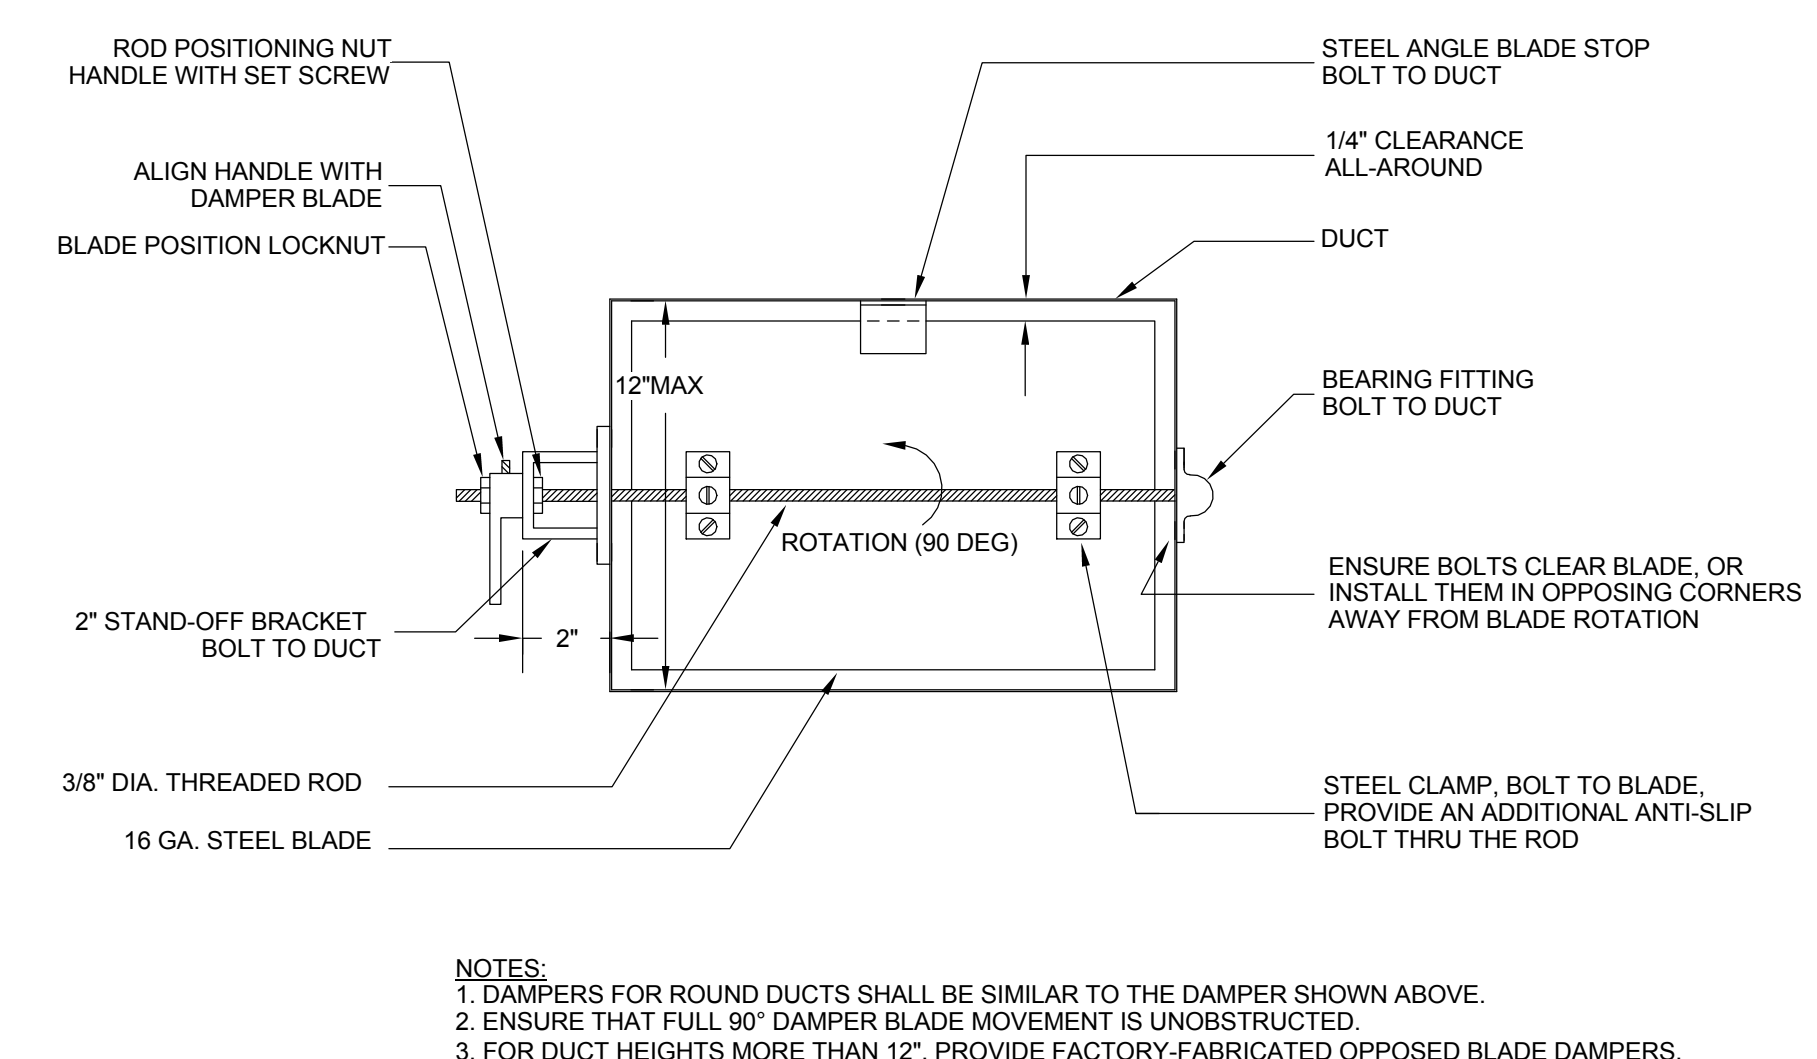


3 MANUAL DAMPER (ADJUSTABLE SINGLE-BLADE BALANCING TYPE)
MH-801-C N.T.S.

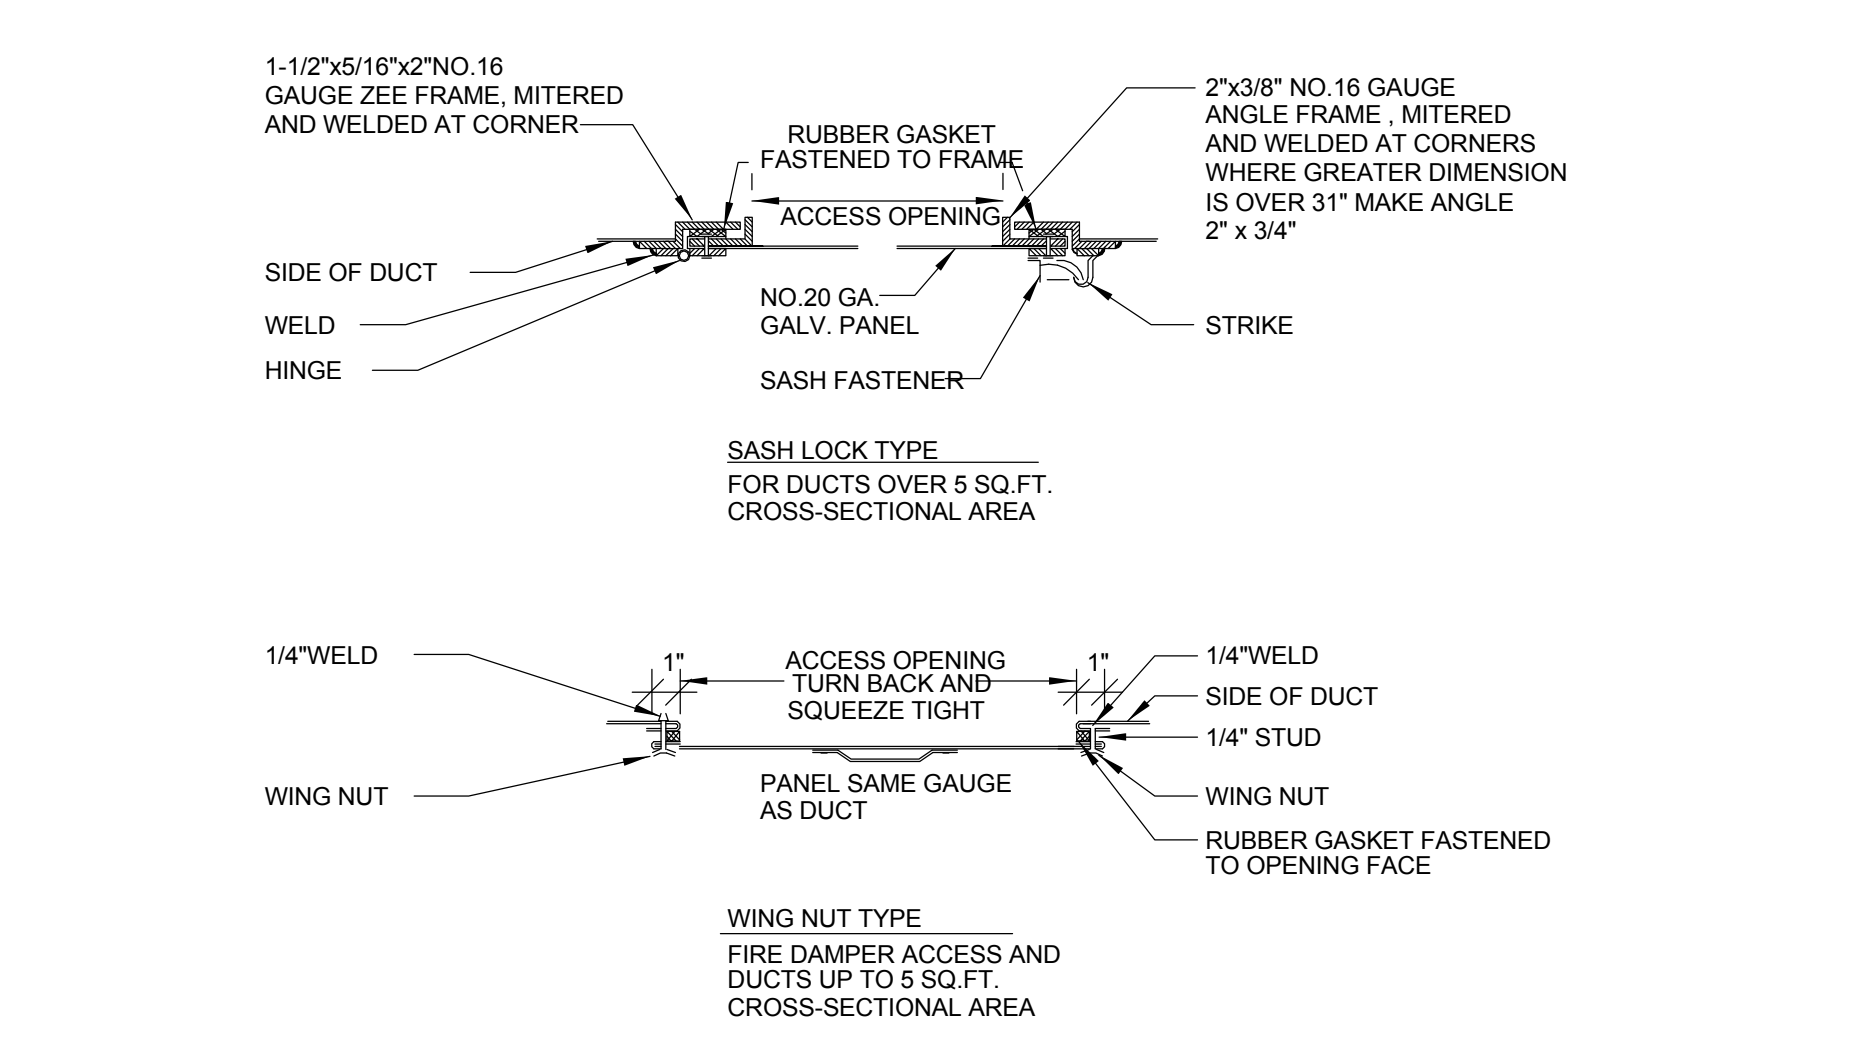


4 DUCTWORK ACCESS PANEL INSTALL DETAIL - UNINSULATED DUCT
MH-801-C N.T.S.

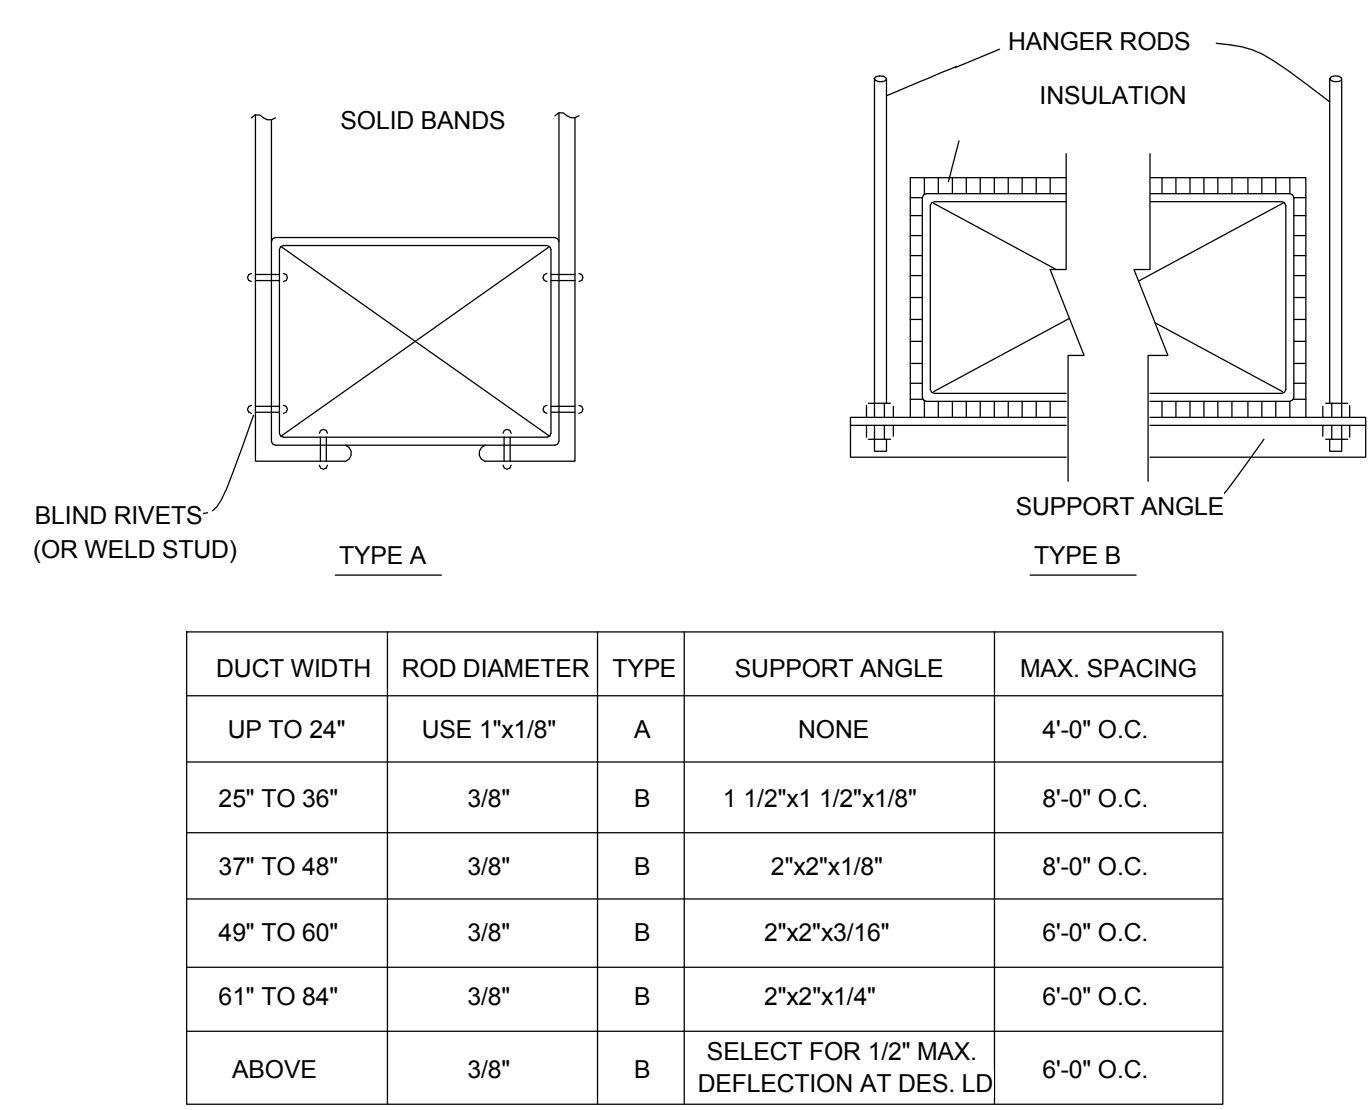


5 DUCTWORK HANGER DETAIL AND SCHEDULE
MH-801-C N.T.S.

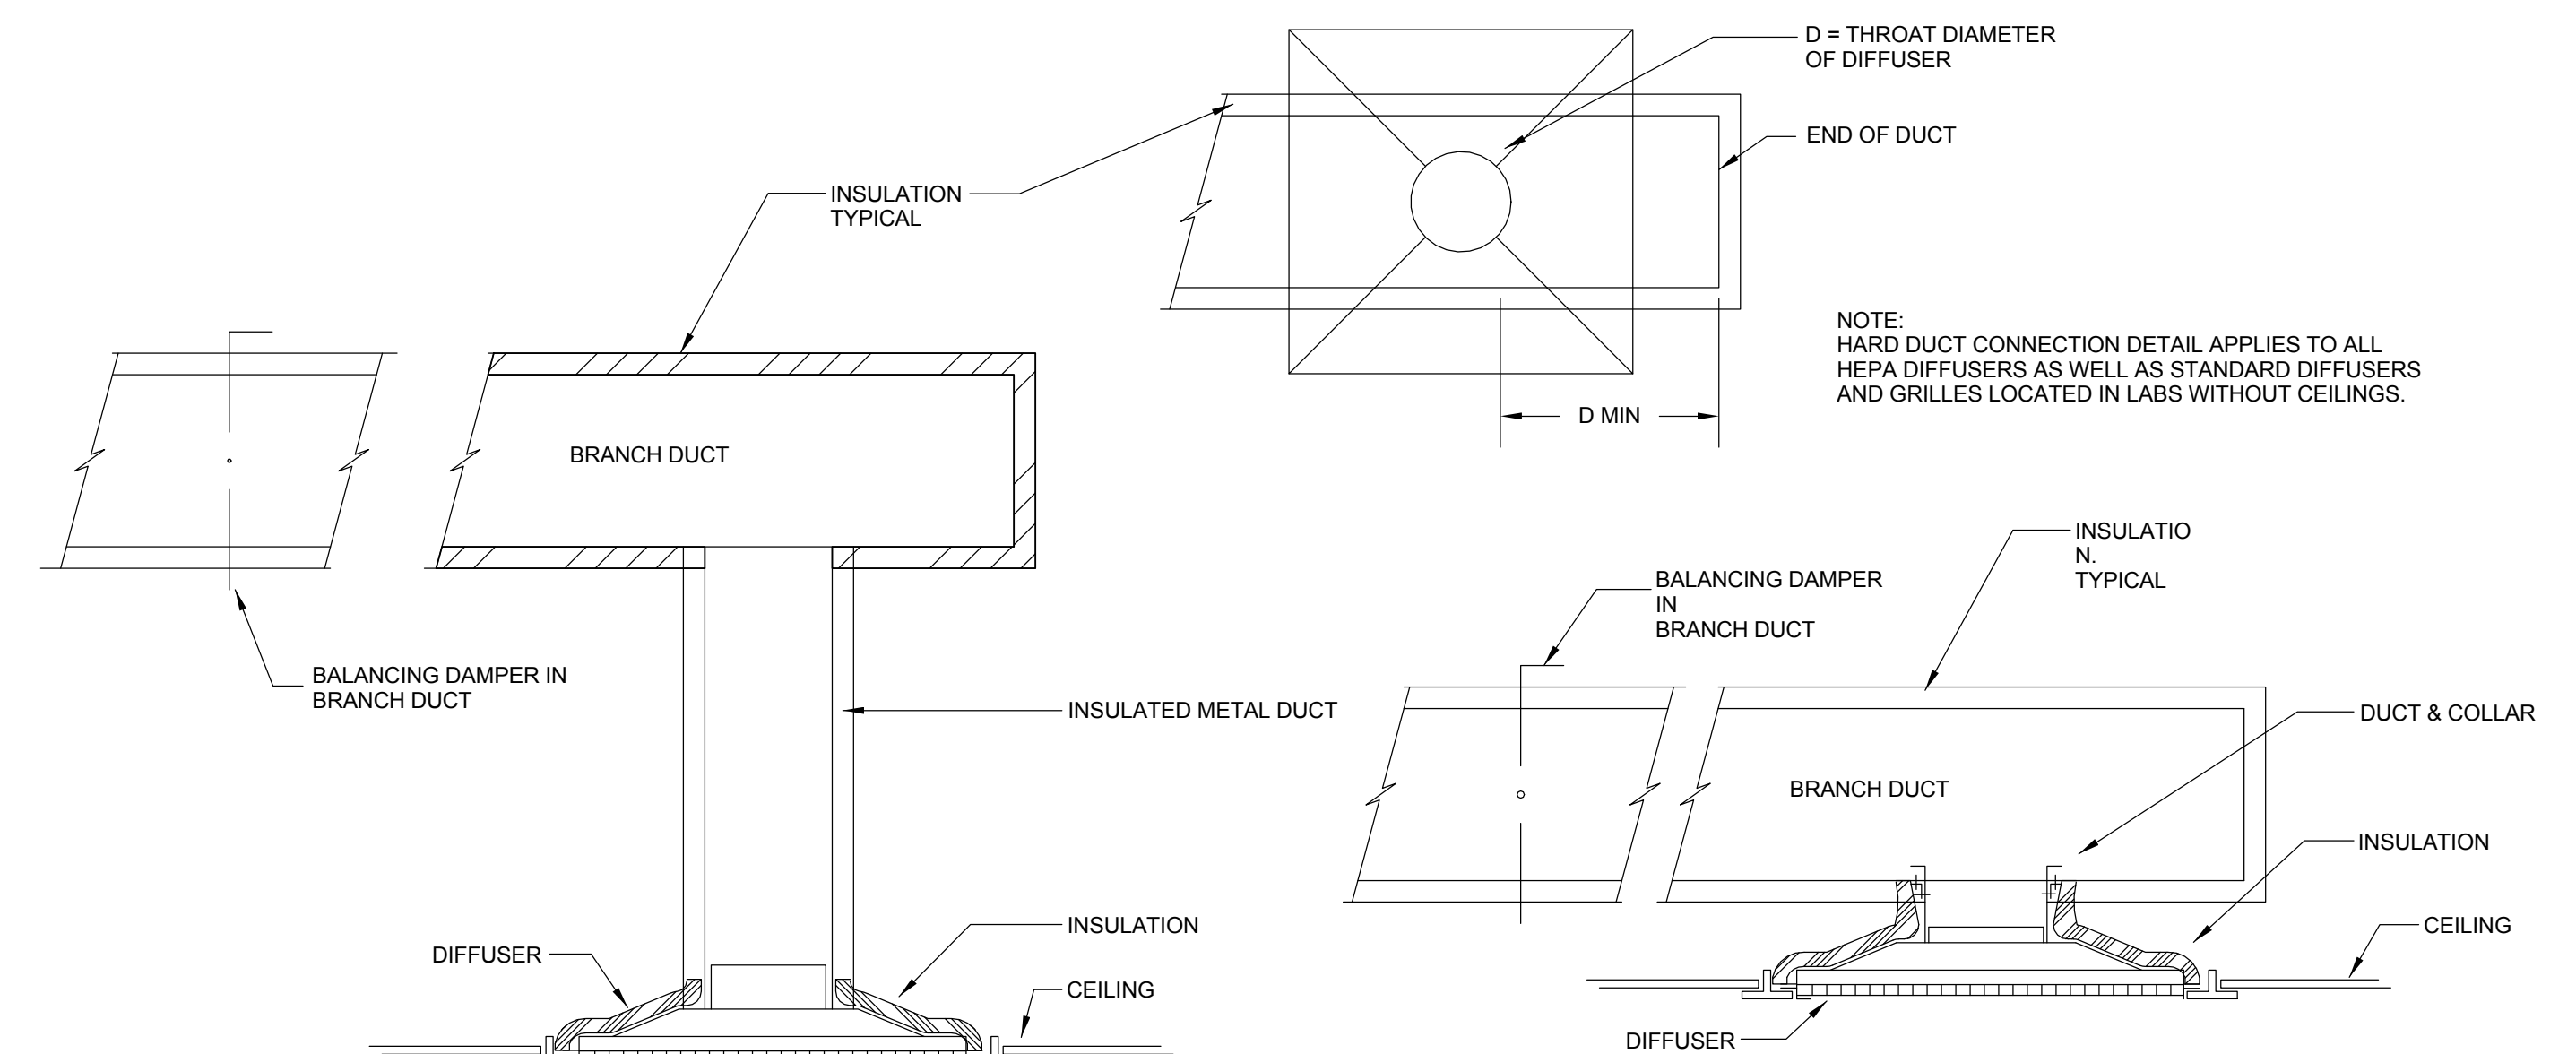


6 SUPPLY AIR DIFFUSER DETAIL
MH-801-C N.T.S.

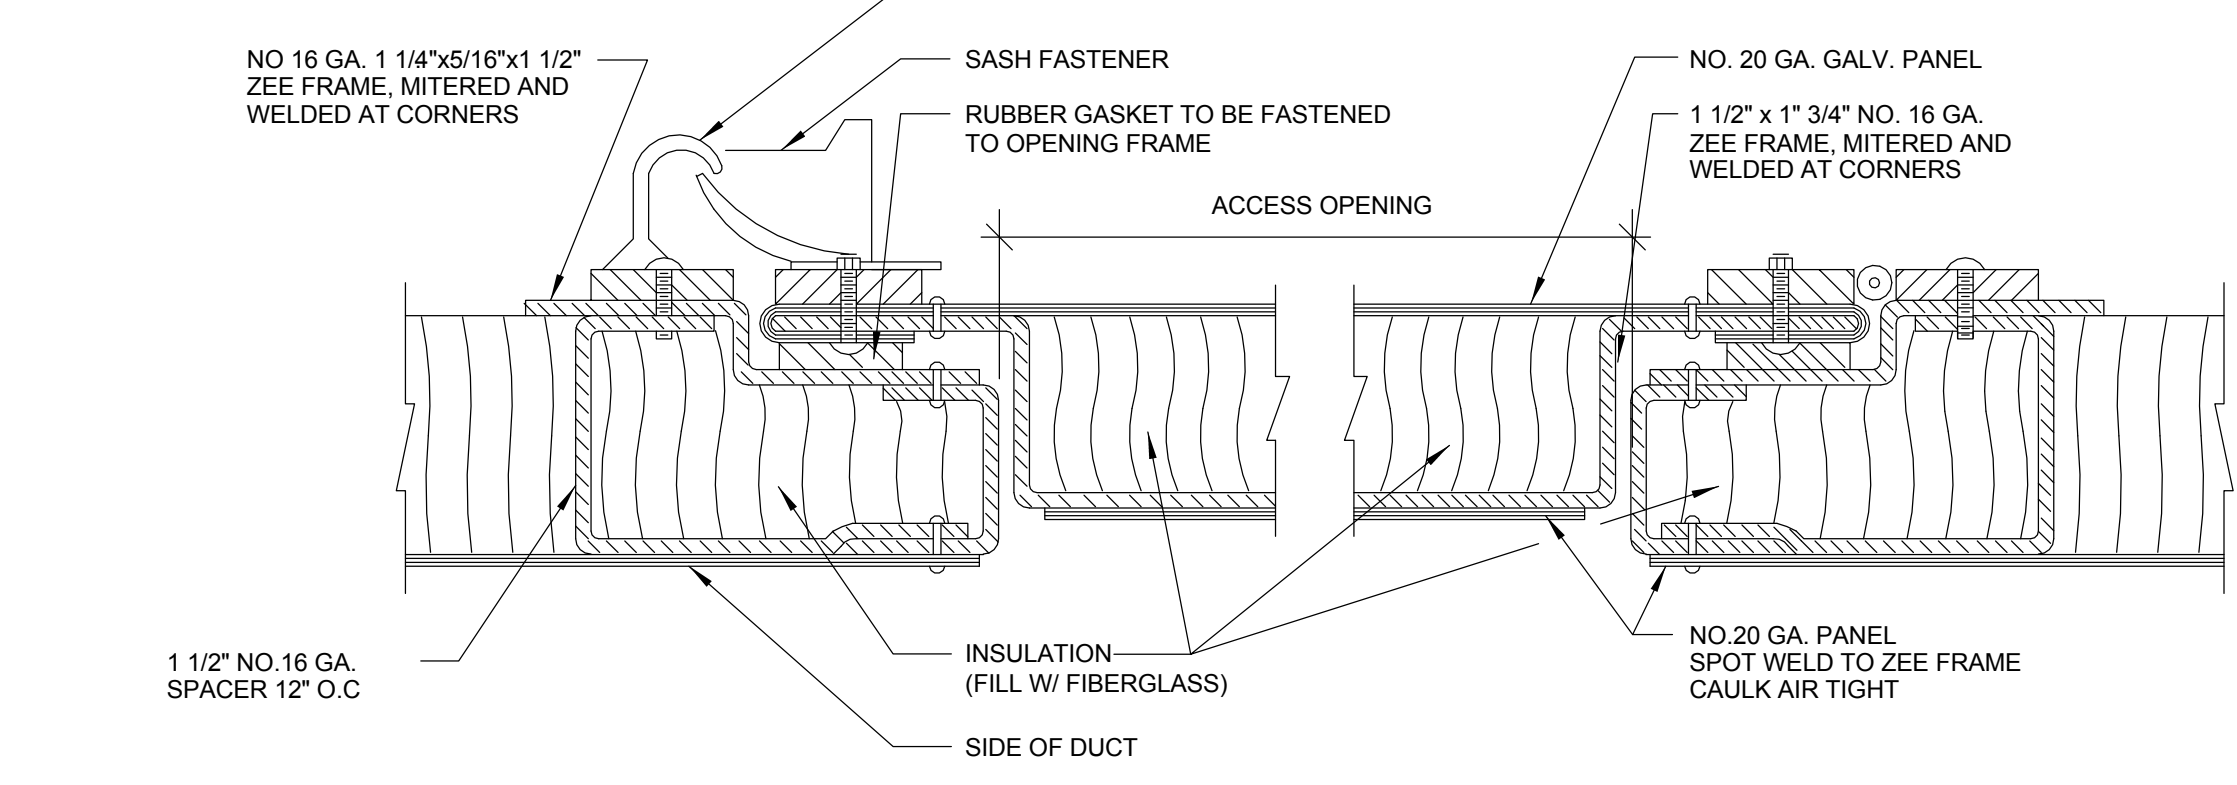


7 DUCTWORK ACCESS PANEL INSTALLATION DETAIL - INSULATED DUCT
MH-801-C N.T.S.

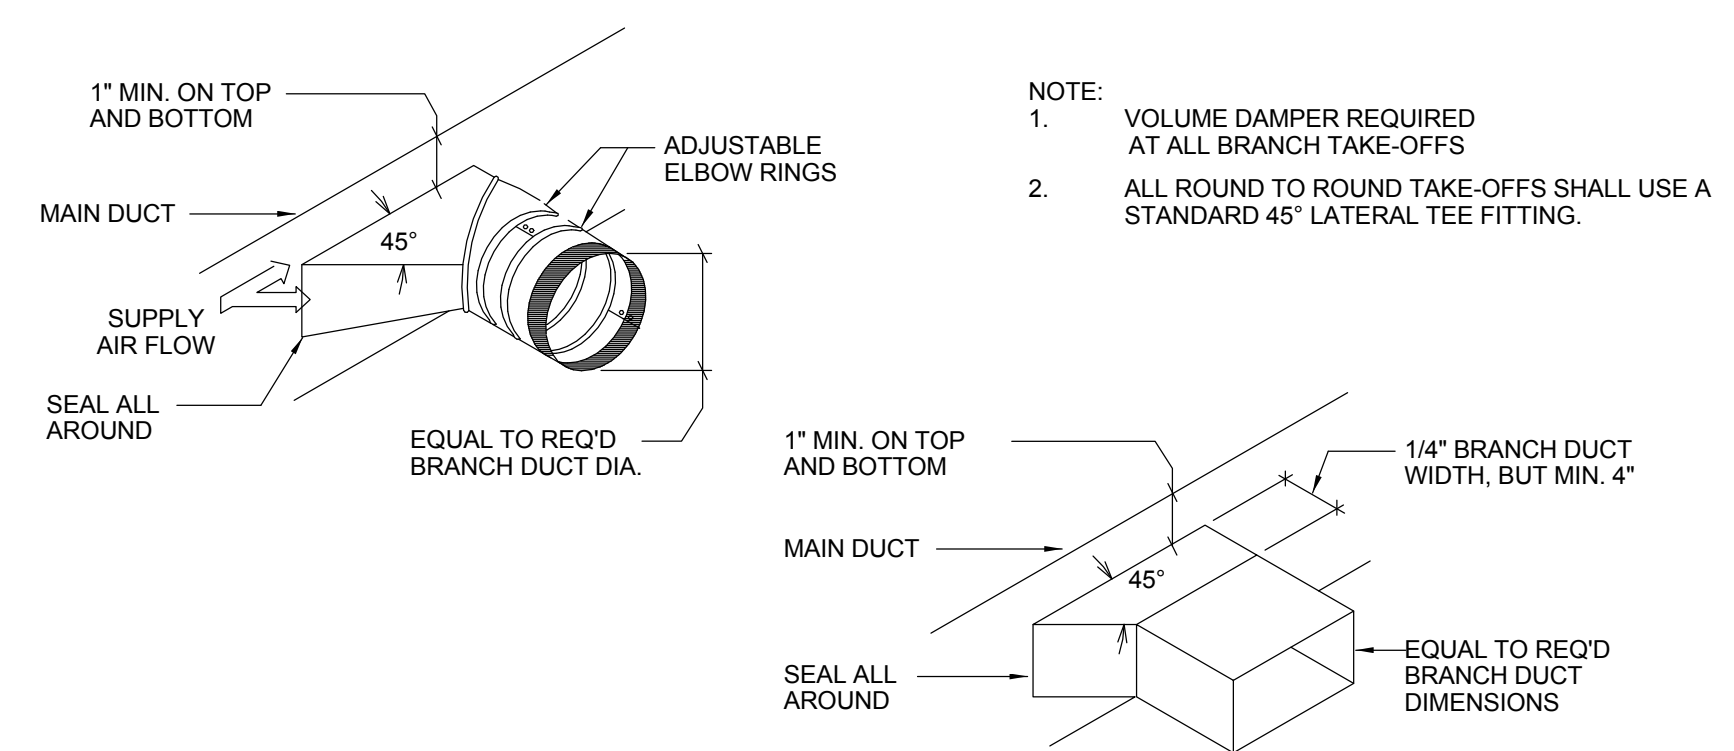


8 TYPICAL BRANCH TAKE-OFF FITTING DETAIL
MH-801-C N.T.S.

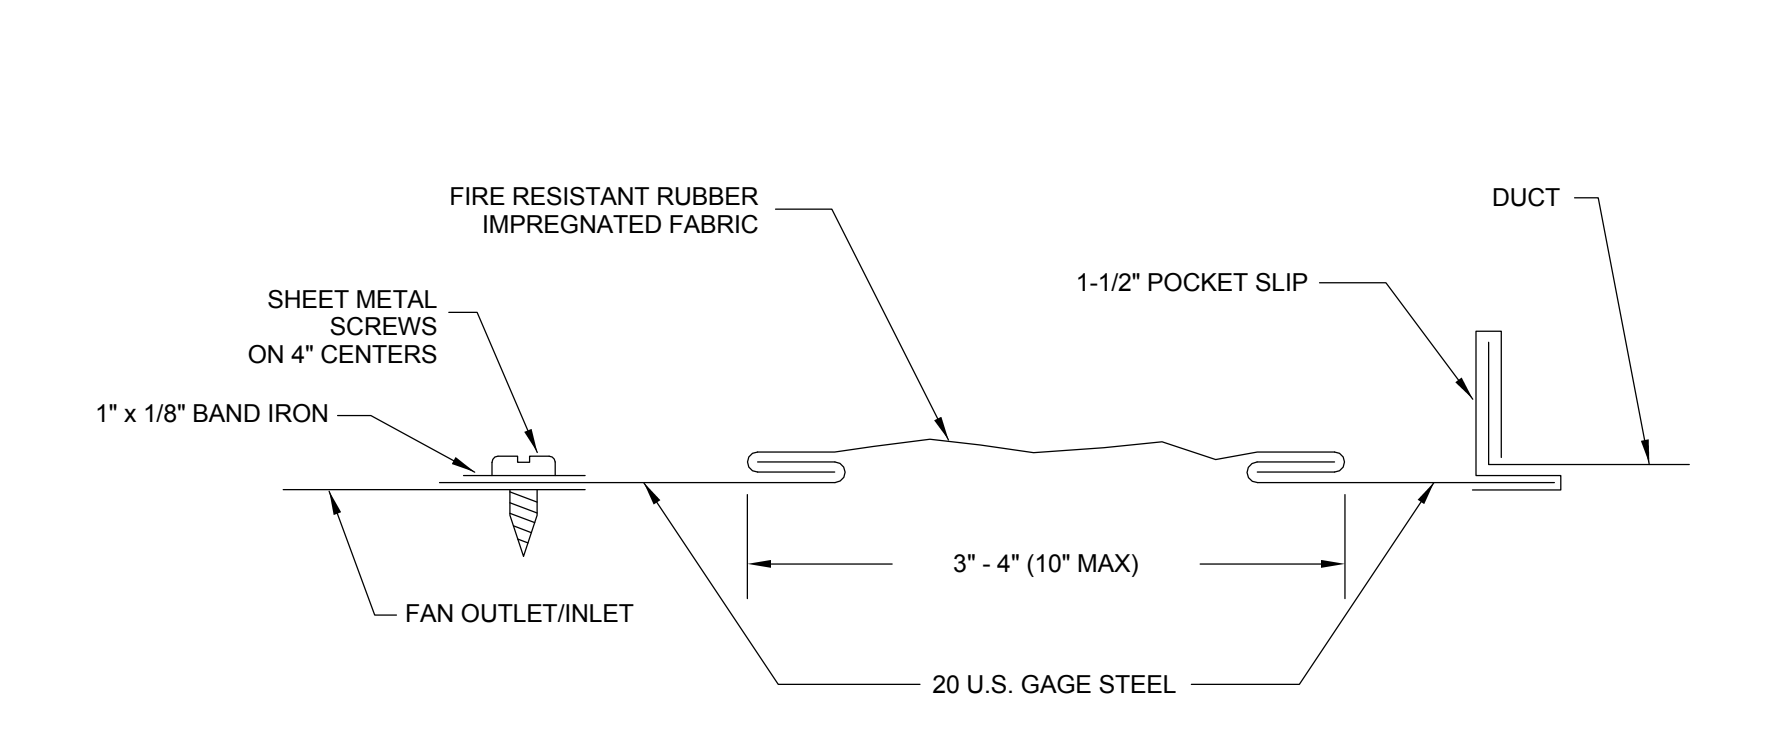


9 TYPICAL FLEXIBLE CONNECTION DETAIL
MH-801-C N.T.S.

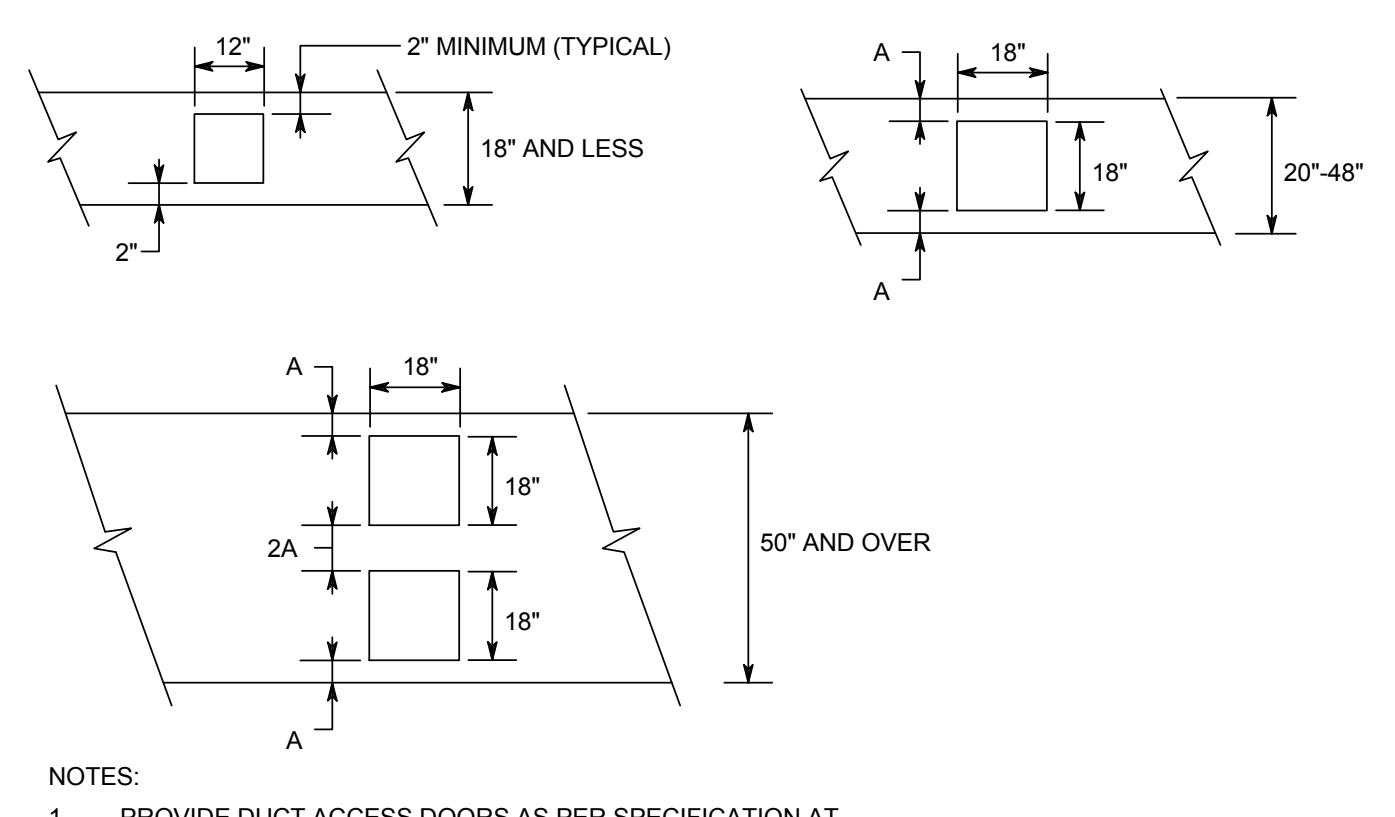


10 DUCT ACCESS DOOR DETAIL
MH-801-C N.T.S.

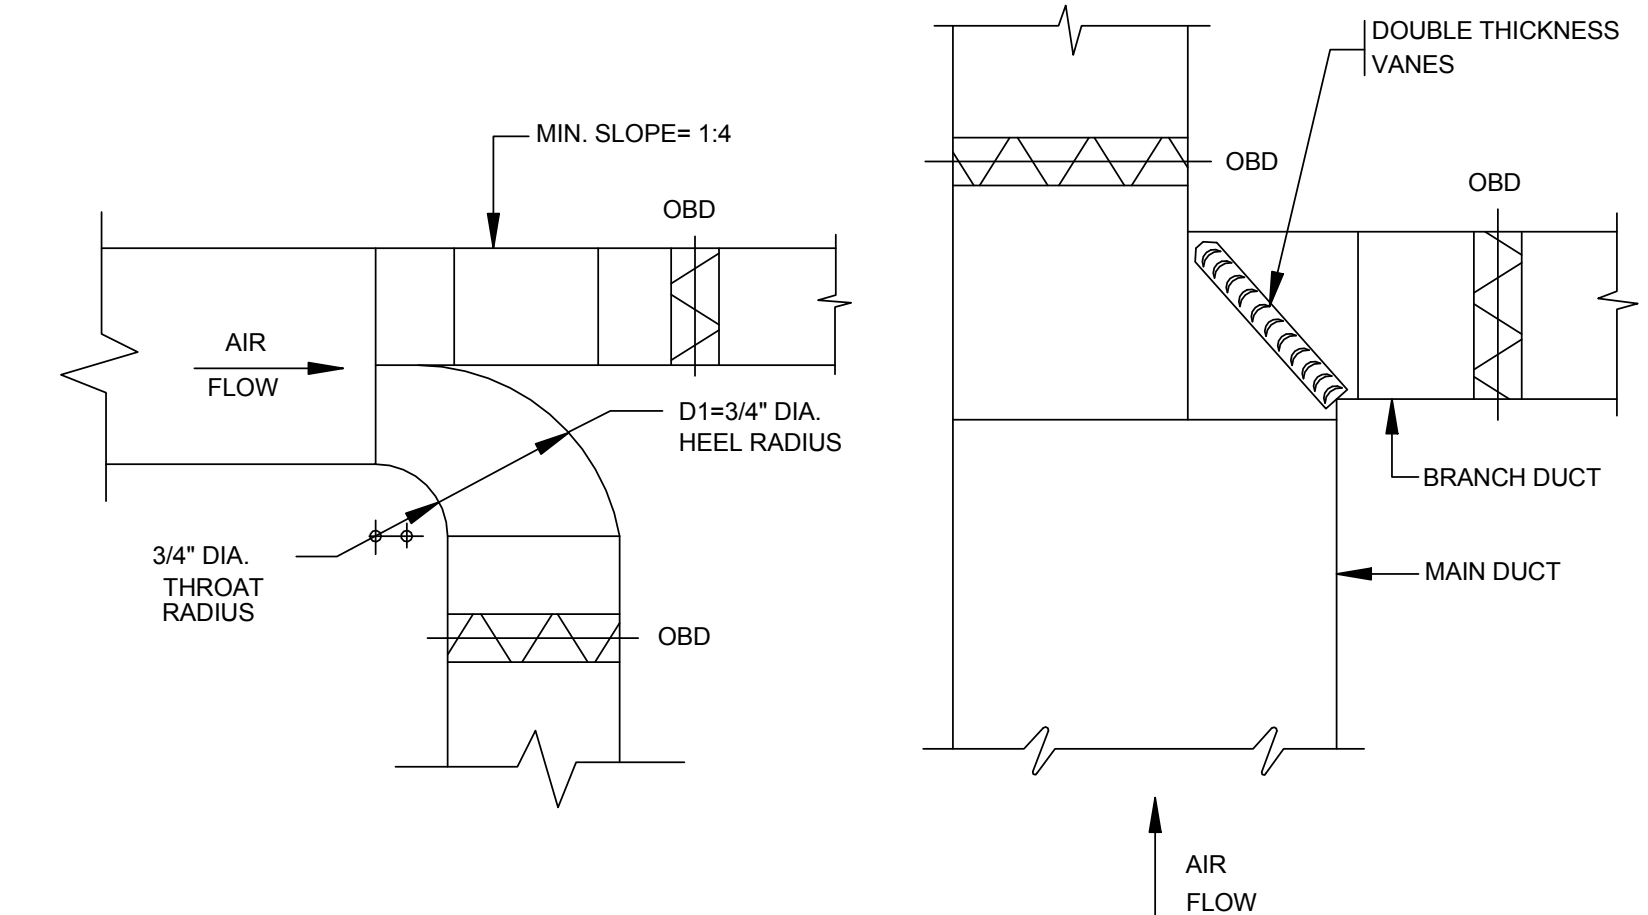


11 TYPICAL DUCT SPLITTER DETAIL
MH-801-C N.T.S.

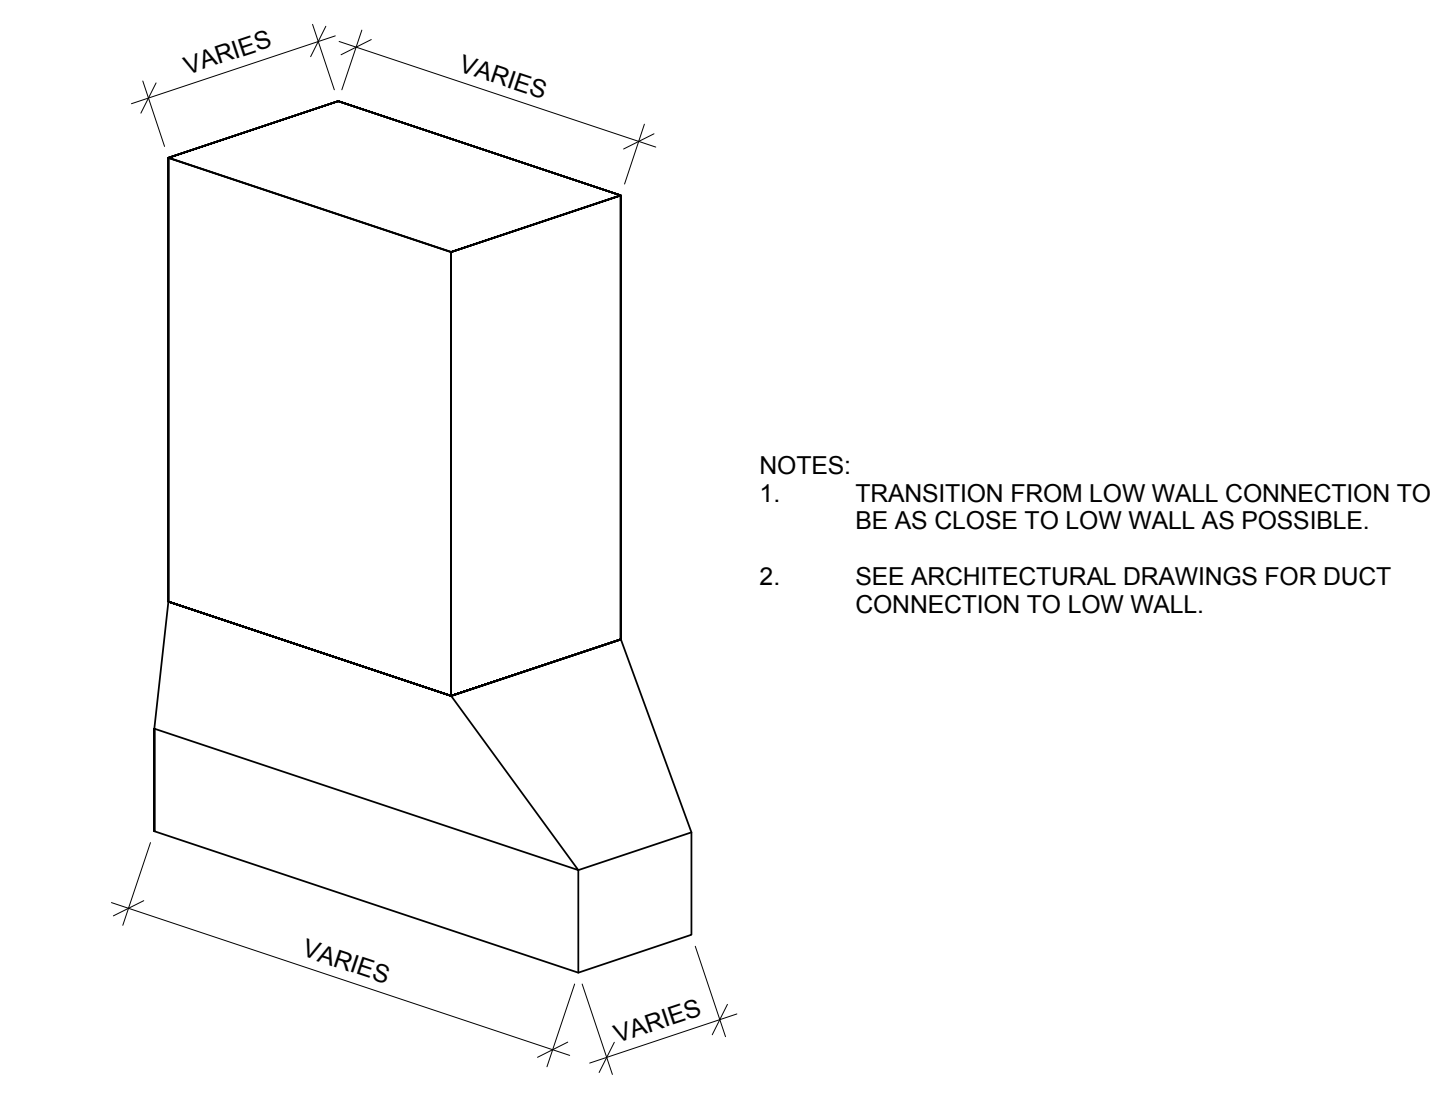


12 TYPICAL LOW WALL CONNECTION DETAIL
MH-801-C N.T.S.

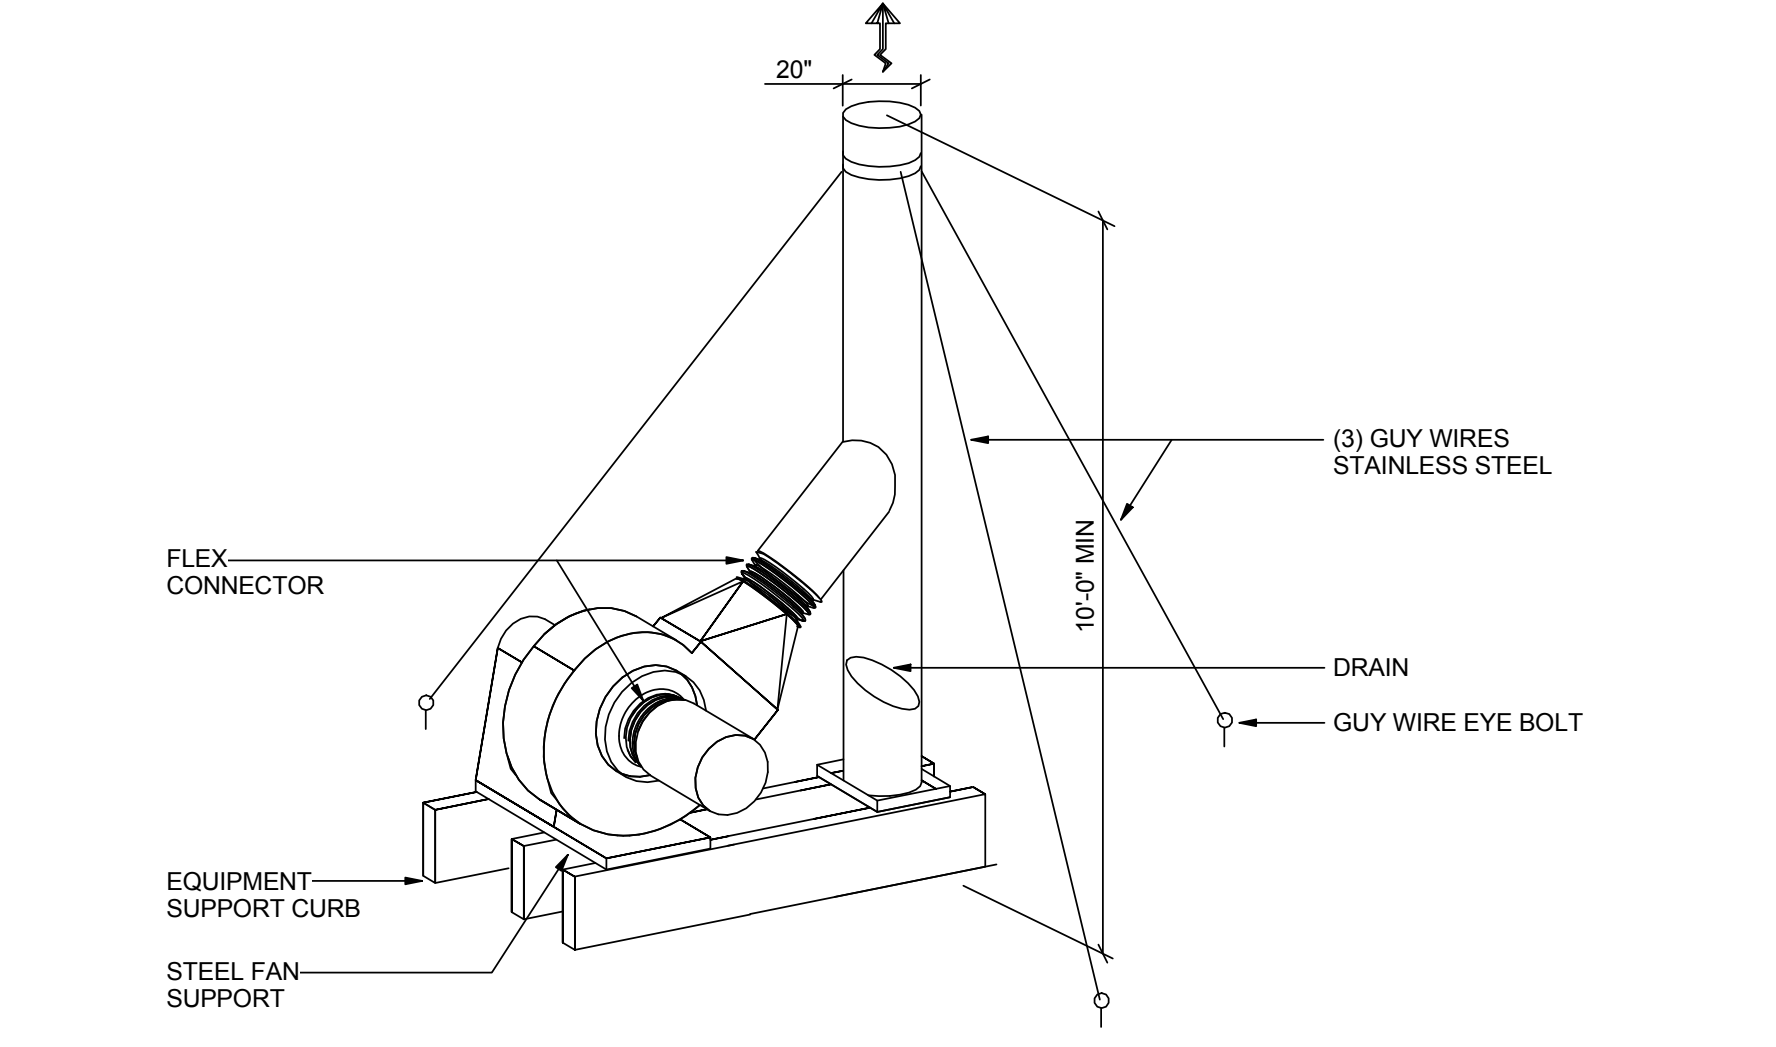


13 EXHAUST FAN DETAIL
MH-801-C N.T.S.

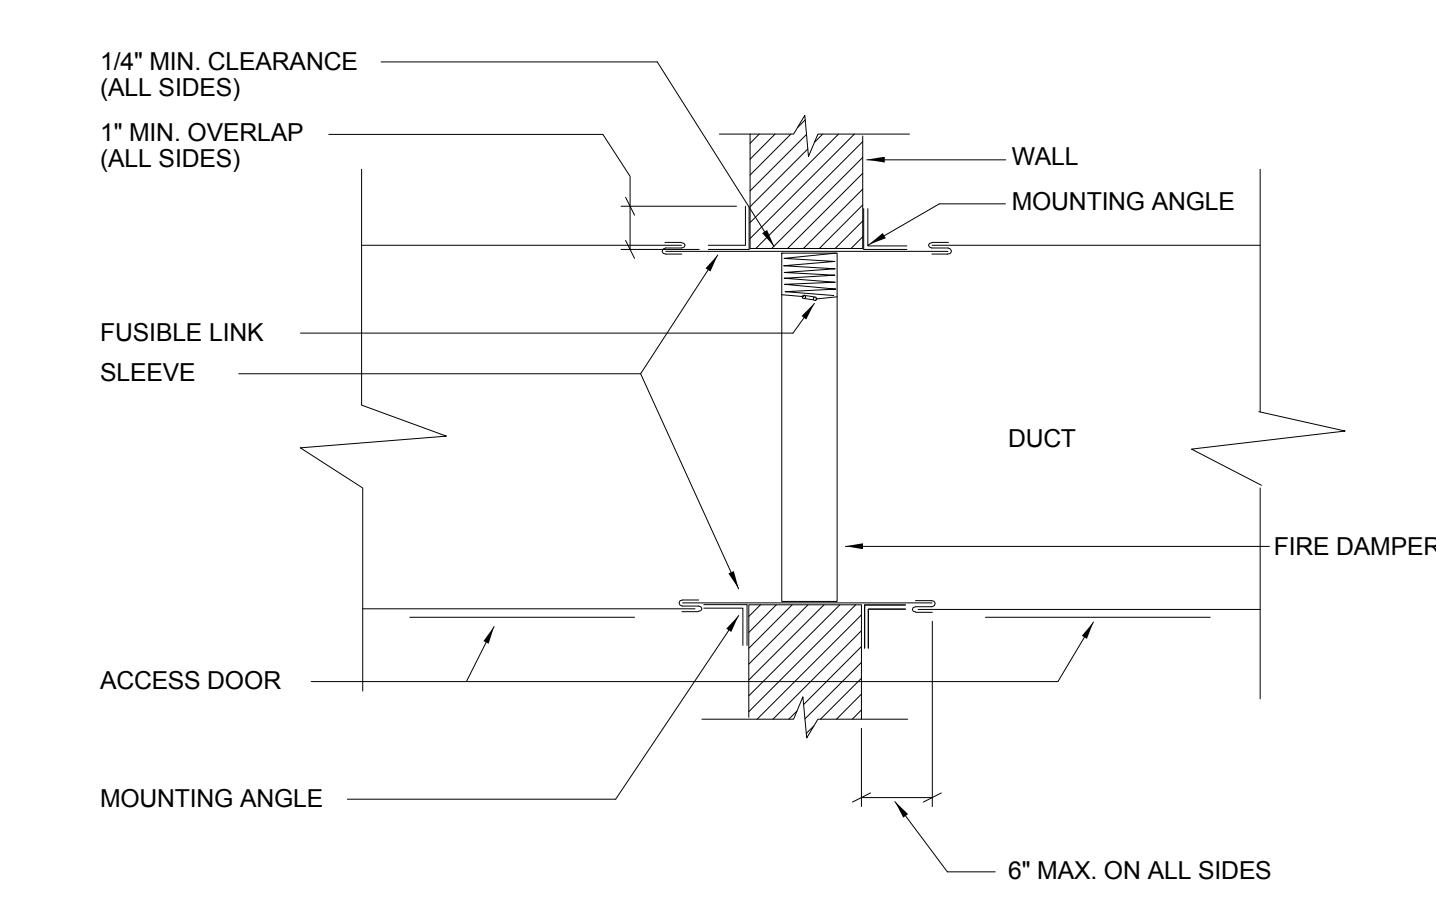

14 FIRE DAMPER DETAIL
MH-801-C N.T.S.

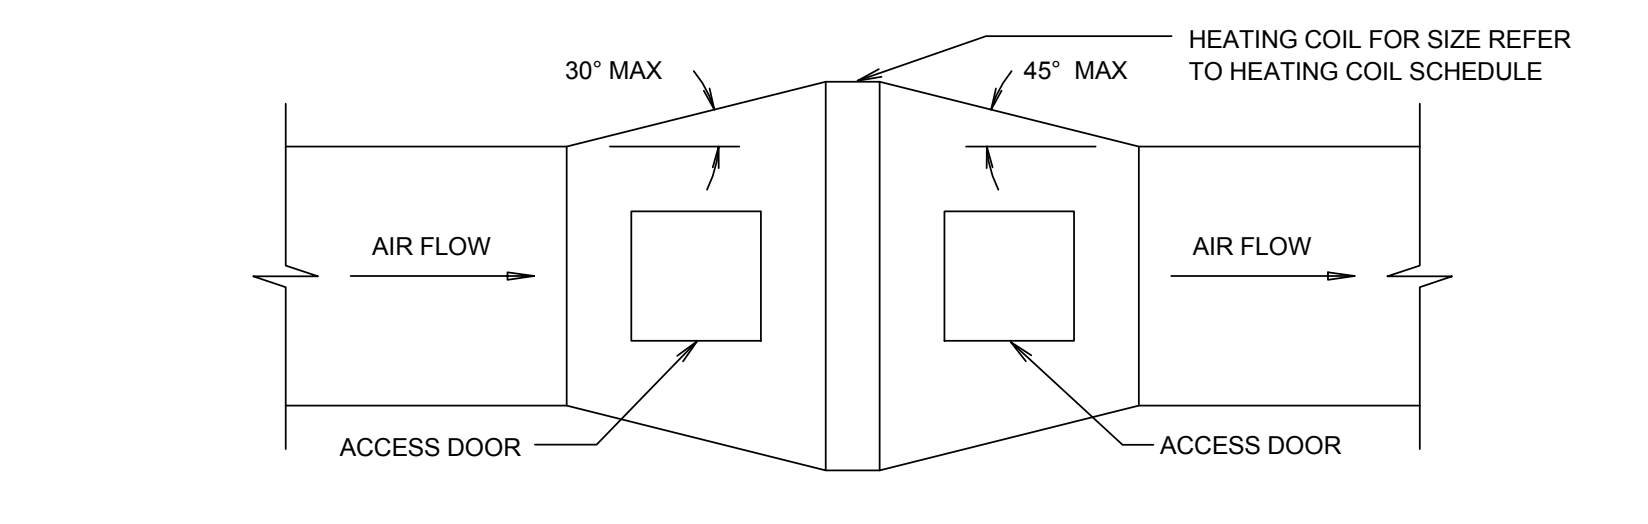

15 TYPICAL DUCT CONNECTION AT RE-HEATING COILS
MH-801-C N.T.S.

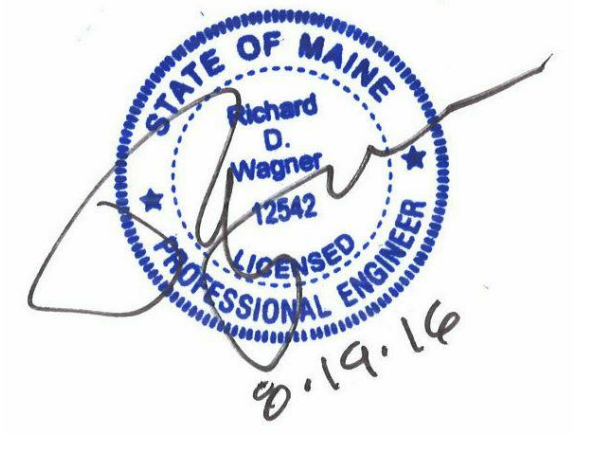

Revision	By	App'd	DD.MM.YYYY
0			08/19/2016
1			08/19/2016
2			08/03/2016
3			07/22/2016

Permit-Seal

Client/Project
IMMUCELL

Lot 11 - Second Tee Business Park
1039 Riverside Street
Portland, Maine 04103

Title
MECHANICAL DUCTWORK DETAILS

Project No.	Scale
191504176	N.T.S.

Revision	Drawing No.
0	