

Revision	By	App'd	DD.MM.YYYY
0			08/19/2016
INTERIOR FIT-OUT - ISSUED FOR CONSTRUCTION			
1			08/19/2016
PACKAGE C - INTERIOR FIT-OUT			
2			08/03/2016
PACKAGE B - SUPERSTRUCTURE & SHELL			
3			07/22/2016
PACKAGE A - FOUNDATIONS & BELOW SLAB			
4			07/22/2016
Issued			

Permit-Seal

Client/Project
IMMUCELL

Lot 11 - Second Tee Business Park
1039 Riverside Street
Portland, Maine 04103

Title
FIRST FLOOR - HEATING HOT GLYCOL PIPING PLAN


Project No.
191504176

Scale
1/4" = 1'-0"

Revision
0

Drawing No.
MP-201-C

1 FIRST FLOOR - HEATING HOT WATER PIPING PLAN
1/4" = 1'-0"

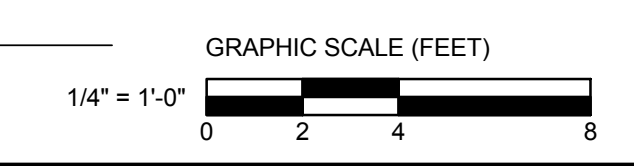

R:\Projects\191504176\191504176.dwg, imp, immu-cell, 1/18/2016, 11:58:41 AM

ORIGINAL SHEET: A-B (3/4"x4")