
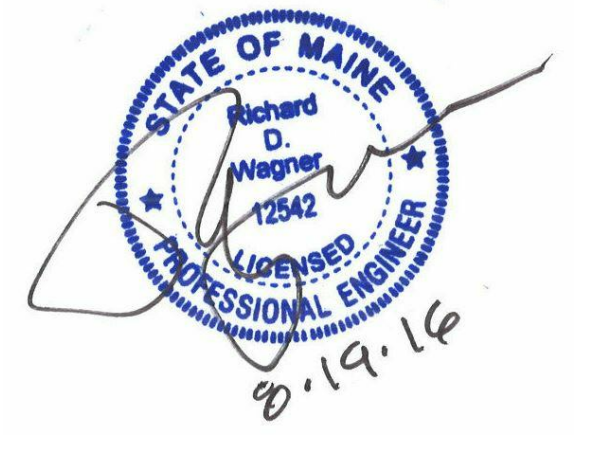


1 SECOND FLOOR - STEAM PIPING PLAN
1/4" = 1'-0"

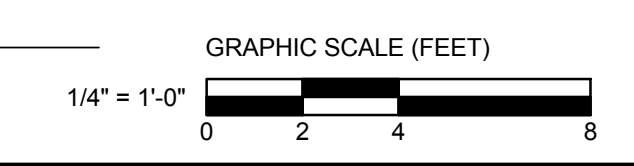

Revision	By	App'd	DD.MM.YYYY
0			08/19/2016
INTERIOR FIT-OUT - ISSUED FOR CONSTRUCTION			
PACKAGE C - INTERIOR FIT-OUT			
PACKAGE B - SUPERSTRUCTURE & SHELL			
PACKAGE A - FOUNDATIONS & BELOW SLAB			
Issued			07/22/2016

Permit-Seal

Client/Project
IMMUCELL

Lot 11 - Second Tee Business Park
1039 Riverside Street
Portland, Maine 04103

Title
SECOND FLOOR - STEAM PIPING PLAN

Project No.	Scale
191504176	1/4" = 1'-0"
Revision	Drawing No.
0	

MP-302-C

R:\Projects\191504176\191504176-02-IMP-IMMUCELL-191504176.dwg

ORIGINAL SHEET: A06 E (3/14/16)