




**1 FIRST FLOOR - CONDENSATE PIPING PLAN**  
MP-401-C 1/4" = 1'-0"

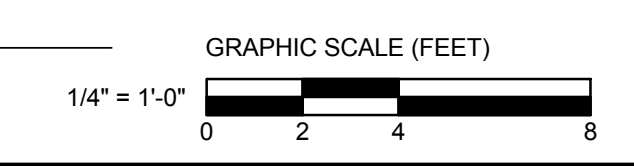

Revision	By	App'd	Date
0			08/19/2016
INTERIOR FIT-OUT - ISSUED FOR CONSTRUCTION			
<b>PACKAGE C - INTERIOR FIT-OUT</b>			
<b>PACKAGE B - SUPERSTRUCTURE &amp; SHELL</b>			
<b>PACKAGE A - FOUNDATIONS &amp; BELOW SLAB</b>			
Issued			07/22/2016

Permit-Seal

Client/Project  
IMMUCELL

Lot 11 - Second Tee Business Park  
1039 Riverside Street  
Portland, Maine 04103

Title  
FIRST FLOOR - CONDENSATE PIPING PLAN


Project No.  
191504176

Scale  
1/4" = 1'-0"

Revision  
0

Drawing No.

**MP-401-C**

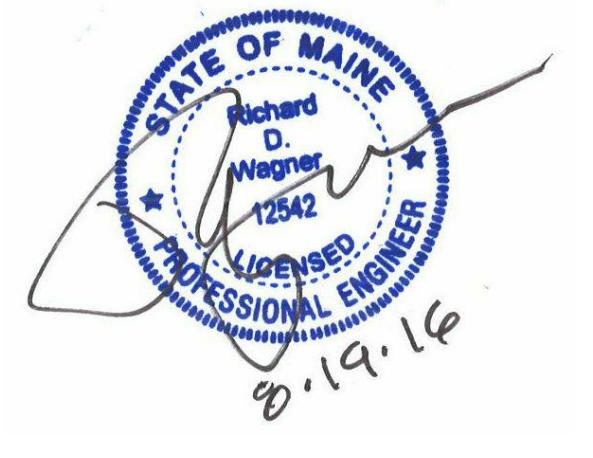

ORIGINAL SHEET: A08 (3/14/16)