


1 ROOF - MECHANICAL PIPING PLAN
 1/4" = 1'-0"

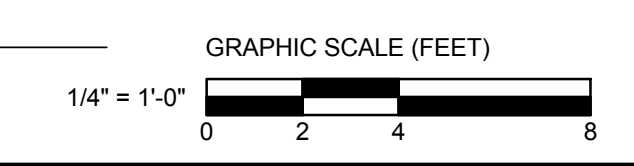

Revision	By	App'd	DD.MM.YYYY
0			08/19/2016
INTERIOR FIT-OUT - ISSUED FOR CONSTRUCTION			
PACKAGE C - INTERIOR FIT-OUT			
PACKAGE B - SUPERSTRUCTURE & SHELL			
PACKAGE A - FOUNDATIONS & BELOW SLAB			
Issued			08/19/2016
			08/05/2016
			07/22/2016

Permit-Seal

Client/Project
 IMMUCELL

Lot 11 - Second Tee Business Park
 1039 Riverside Street
 Portland, Maine 04103

Title
 ROOF - MECHANICAL PIPING PLAN

Project No.
 191504176

Scale
 1/4" = 1'-0"

Revision
 0

Drawing No.
 MP-603-C

