

1 FIRST FLOOR PLAN
 SCALE: 1/8" = 1'-0"
 2' 4' 8' 16'

GENERAL NOTES

- DRAWINGS ARE FOR TENANT FIT-UP ONLY.
- DIMENSIONS SHOWN ARE TO BUILDING LINES, COLUMN CENTERLINES, OPENING CENTERLINES, AND PARTITION FINISH FACES, OR AS OTHERWISE NOTED.

DOOR NOTES

- SEE DOOR SCHEDULE ON SHEET A3.

PLUMBING SYSTEMS NOTES

- PROVIDE PLUMBING FIXTURES AS SHOWN, COMPLETE WITH HOT AND COLD WATER SUPPLY AND WASTE PIPING.
- SUBMIT DESIGN PLANS AND SPECIFICATIONS TO THE OWNER FOR REVIEW.

MECHANICAL SYSTEMS NOTES


- PROVIDE HVAC UNITS, DUCTING, SUPPLY AND RETURN REGISTERS AS NECESSARY FOR NEW SPACE.
- SUBMIT DESIGN PLANS AND SPECIFICATIONS TO THE OWNER FOR REVIEW.

ELECTRICAL SYSTEM NOTES

- PROVIDE LIGHTING AND POWER SYSTEMS AND DATA CABLING, PER TENANT REQUIREMENTS.
- SUBMIT DESIGN PLANS TO THE OWNER FOR REVIEW.

FIRE PROTECTION SYSTEMS NOTES

- PROVIDE EMERGENCY LIGHTING AND EXIT SIGNS.
- PROVIDE ONE 5 LB A,B,C FIRE EXTINGUISHER AT EVERY EXIT.

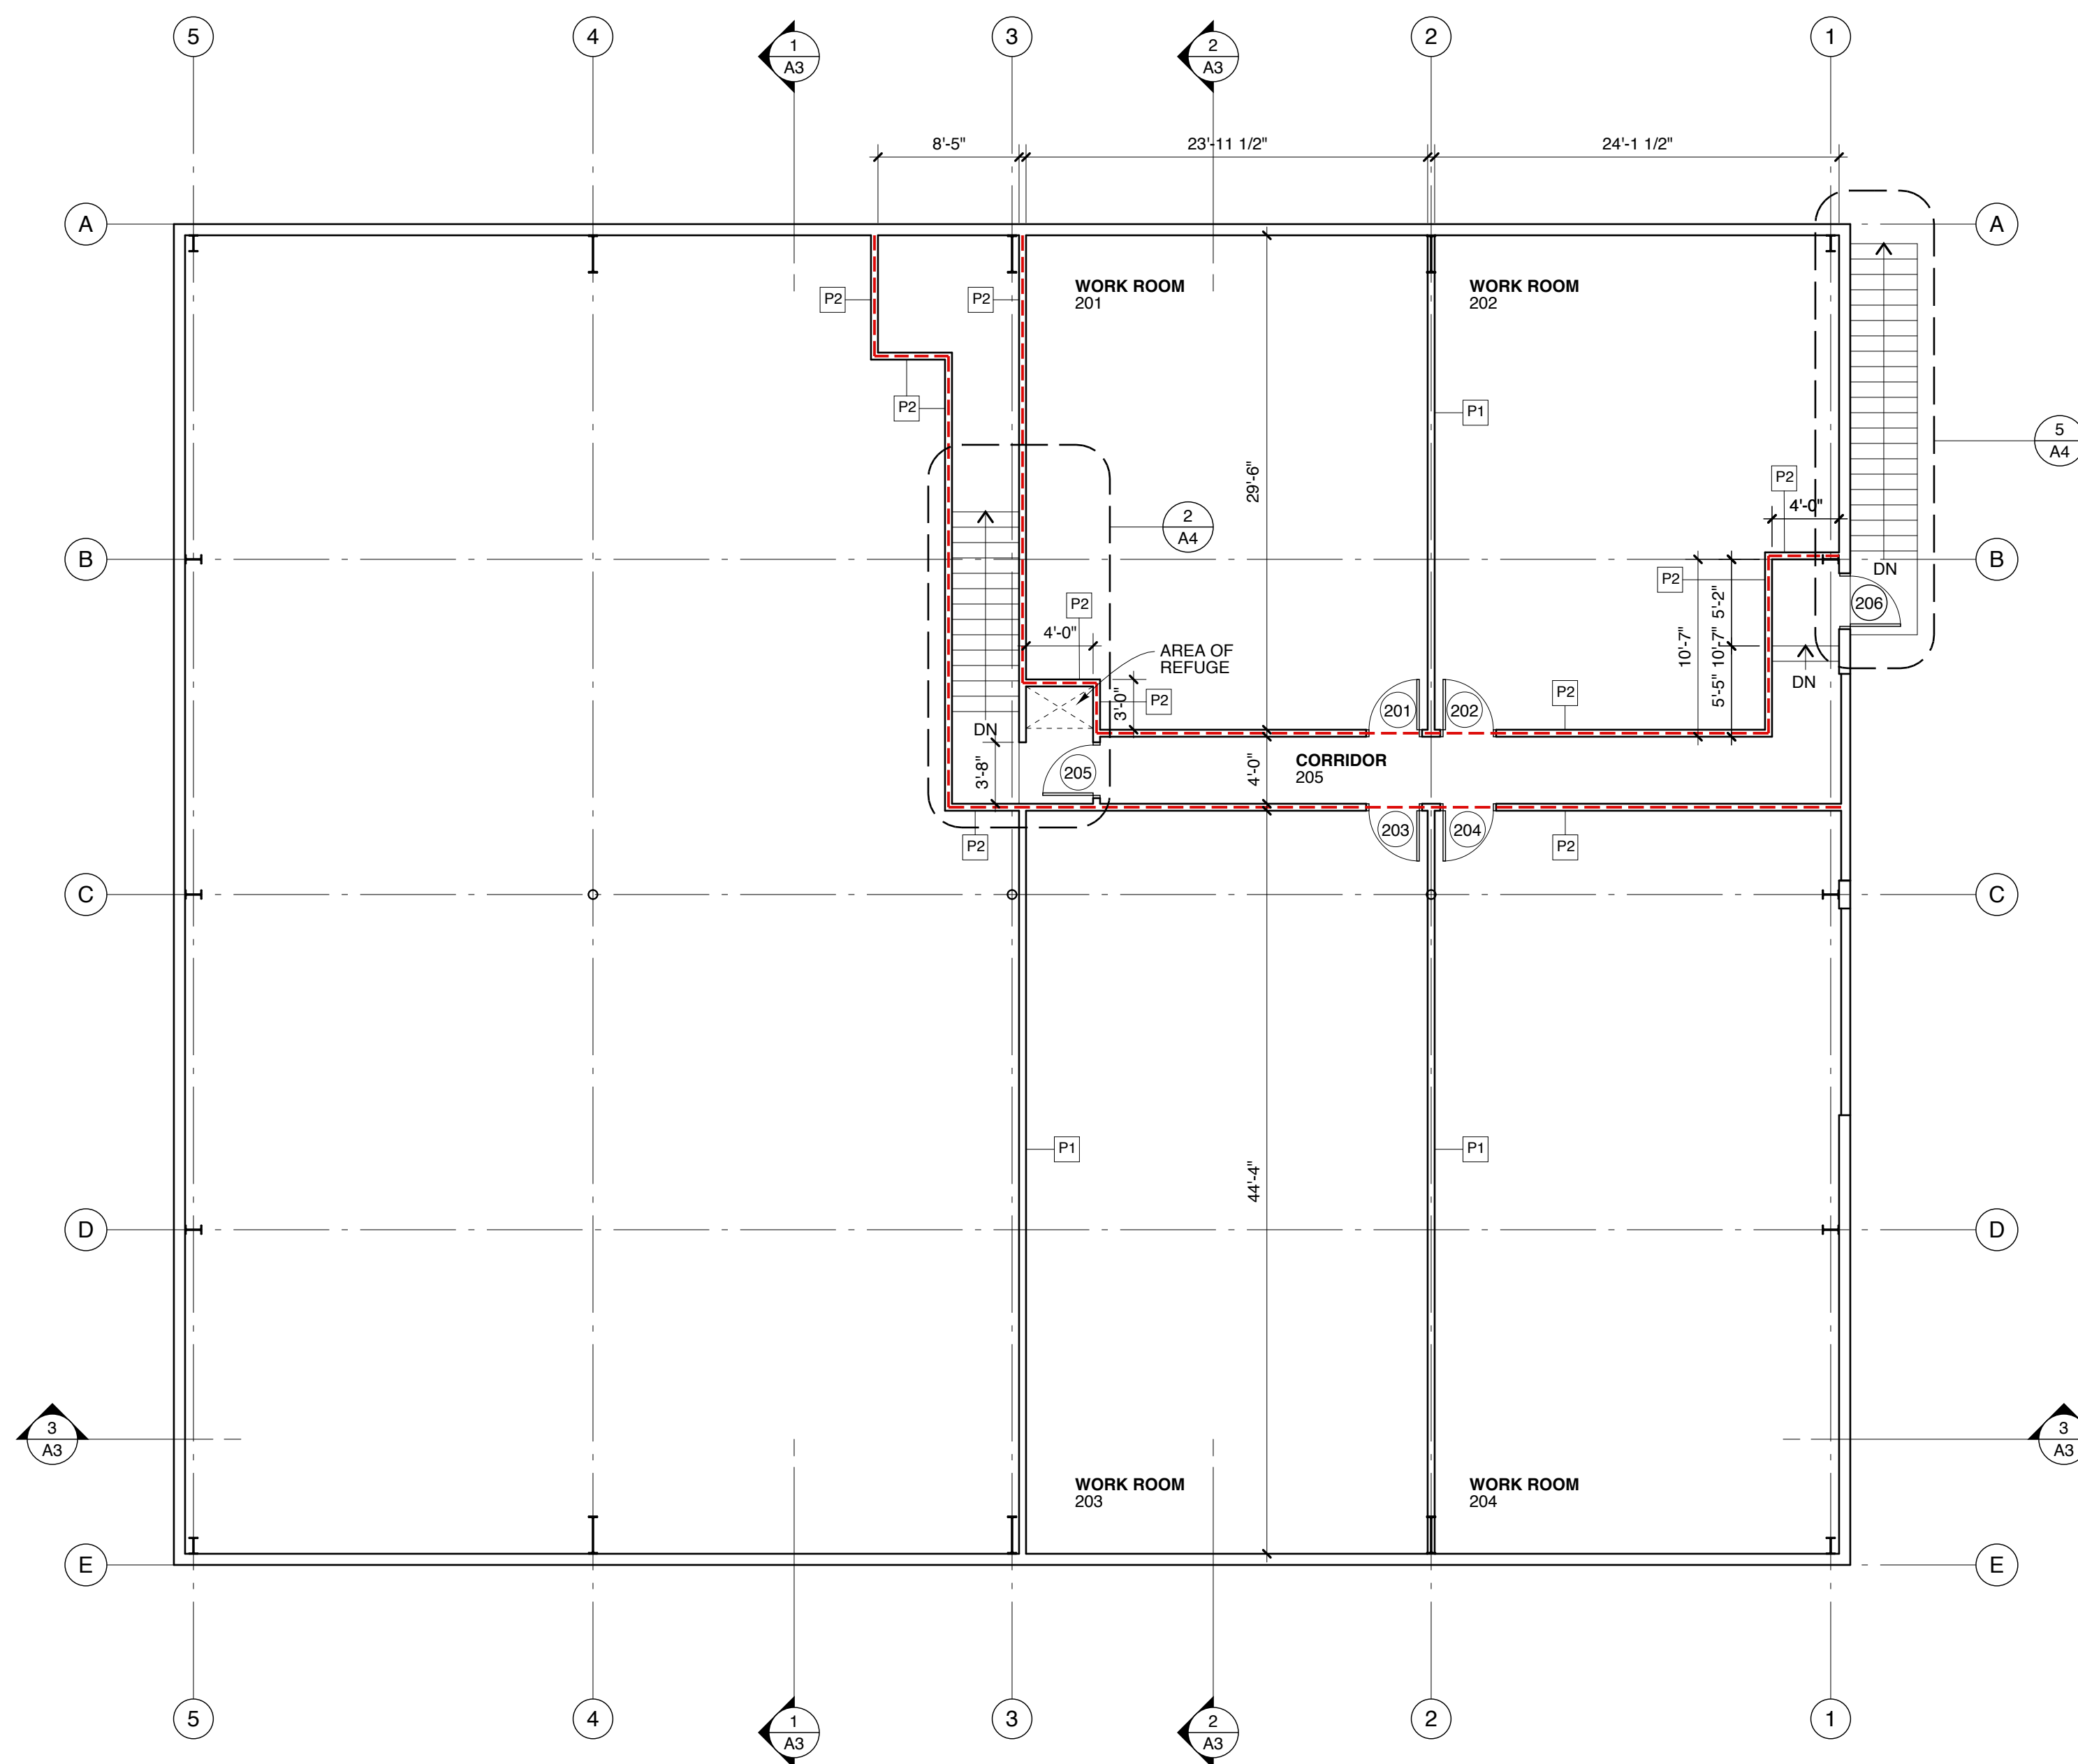

2 SECOND FLOOR PLAN
 SCALE: 1/8" = 1'-0"
 2' 4' 8' 16'

PARTITIONS/WALLS KEY

1-HOUR PARTITION

**PARTITION TYPES - SEE DETAIL SECTIONS ON SHEET A5
 NOTE - SELECT STUD SPACING AND GAUGE FROM MANUFACTURERS' SPAN TABLES.**

- P1 3 5/8" STEEL STUD FRAMING
5/8" GYPSUM BOARD BOTH SIDES
PARTITION HEAD UP TO ROOF OR FLOOR STRUCTURE ABOVE
- P2 1-HOUR FIRE RESISTANCE RATED ASSEMBLY
3 5/8" STEEL STUD FRAMING
5/8" FIRE CODE GYPSUM BOARD BOTH SIDES
PARTITION HEAD UP TO ROOF OR FLOOR STRUCTURE ABOVE
- P3 LOAD BEARING - SEE STRUCTURAL FOR MORE DETAIL
3 5/8" STEEL STUD FRAMING
5/8" GYPSUM BOARD BOTH SIDES
PARTITION HEAD SUPPORTING FLOOR STRUCTURE ABOVE
- P4 1-HOUR FIRE RESISTANCE RATED ASSEMBLY
LOAD BEARING - SEE STRUCTURAL FOR MORE DETAIL
3 5/8" STEEL STUD FRAMING
5/8" GYPSUM BOARD BOTH SIDES
PARTITION HEAD SUPPORTING FLOOR STRUCTURE ABOVE
- P5 3 5/8" STEEL STUD FRAMING
5/8" GYPSUM BOARD BOTH SIDES
PARTITION HEAD UP TO CEILING STRUCTURE
- P6 1-HOUR FIRE RESISTANCE RATED ASSEMBLY
3 5/8" STEEL STUD FRAMING
5/8" GYPSUM BOARD BOTH SIDES
PARTITION HEAD UP TO CEILING STRUCTURE
- P7 6" STEEL STUD FRAMING
5/8" GYPSUM BOARD BOTH SIDES
PARTITION HEAD UP TO ROOF OR FLOOR STRUCTURE ABOVE
- P8 FURRED WALL ASSEMBLY AGAINST EXTERIOR WALL
LOAD BEARING - SEE STRUCTURAL FOR MORE DETAIL
3 5/8" STEEL STUD FRAMING
5/8" GYPSUM BOARD BOTH SIDES
PARTITION HEAD SUPPORTING FLOOR STRUCTURE ABOVE

