

Minor Interior Renovations at 196 Allen Avenue

CASCO BAY HIGH SCHOOL

CONSTRUCTION DOCUMENTS - APRIL 18, 2014

PDT Project No.
14036



OWNER: PORTLAND PUBLIC SCHOOLS
196 ALLEN AVENUE, PORTLAND, ME

ARCHITECT:




49 DARTMOUTH STREET
PORTLAND, ME 04101
207-775-1059
www.pdtarchs.com

CONSULTANTS:


STRUCTURAL, MECHANICAL, ELECTRICAL,
AND PLUMBING
Allied Engineering
Portland, ME

SPECIFICATIONS
Lowell Specifications
Freeport, ME

COST ESTIMATING
Conestco
Raymond, ME

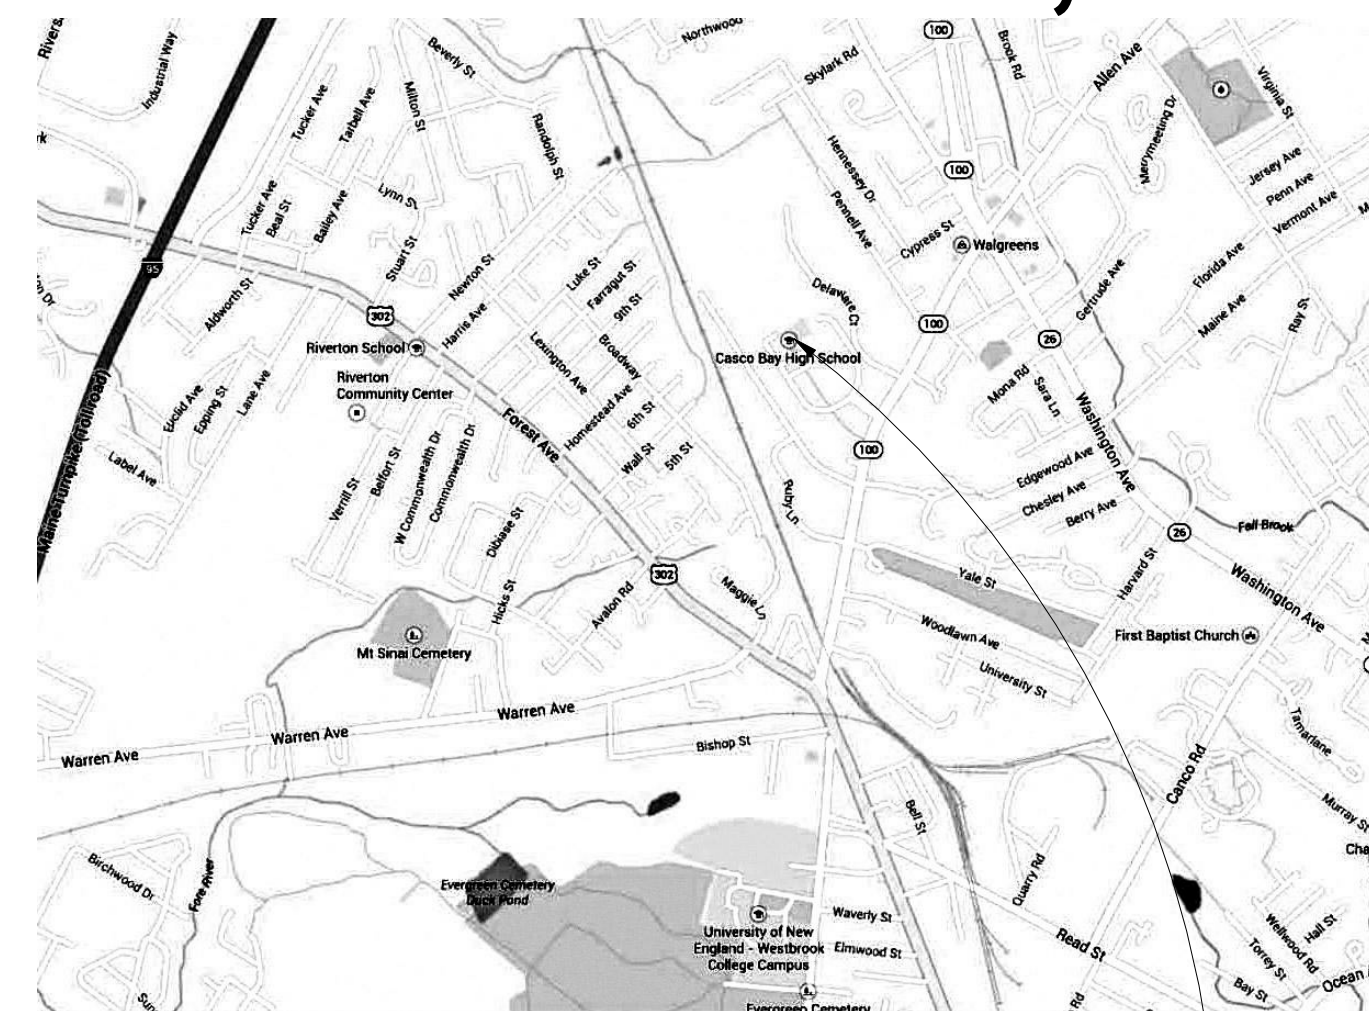

PROJECT LOCATION MAP

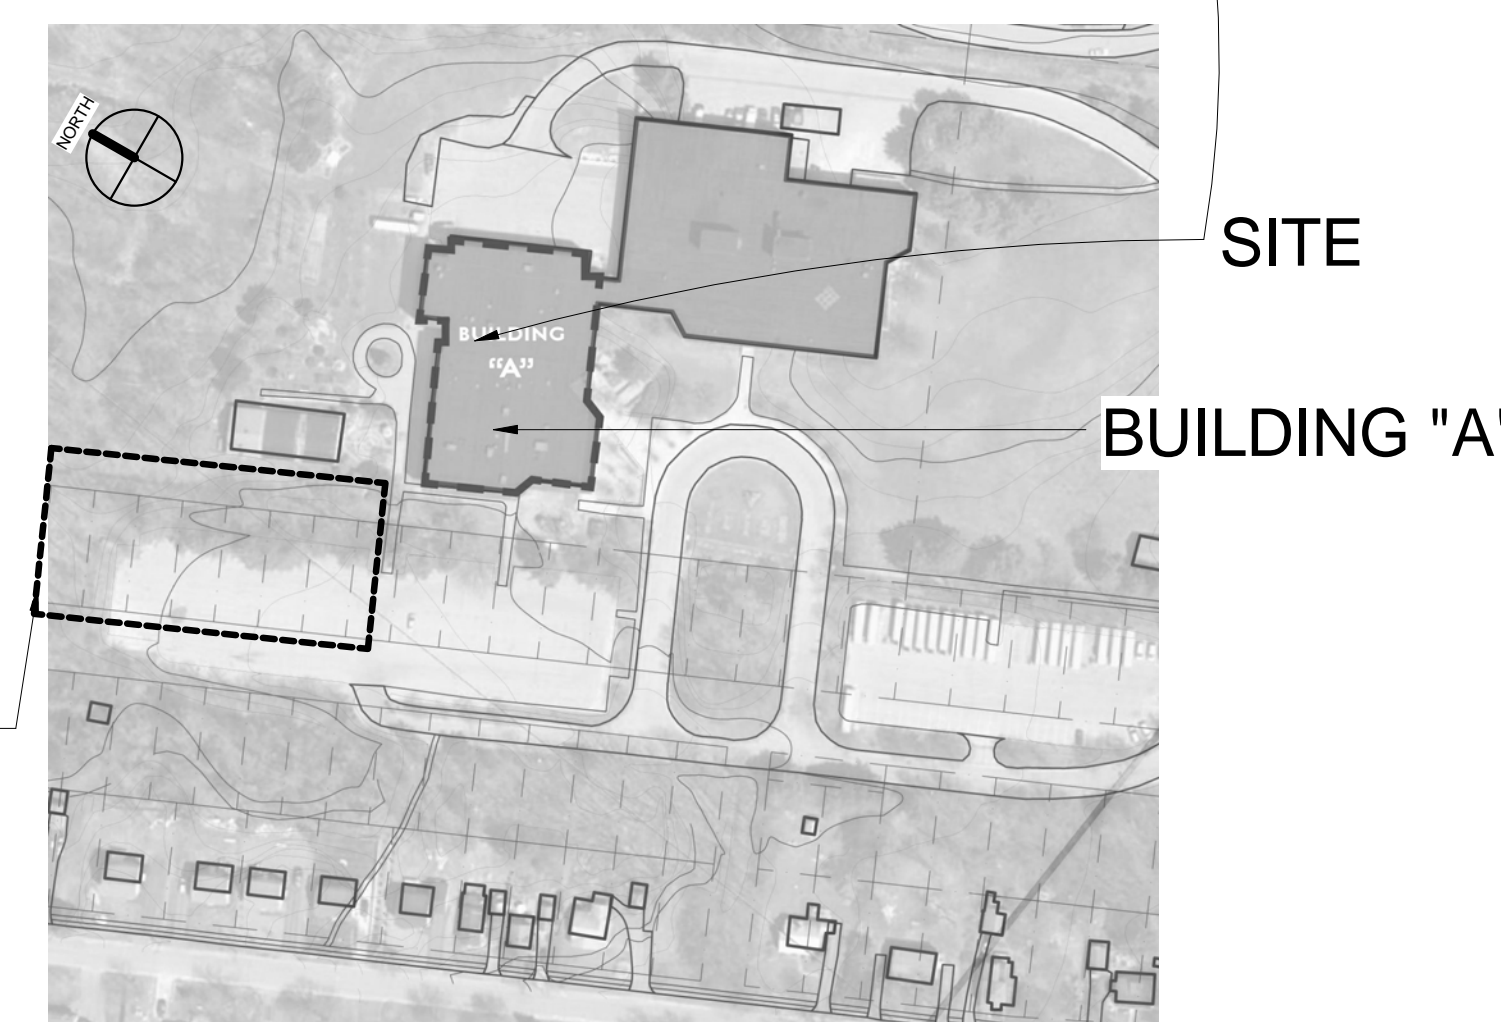

SITE PLAN

EXTENTS OF PARKING,
DELIVERIES, WASTE
RECEPTACLES, LAY-DOWN AREA

NOTE: CONTRACTOR TO
PROVIDE SAFETY
CONSTRUCTION FENCING

DRAWING LIST	
SHEET NUMBER	SHEET NAME

Architectural	
A000	SHEET INDEX
A001	GENERAL NOTES & BUILDING SYSTEMS
A003	THIRD FLOOR CODE PLAN
AD102/A102	THIRD FLOOR DEMO PLAN AND PROPOSED FLOOR PLAN
A103	REFLECTED CEILING PLAN
A201	INTERIOR ELEVATIONS
A500	DETAILS
A600	SCHEDULES

Mechanical	
MH-100	MECHANICAL DEMOLITION PLAN AND MECHANICAL PLAN
MH-500	MECHANICAL SCHEDULES, DETAILS AND NOTES

Plumbing	
PL-000	HVAC & PLUMBING ABBREVIATIONS AND LEGENDS
PL-100	PLUMBING PLANS
PL-500	PLUMBING SCHEDULES, DETAILS AND NOTES

Electrical	
E000	ELECTRICAL LEGENDS, ABBREVIATIONS, AND GENERAL NOTES
E100	THIRD FLOOR DEMOLITION AND NEW WORK PLANS
E600	SCHEDULES

REV.	DESCRIPTION	DATE
1	REVISION #1	APRIL 25, 2014
0	ISSUED FOR CONSTRUCTION	APRIL 18, 2014