




3/16/2017 9:10 PM T:\02 PROJECTS - MAINE\1101-4200\11000 PANS FIRE ALARM UPGRADES\2 DESIGN\DWGS\BUILDINGS FIRE ALARM UPGRADES\SHEETS\FA401 FIRE ALARM MEZZANINE BUILDING B PLANS.DWG STEPHANE LAPLANT

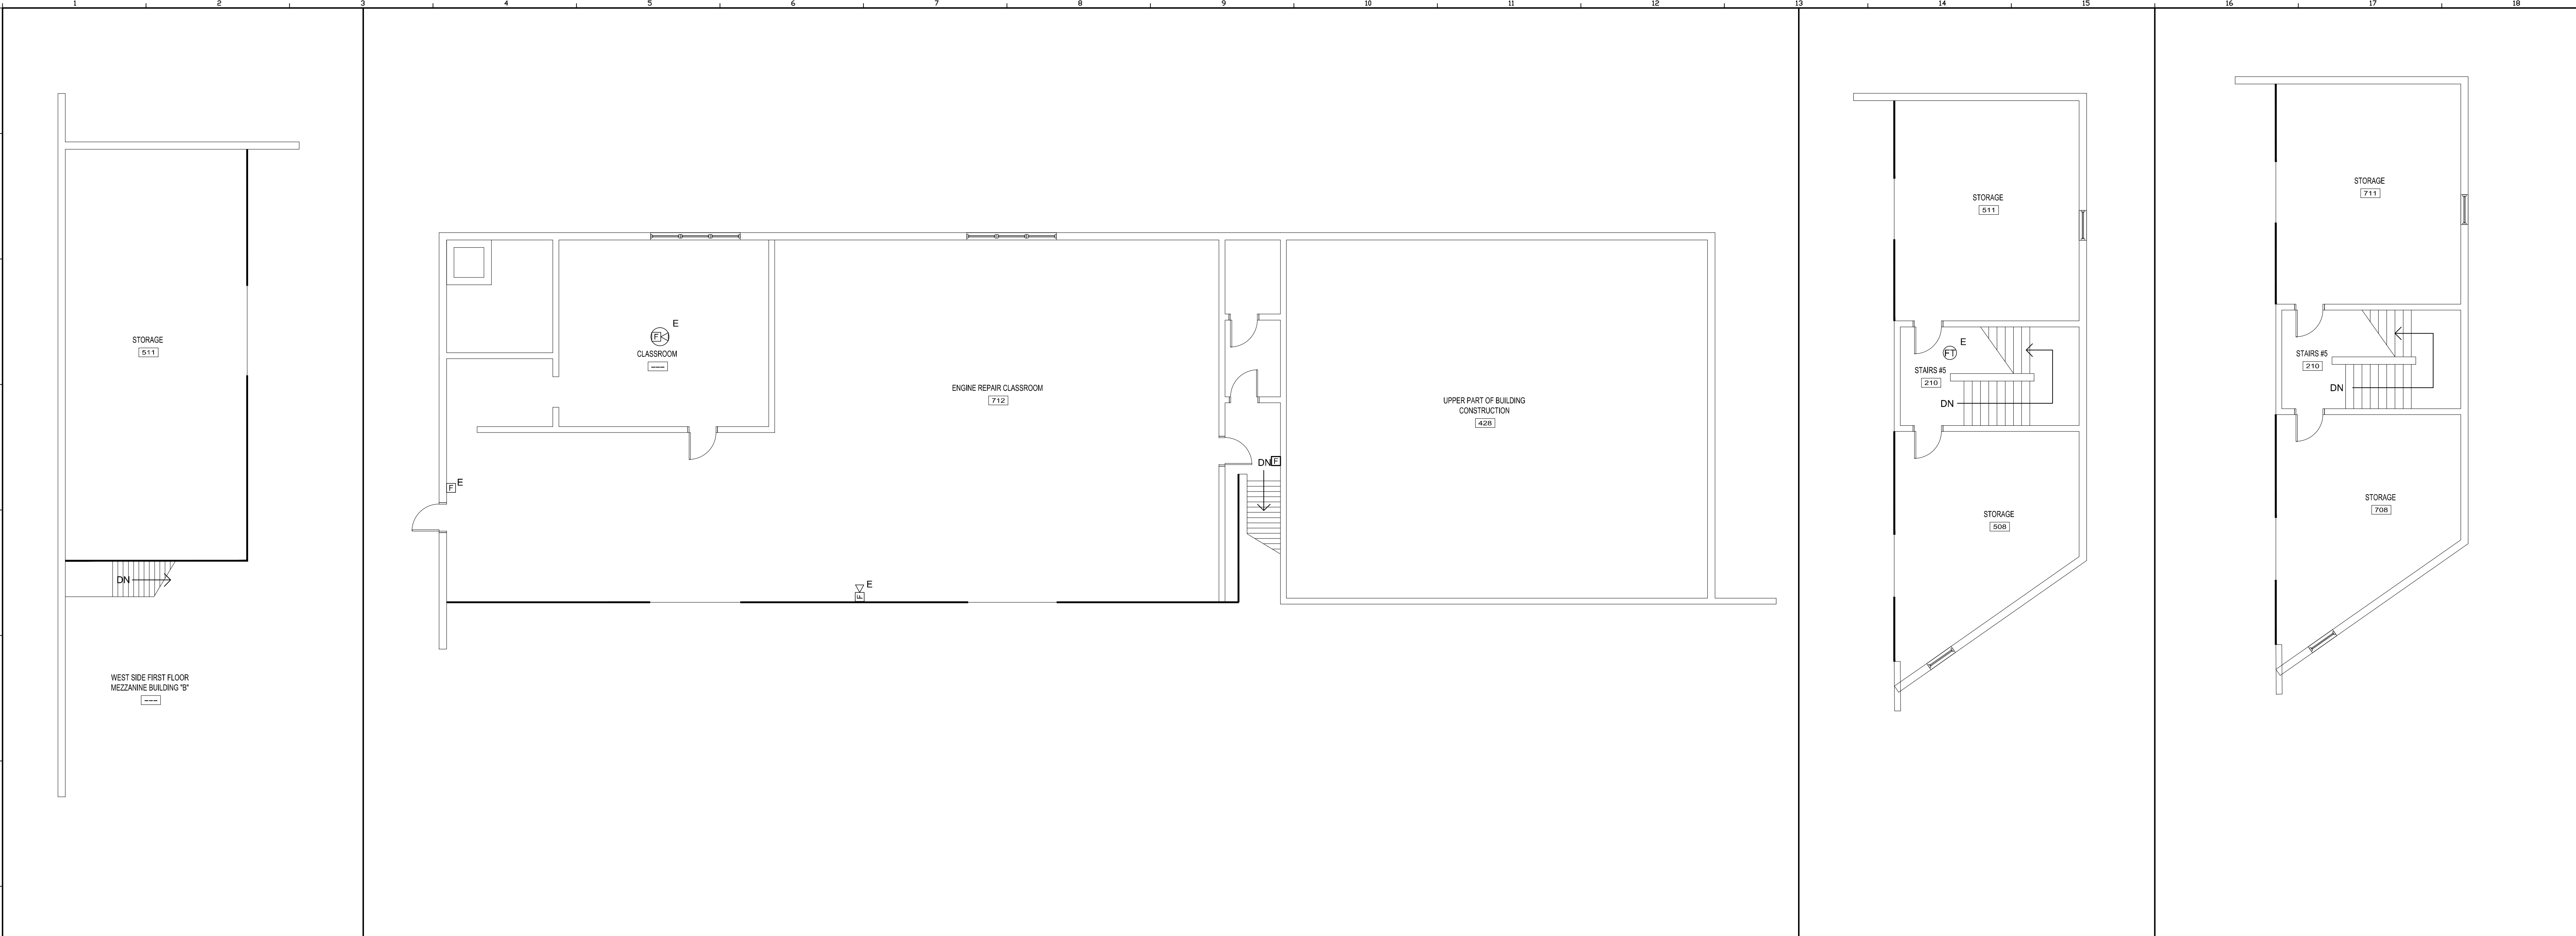

J1	FIRST FLOOR MEZZ WEST	J3	SECOND FLOOR MEZZANINE NORTH	J13	FIRST FLOOR MEZZ EAST	J16	SECOND FLOOR MEZZ EAST
1/8" = 1'-0"	--	1/8" = 1'-0"	--	1/8" = 1'-0"	--	1/8" = 1'-0"	--

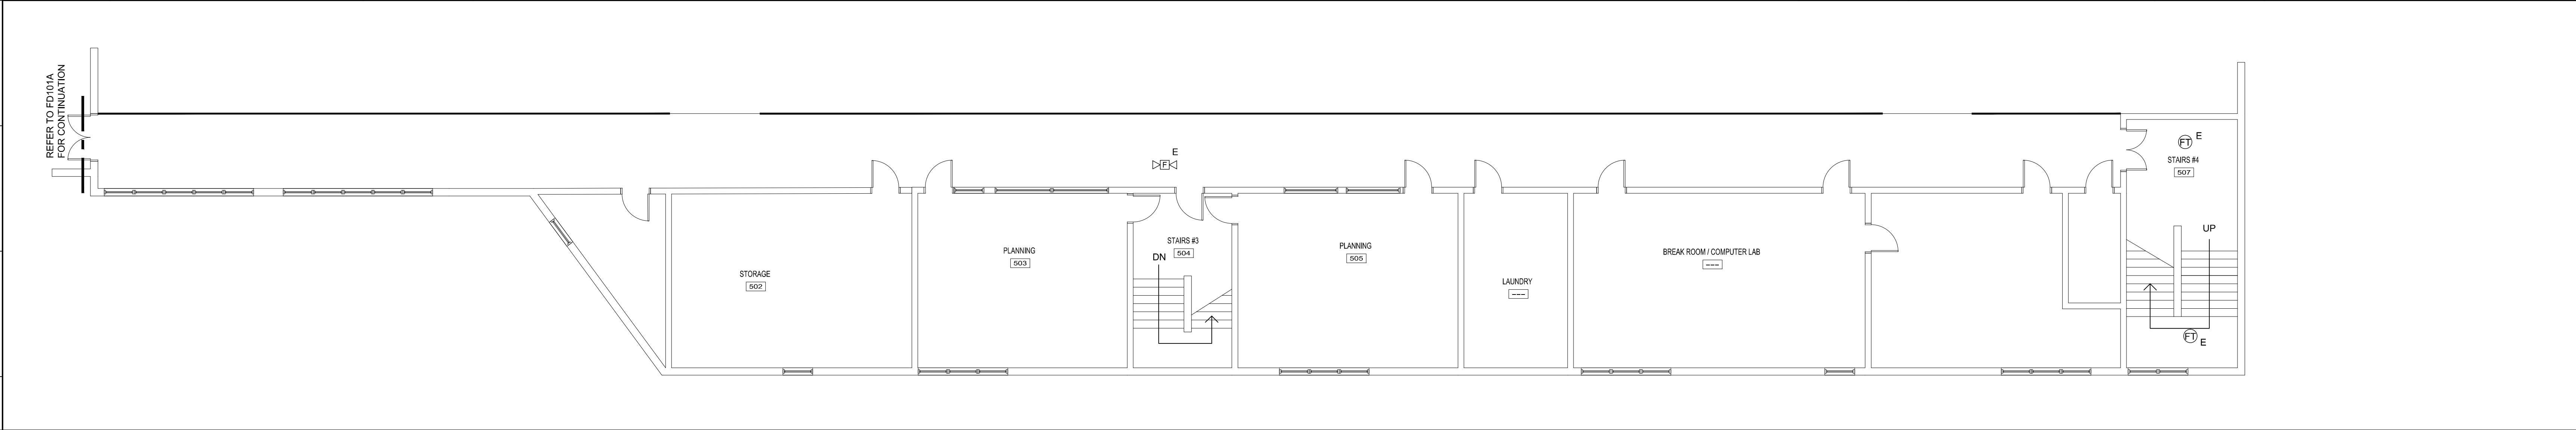


E1	FIRST FLOOR MEZZANINE SOUTH DEMO PLAN
1/8" = 1'-0"	--

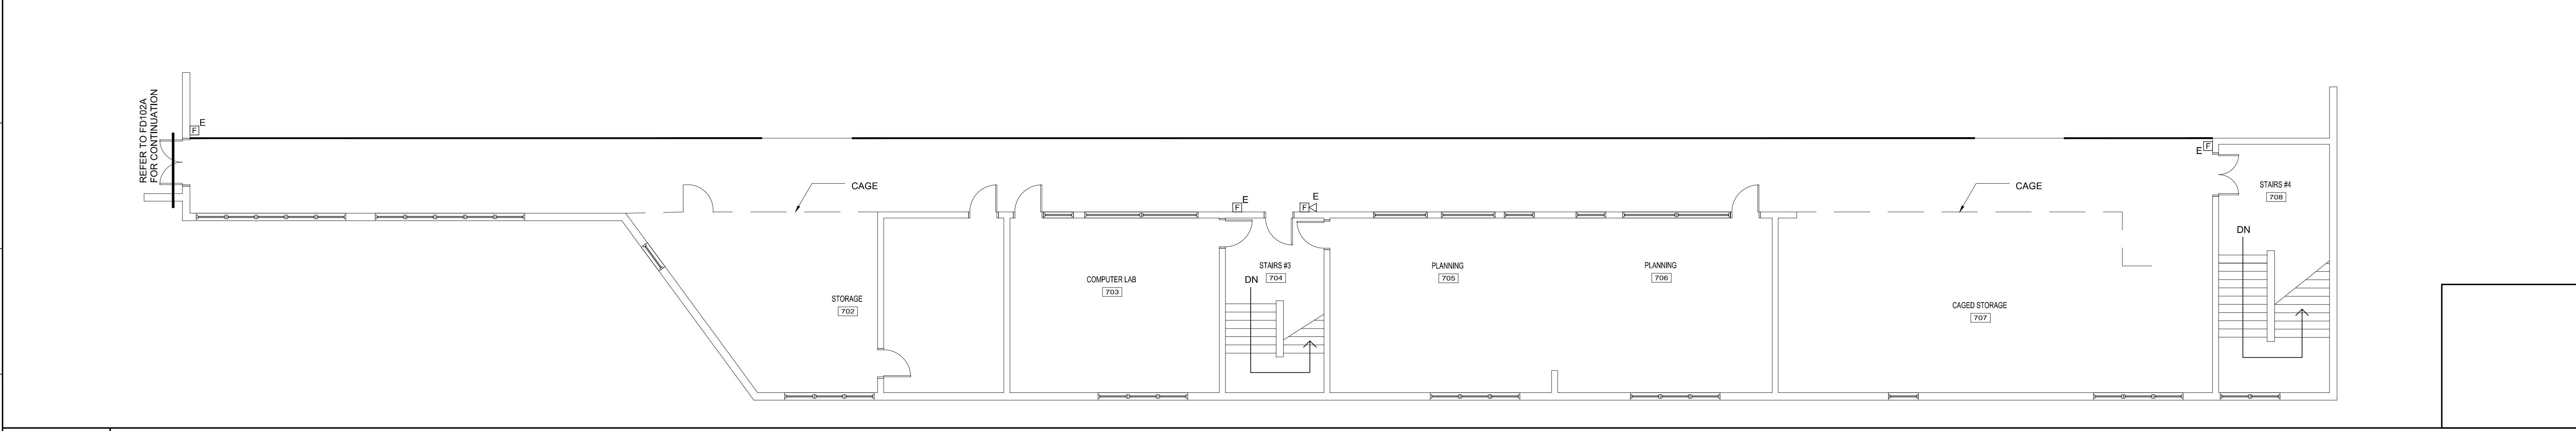

A1	FIRE ALARM MEZZANINE BUILDING B PLANS
1/8" = 1'-0"	--


NOTE:
 EXISTING SPEAKERS, BEACONS + OTHER FIRE ALARM NOTIFICATION DEVICES TO REMAIN. CONNECT TO BUILDING "A" SIGNAL LINE CIRCUIT. EXISTING INITIATING DEVICES TO REMAIN. INSTALL ZONE MODULE(S) AT FACE TO MONITOR DEVICES ON EXISTING ZONE(S). NEW DEVICES SHALL BE ADDRESSABLE.

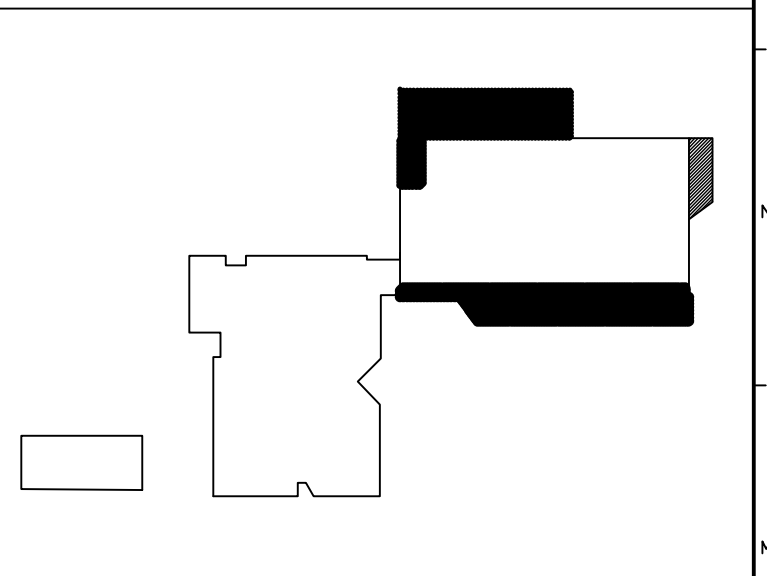

KEY PLAN

- LEGEND:**
- E EXISTING TO REMAIN
 - FR EXISTING RELOCATED
 - NR NEW TO REPLACE EXISTING IN EXISTING LOCATION
 - R EXISTING TO BE REMOVED
 - RR REMOVE & RELOCATE EXISTING
 - ☒ FIRE ALARM HORN / LIGHT
 - ▽ MULTI-CANDELA STROBE
 - ☒ MULTI-CANDELA HORN/STROBE
 - ☒ CEILING MOUNTED MULTI-CANDELA HORN/STROBE
 - ⊙ FIRE ALARM SYSTEM CEILING MOUNTED HEAT DETECTOR - 'EL' FOR ELEVATOR SHUNT TRIP
 - ⊙ FIRE ALARM SYSTEM CEILING MOUNTED SMOKE DETECTOR - 'EL' FOR ELEVATOR RECALL
 - ☒ WALL MOUNTED FIRE ALARM SYSTEM MANUAL PULL STATION
 - ☒ KNOX BOX
 - ☒ JUNCTION BOX
 - ☒ DOOR HOLD-OPEN DEVICE CONNECTION
 - ⊙ FIRE ALARM SYSTEM/SPRINKLER SYSTEM PRESSURE SWITCH
 - ⊙ FIRE ALARM SYSTEM/SPRINKLER SYSTEM FLOW SWITCH
 - ⊙ FIRE ALARM SYSTEM/SPRINKLER SYSTEM TAMPER SWITCH
 - ⊙ FIRE ALARM SYSTEM DUCT MOUNTED SMOKE DETECTOR
 - ☒ FIRE ALARM SYSTEM CONTROL PANEL
 - ☒ FIRE ALARM ANNUNCIATOR
 - ☒ GAS SHUT-OFF
 - ☒ RADIO TRANSMITTER BOX
 - ☒ MONITOR MODULE
 - ☒ TEST STATION
 - ☒ RELAY MODULE
 - ⊙ ANSUL GAS TANK

REV.	DESCRIPTION	DATE
0	ISSUE FOR BID	03.14.17

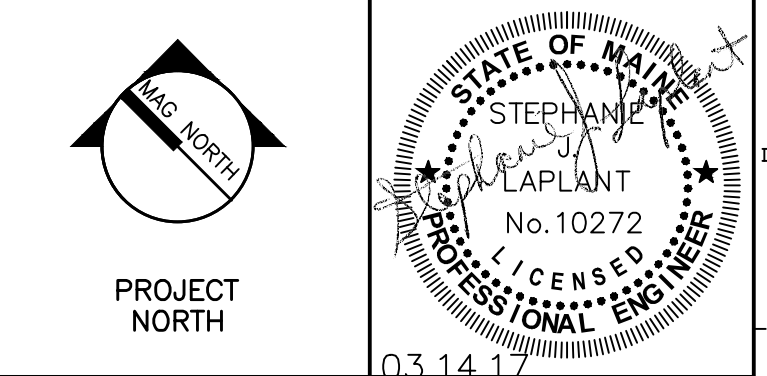

WBRC
 ARCHITECTS • ENGINEERS
 WWW.WBRC.AE.COM
 BANGOR, MAINE 207-647-4511
 PORTLAND, MAINE 207-628-4511
 SUWANEE, FLORIDA 941-656-0075

PORTLAND ARTS AND TECHNICAL HIGH SCHOOL FIRE ALARM UPGRADES
 PORTLAND, ME

FIRE ALARM MEZZANINE BUILDING B PLANS

SHEET TITLE:	FIRE ALARM MEZZANINE BUILDING B PLANS
WBRC CAD FILE:	4145.00 - FA401
PROJECT No.:	4145.00 GRAPHIC SCALE: 0"
SCALE:	AS NOTED
PROJECT MANAGER:	SJL
DRAWN BY:	DVS
CHECKED BY:	SJL
SHEET No.:	FA401