


NOTE:
THIS DRAWING IS PROVIDED FOR INFORMATIONAL PURPOSES ONLY.
IF USED FOR CONSTRUCTION THE CONTRACTOR ASSUMES ALL RESPONSIBILITY
FOR LOCAL CODE COMPLIANCE.
ALL DRAWINGS, PLANS, SKETCHES ETC. ARE PROVIDED TO OUR
CLIENTS BASED UPON INFORMATION PROVIDED BY THE CLIENT.
AND DRAWN IN ACCORDANCE WITH COMMON BUILDING PRACTICES
AND LOCAL CODES. NONE OF THE EMPLOYEES OF FMC CADD
SERVICES, INC. ARE REGISTERED ARCHITECTS, ENGINEERS OR LAND
SURVEYORS. ALL DIMENSIONS AND SPECIFICATIONS SHOULD BE VERIFIED
BY CLIENT AND/OR CONTRACTOR BEFORE ACTUAL CONSTRUCTION.
DESIGN AND/OR CONSTRUCTION. FMC CADD DRAFTING SERVICES, INC. WILL BE HELD HARMLESS
AND/OR REVISIONS MADE TO PLANS BY CLIENT AND/OR CONTRACTOR.

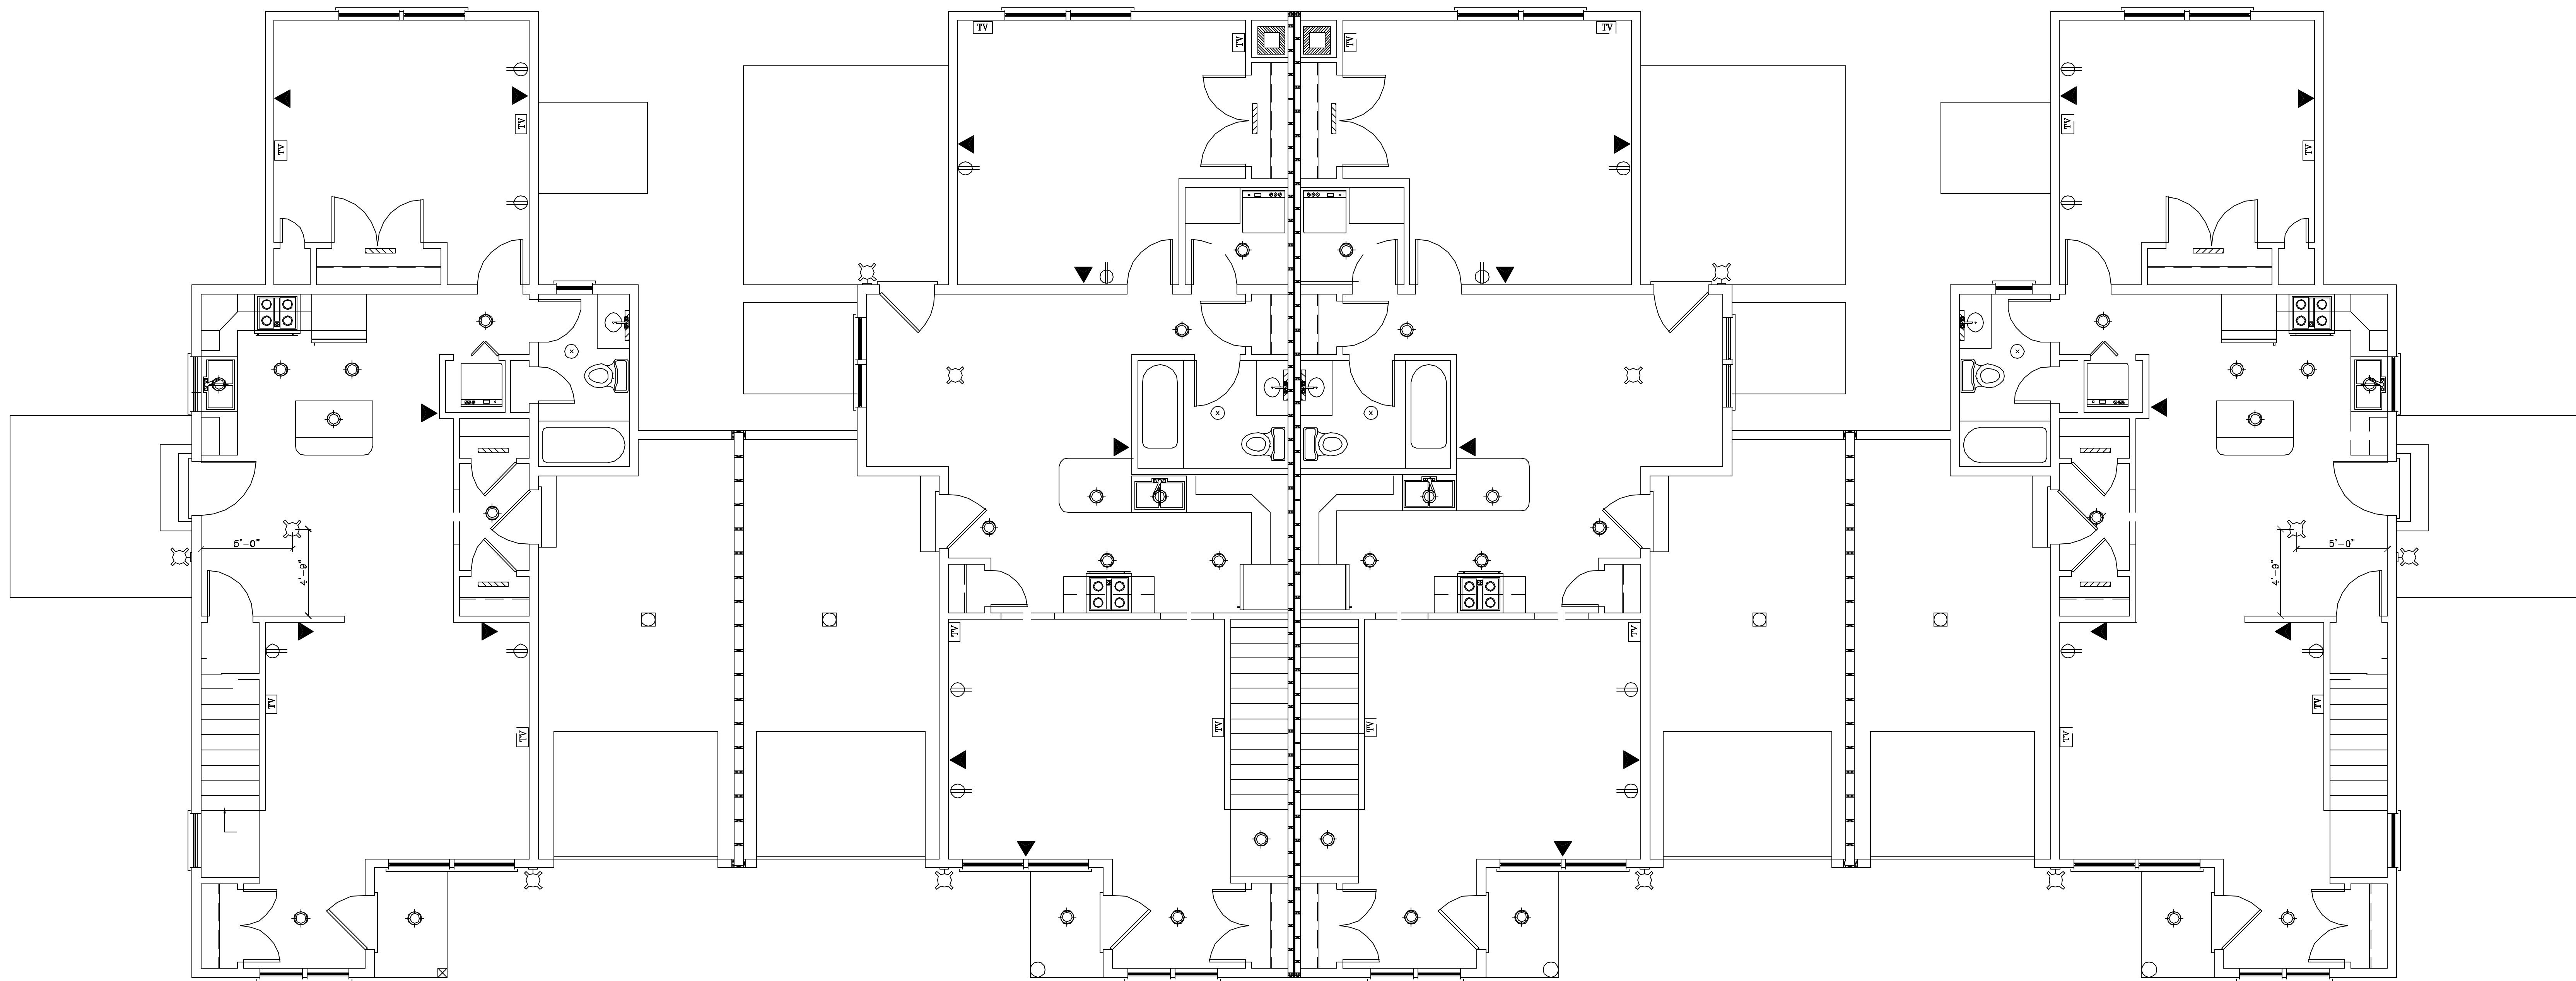

FIRST FLOOR ELECTRICAL PLAN
SCALE: 1/4" = 1'-0"

ELECTRICAL LEGEND:	
	PHONE
	OUTLET
	CABLE TV
	WALL-MTD. LIGHT FIXTURE PER CONT.
	RECESSED LIGHT
	GARAGE CEILING LIGHT
	FLUORESCENT
	LIGHT/FAN UNIT
	OVERHEAD LIGHT FIXTURE PER CONT.

A.L.C. DEVELOPMENT
258 BLACK POINT ROAD
SCARBOROUGH, ME. 04074
PHONE: (207) 883-1992

REVISIONS	
CODE:	BOCA 1999
PORTLAND ME.	
DATE:	1/22/02
SCALE:	1/4"=1'-0"
DRAWN:	FMC/R
FILE:	99-0308A
SHEET:	A6

FIRST FLOOR ELECTRICAL PLAN
SMALL CONDOMINIUM
WASHINGTON CROSSING