


McDonald Maziarz Residence
60 Cypress Street
Portland Maine

Plumbing Plan
Scale 1/4" = 1'
BCW 5/31/05

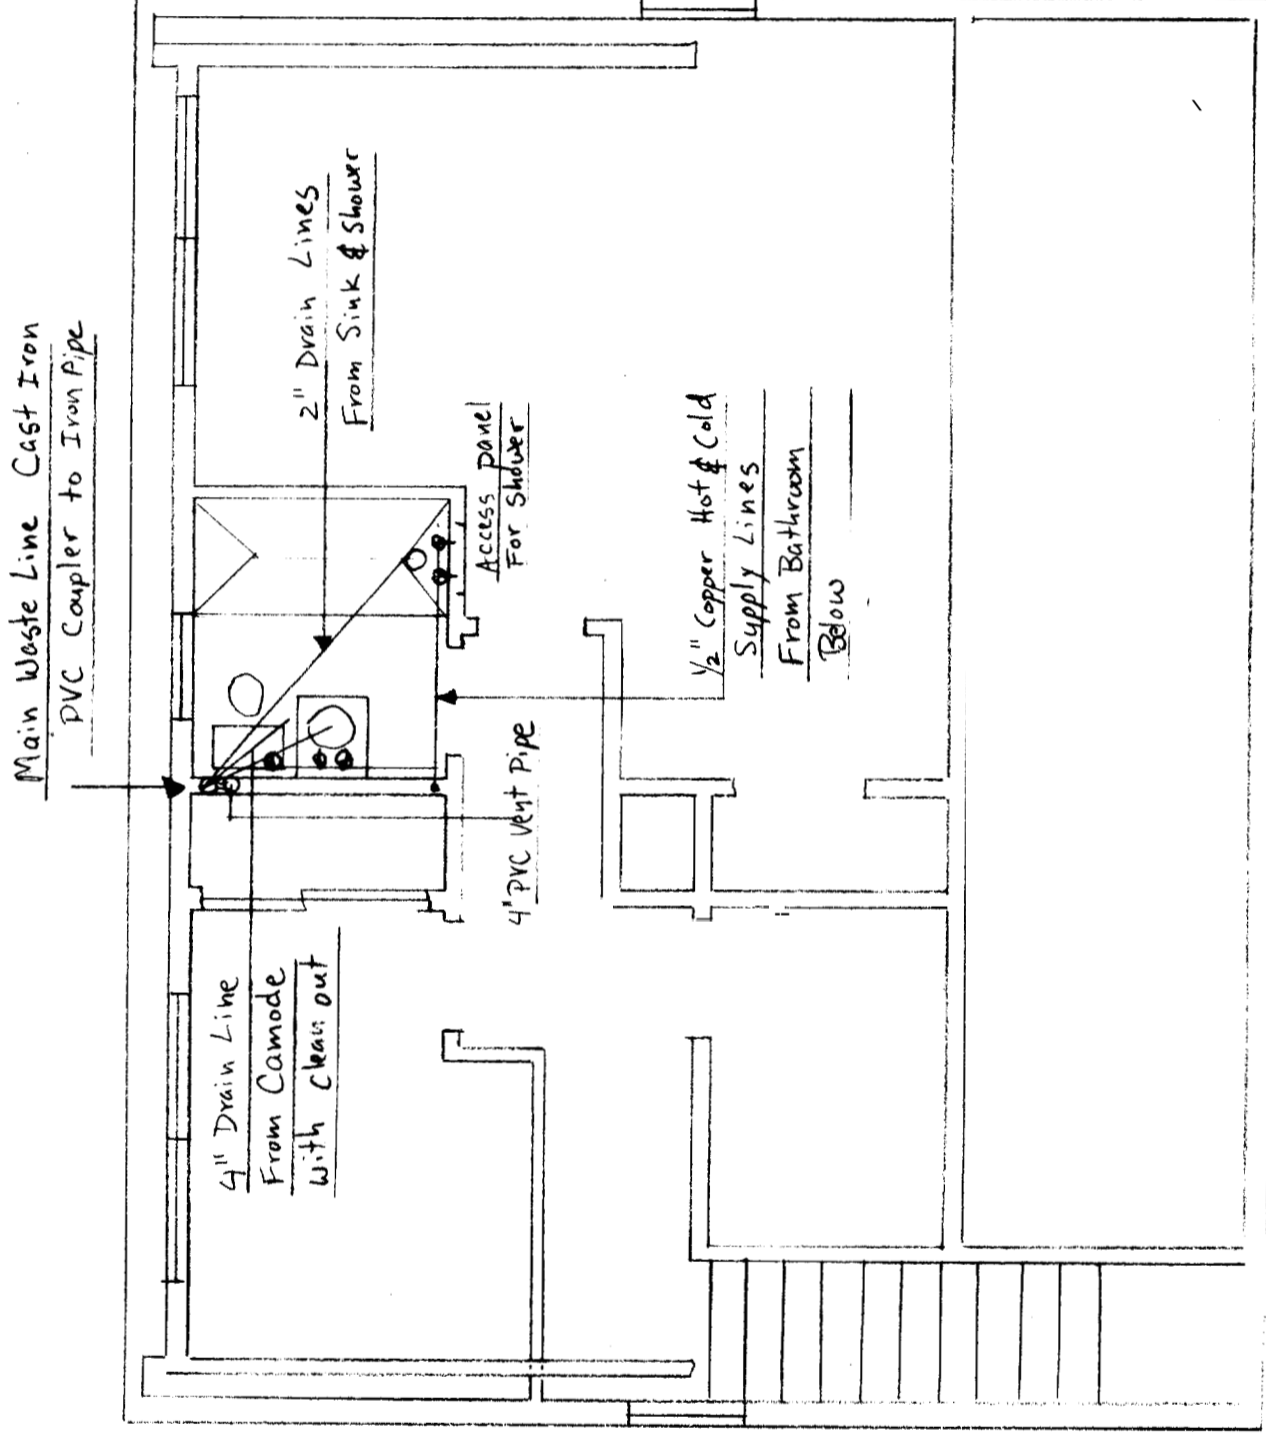

Lines to be run
through wall and
Floor System

Note:
Plumbing Systems
to be installed
By Home Owner

W