


DRAWINGS/SPECIFICATIONS BY:
 WALGREENS'
 LANDLORD'S CONSULTANT
 ALL CONSTRUCTION WORK, UNLESS NOTED OTHERWISE, BY:
 WALGREENS' CONTRACTOR
 LANDLORD'S CONTRACTOR (TURNKEY CONSTRUCTION)

STORE	BUILDING
NEW <input checked="" type="checkbox"/>	NEW <input checked="" type="checkbox"/>
REMODELING <input type="checkbox"/>	EXISTING <input type="checkbox"/>
RELOCATION <input type="checkbox"/>	NEW SHELL ONLY <input type="checkbox"/>
OTHERS <input type="checkbox"/>	


SEE SHEET FP1.2
 FOR FIRE ALARM SYSTEM

**EMERGENCY ELECTRIC SERVICE -
 WALL SECTION AT SLEEVE IN ELECTRIC ROOM**

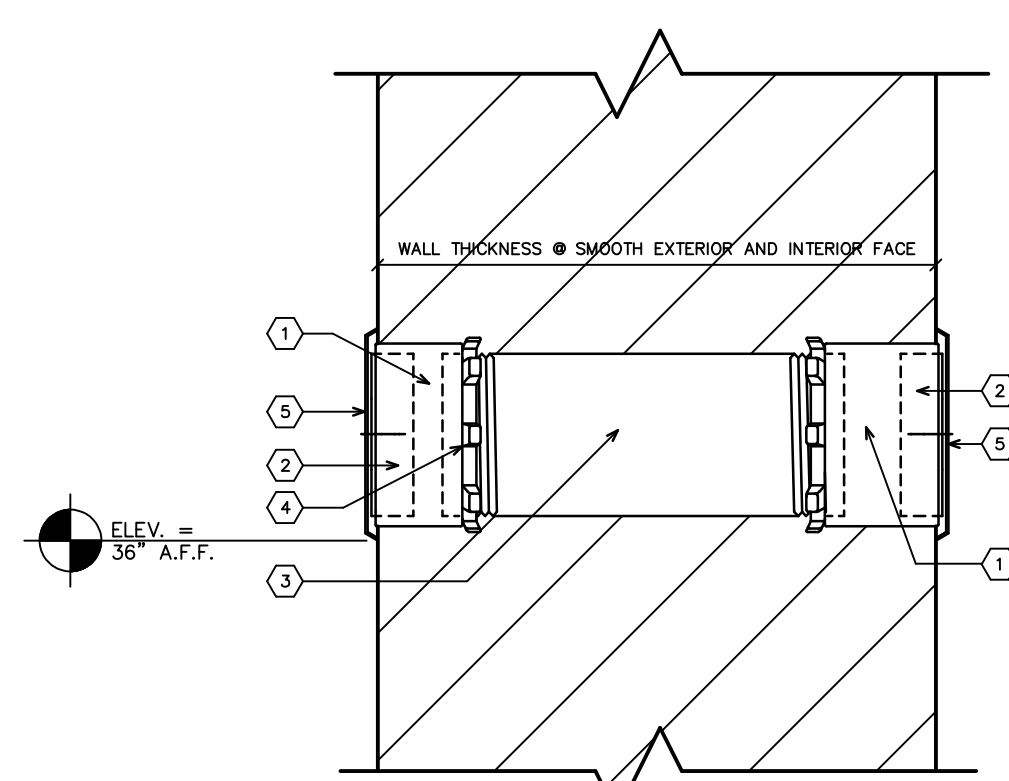


**WALL SECTION AT SLEEVE IN
 ELECTRICAL EQUIPMENT ROOM**
 N.T.S. (SEE SPARE CONDUIT NOTE 3)

- KEYED NOTES**
- 1 FEMALE THREADED COUPLING "EXTENSION" AS REQUIRED TO FINISHED SURFACES TO RECEIVE THREADED PLUG.
 - 2 PVC PLUG. INSTALL W/SILICONE SEALANT ON THREADS (TO BE REMOVED AT TIME OF ELEG WIRE RUN).
 - 3 4" GALVANIZED THREADED SLEEVE TO RECEIVE "STAR" NUTS AND COUPLING "EXTENSIONS" TO FINISHED SURFACES.
 - 4 "STAR" LOCKING NUT. GROUT SOLID IN PLACE.
 - 5 METAL COVER PLATE.
 - 6 5/8" GALVANIZED EYEBOLT THROUGH WALL. STEEL WASHER (APPROX. 3-3/4" O.D. X .656" I.D. X .090" THICK OR GREATER). SECURED WITH NUT. LOCATE ADJACENT TO SLEEVE.
 - 7 CMU FULLY GROUTED W/ VERTICAL REBAR.

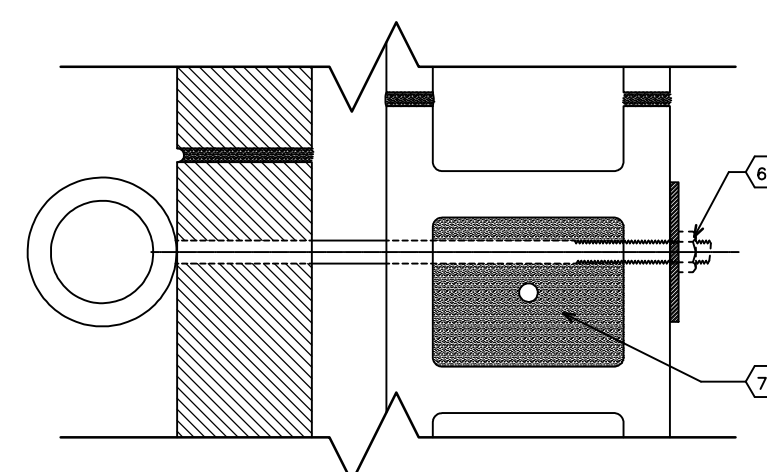

PLAN/SECTION - EYEBOLT
 N.T.S.

NOTE: DO NOT INSTALL SLEEVE IF LOCAL CODE ENFORCEMENT AUTHORITY HAS ADOPTED THE NEC - 2008.

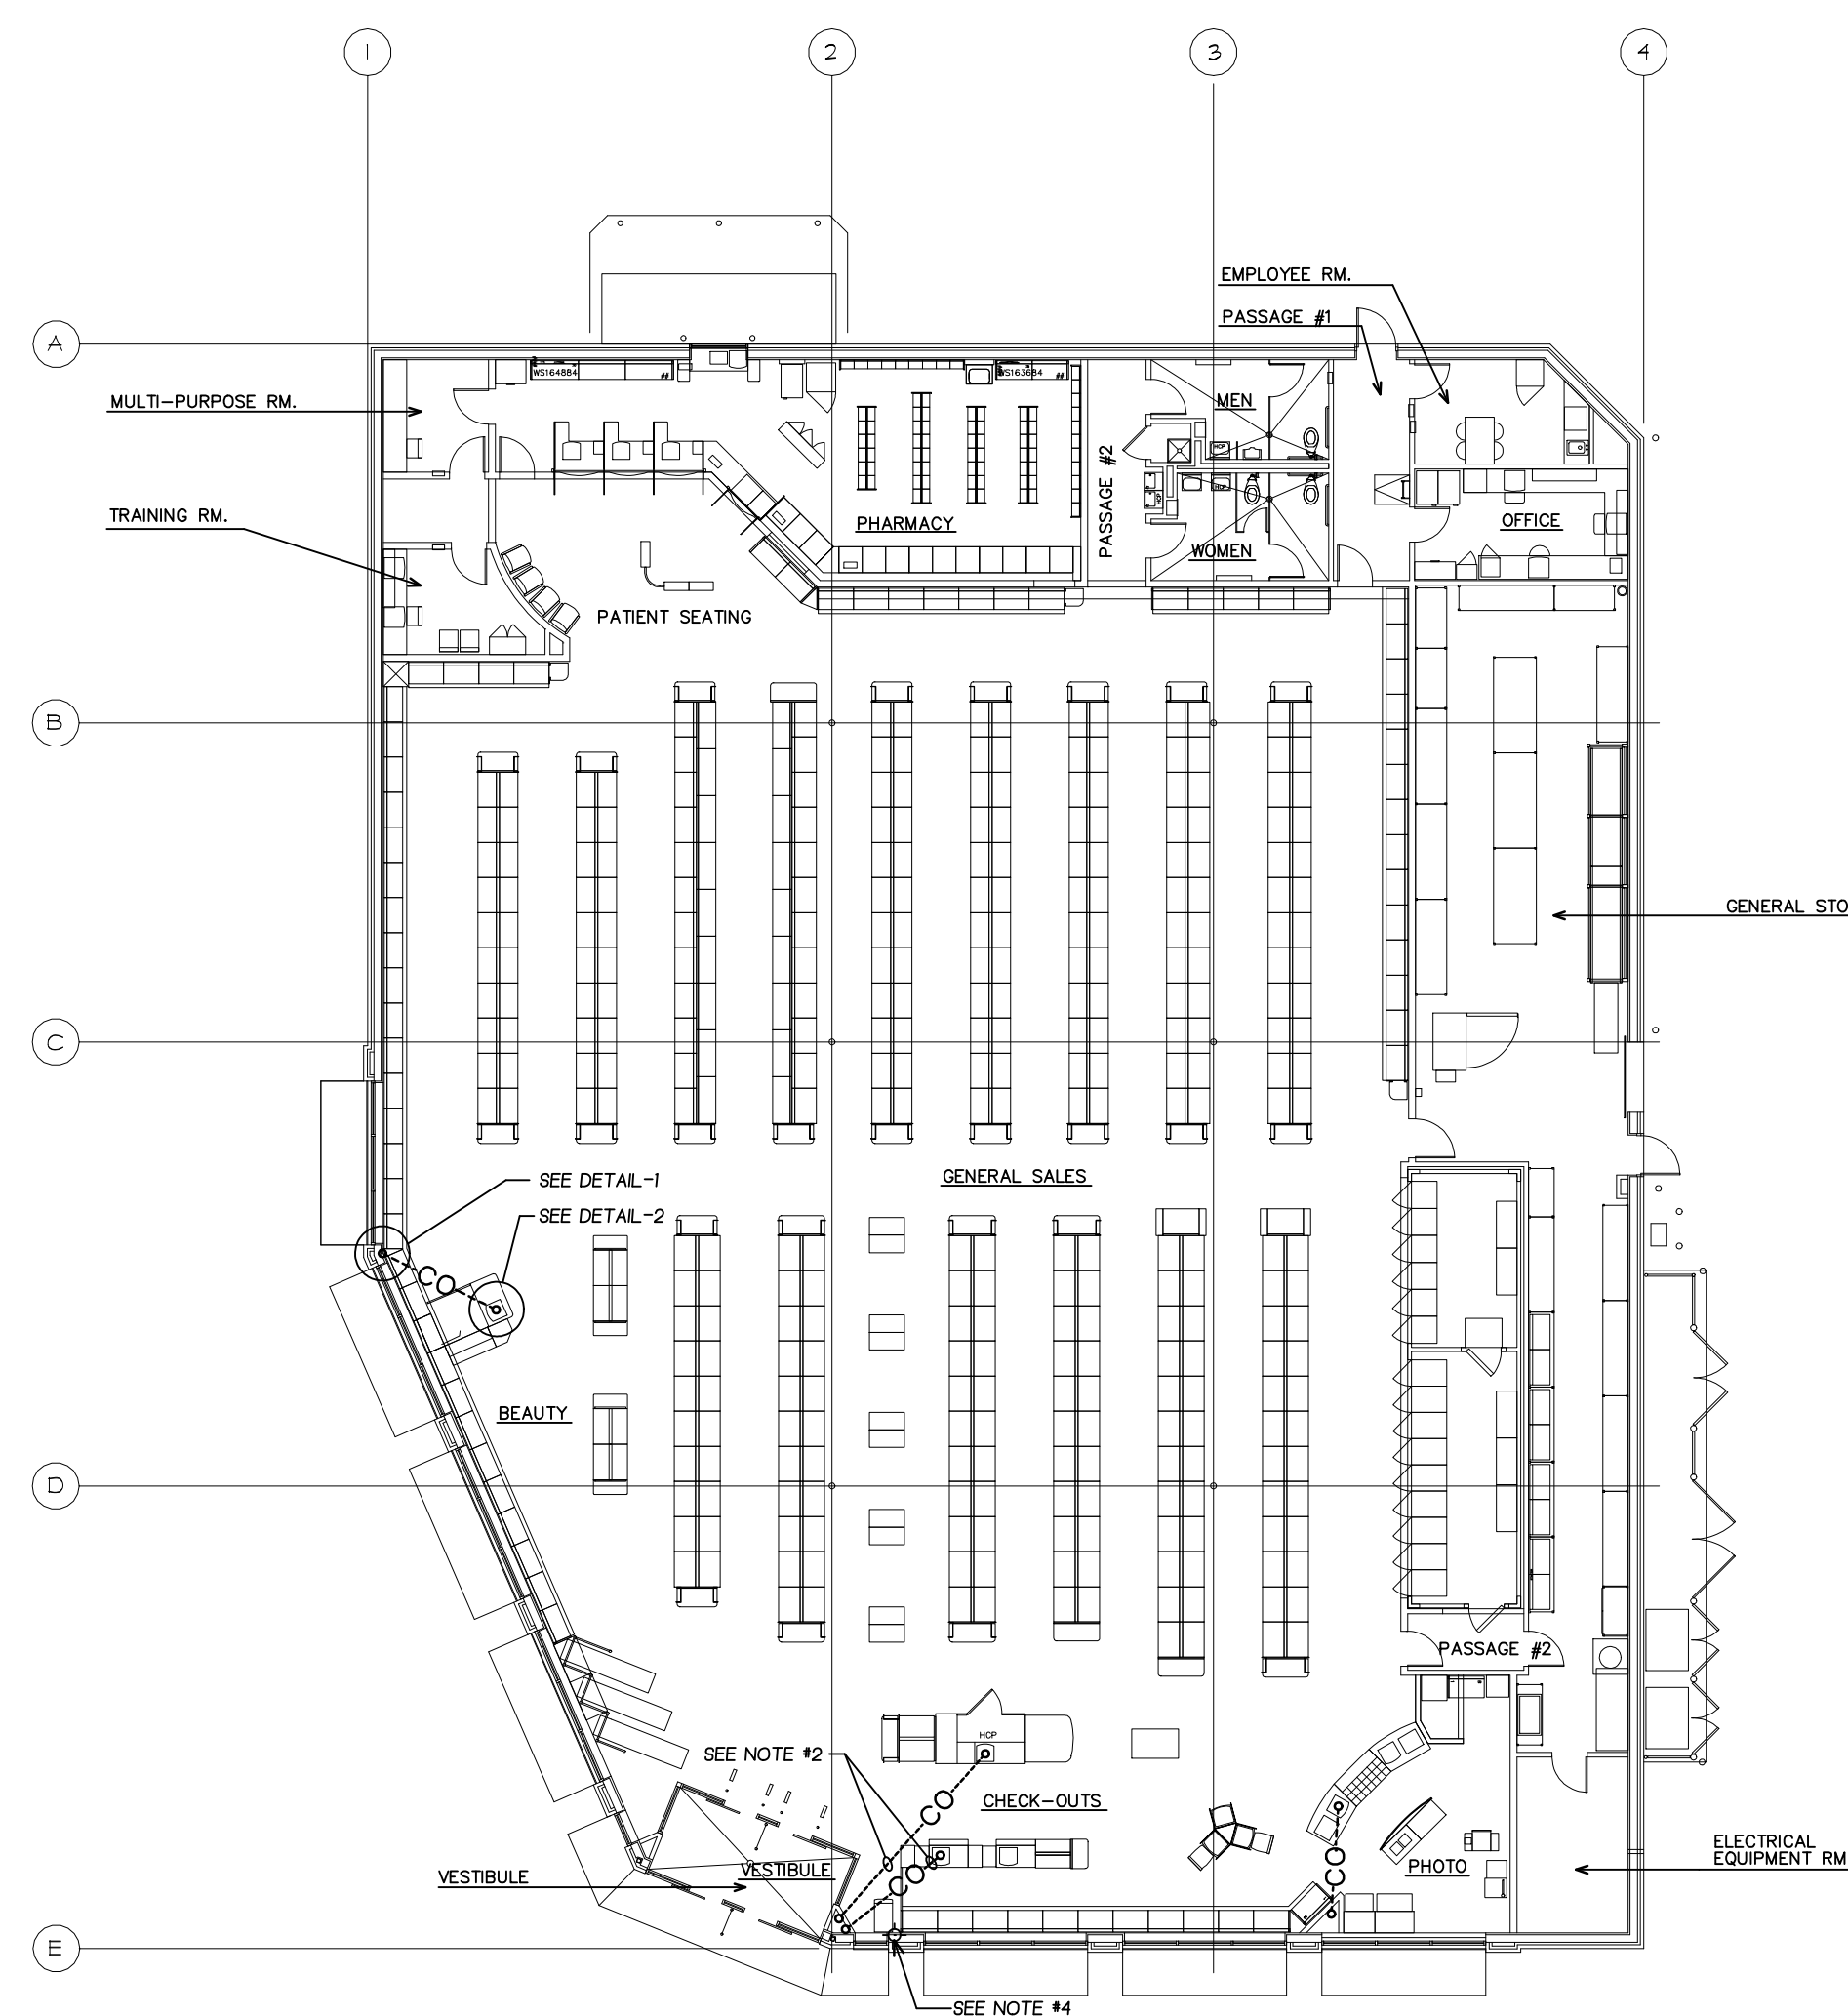


FLOOR PLAN - SPARE CONDUIT
 SCALE: 1/16" = 1'-0"


- SPARE CONDUIT NOTES**
1. ALL WORK SHOWN SHALL COMPLY WITH ALL NATIONAL, STATE AND LOCAL CODES, ORDINANCES, ETC.
 2. ONE (1) 1" COMMUNICATIONS CONDUIT WITH #12 PULL STRING BY LANDLORD'S CONTRACTOR.
 3. ELECTRICAL CONTRACTOR TO FURNISH SLEEVE ASSEMBLY SHOWN ON DETAIL 2B / A-4.1. MASONRY CONTRACTOR TO INSTALL AND COORDINATE WITH ELECTRICAL CONTRACTOR.
 4. ONE (1) SPARE 1" CONDUIT W/ #12 PULL STRING, BY LANDLORD'S CONTRACTOR. REFER TO DETAIL 3 (FUTURE INDYME TRANSMITTER).

LEGEND


----- CO -----	CONDUIT ONLY, BELOW FLOOR.
○	JUNCTION BOX

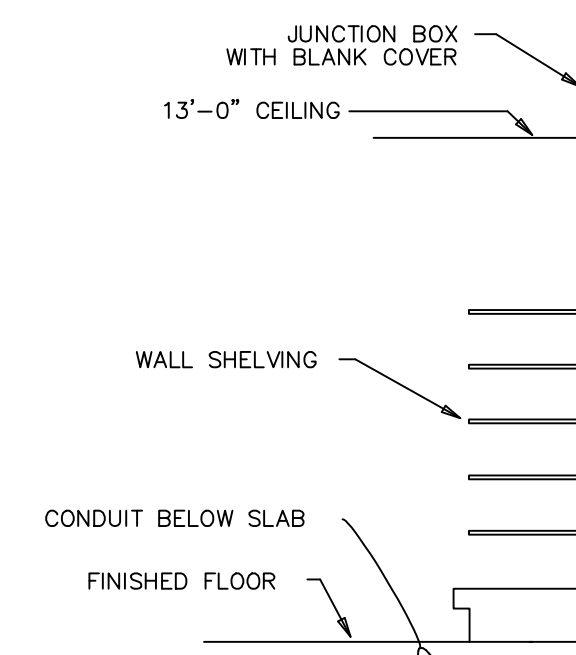

1 DETAIL
 N.T.S.

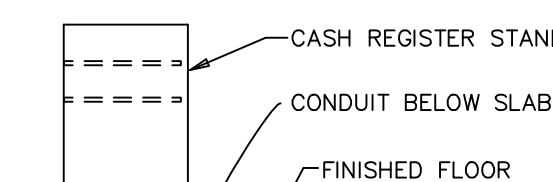

2 DETAIL
 N.T.S.

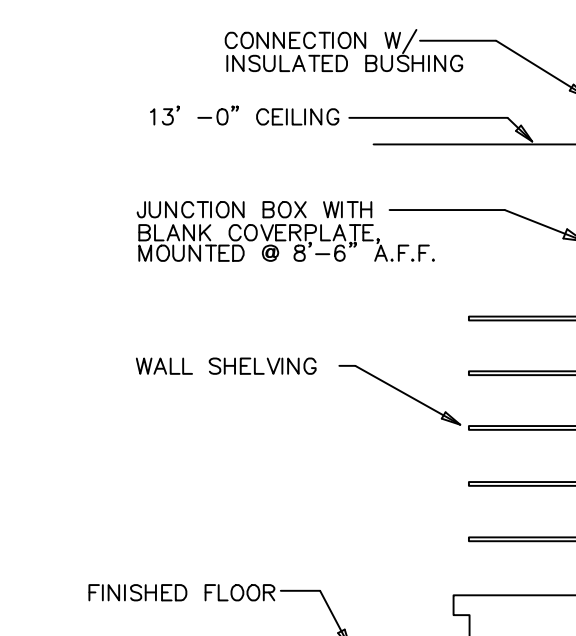

3 DETAIL
 N.T.S.

NO.	DATE	BY	DESCRIPTION	CONST
REVISIONS				

CERTIFICATION AND SEAL

I HEREBY CERTIFY THAT THIS PLAN AND SPECIFICATION WAS PREPARED BY ME OR UNDER MY DIRECT SUPERVISION AND THAT I AM A DULY REGISTERED ARCHITECT OR ENGINEER UNDER THE LAWS OF THE STATE OF MAINE AS SIGNIFIED BY MY HAND AND SEAL.

FISCAL 2007 CRITERIA - STORE #12326

WALGREENS
 (NWC) WASHINGTON & ALLEN AVES.
 PORTLAND, MAINE

DRAWING TITLE
FLOOR PLAN - SPARE CONDUIT PLAN

CADD PLOT:	SCALE: AS NOTED	DRAWING NO.
VOID PLOT:	DRAWN BY: TD	E1.6
RELEASED TO CONSTRUCTION	DATE: 3-26-09	
	REVIEWED BY: SAM	