

RESERVED FOR CITY STAMP


REVISION	DESCRIPTION	DATE
0	ISSUED FOR REVIEW & APPROVAL	3/12/2014

CUNNINGHAM
Security Systems
 10 Princes Point Road, Yarmouth, Maine 04096
 Office: 207.846.3350 • Fax: 207.846.6080


SURFACE CREATIONS OF MAINE
25 RICE STREET
PORTLAND, MAINE 04103
FIRE ALARM PLAN & WIRING DETAILS

DRAWN	JPB UNICAD JOB #14129
CHECKED	WAYNE B. HAWIS NICET IV 90496
DATE	3/12/2014
REVISION	0
SCALE	1/8"=1'-0"


FIRE ALARM PLAN
 SCALE: 1/8"=1'-0"

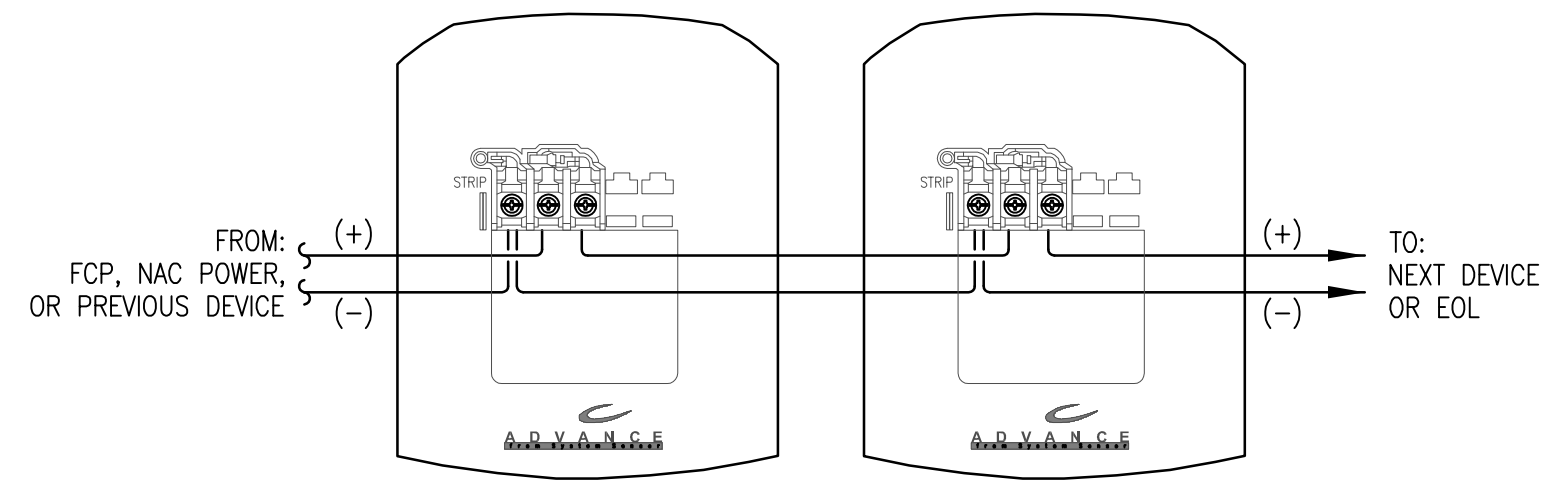

TYPICAL 2 WIRE STROBE WIRING DETAIL
 SCHEMATIC: NO SCALE

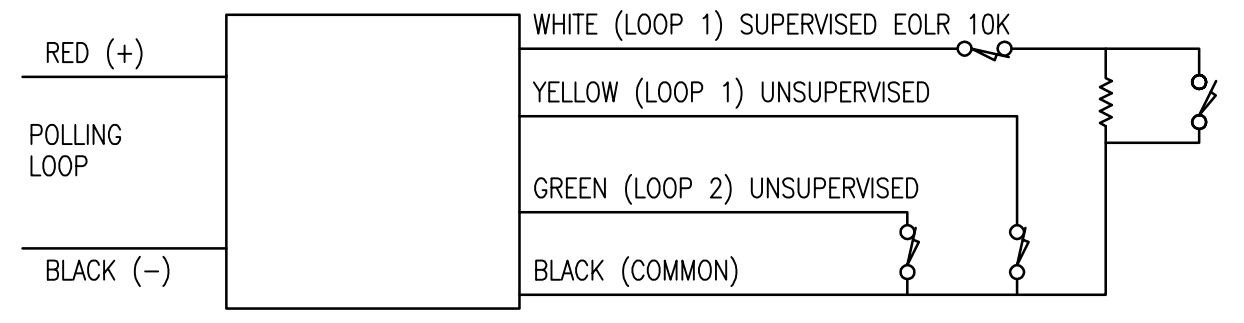

4193SN TWO ZONE SIM WIRING DETAIL
 SCHEMATIC: NO SCALE

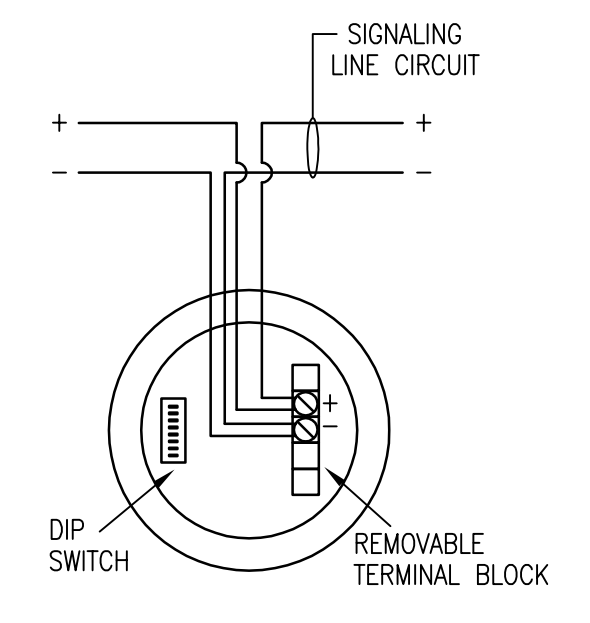

5192SD SMOKE DETECTOR WIRING DETAIL
 SCHEMATIC: NO SCALE

Shop drawings created by
 5794 W. 4600 St.
 Hudson, UT 84315
 Office: 801.965.0410

UNICAD Inc.
 Fire Alarm Design & Drafting Services

FA-2