

DESIGNER

OWNER

UNITIL

6 LIBERTY LANE WEST  
HAMPTON, NEW HAMPSHIRE  
03842

PROJECT

NORTHERN  
UTILITIES, INC.  
FIT-UP

400 RIVERSIDE INDUSTRIAL PARKWAY  
PORTLAND, MAINE 04101

DRAWING


FIRST FLOOR  
LIGHTING PLAN  
AREA "A"

REVISIONS

DRAWING NUMBER

**E1.11**

SCALE: 1/8" = 1'-0"  
DATE: 04/17/15

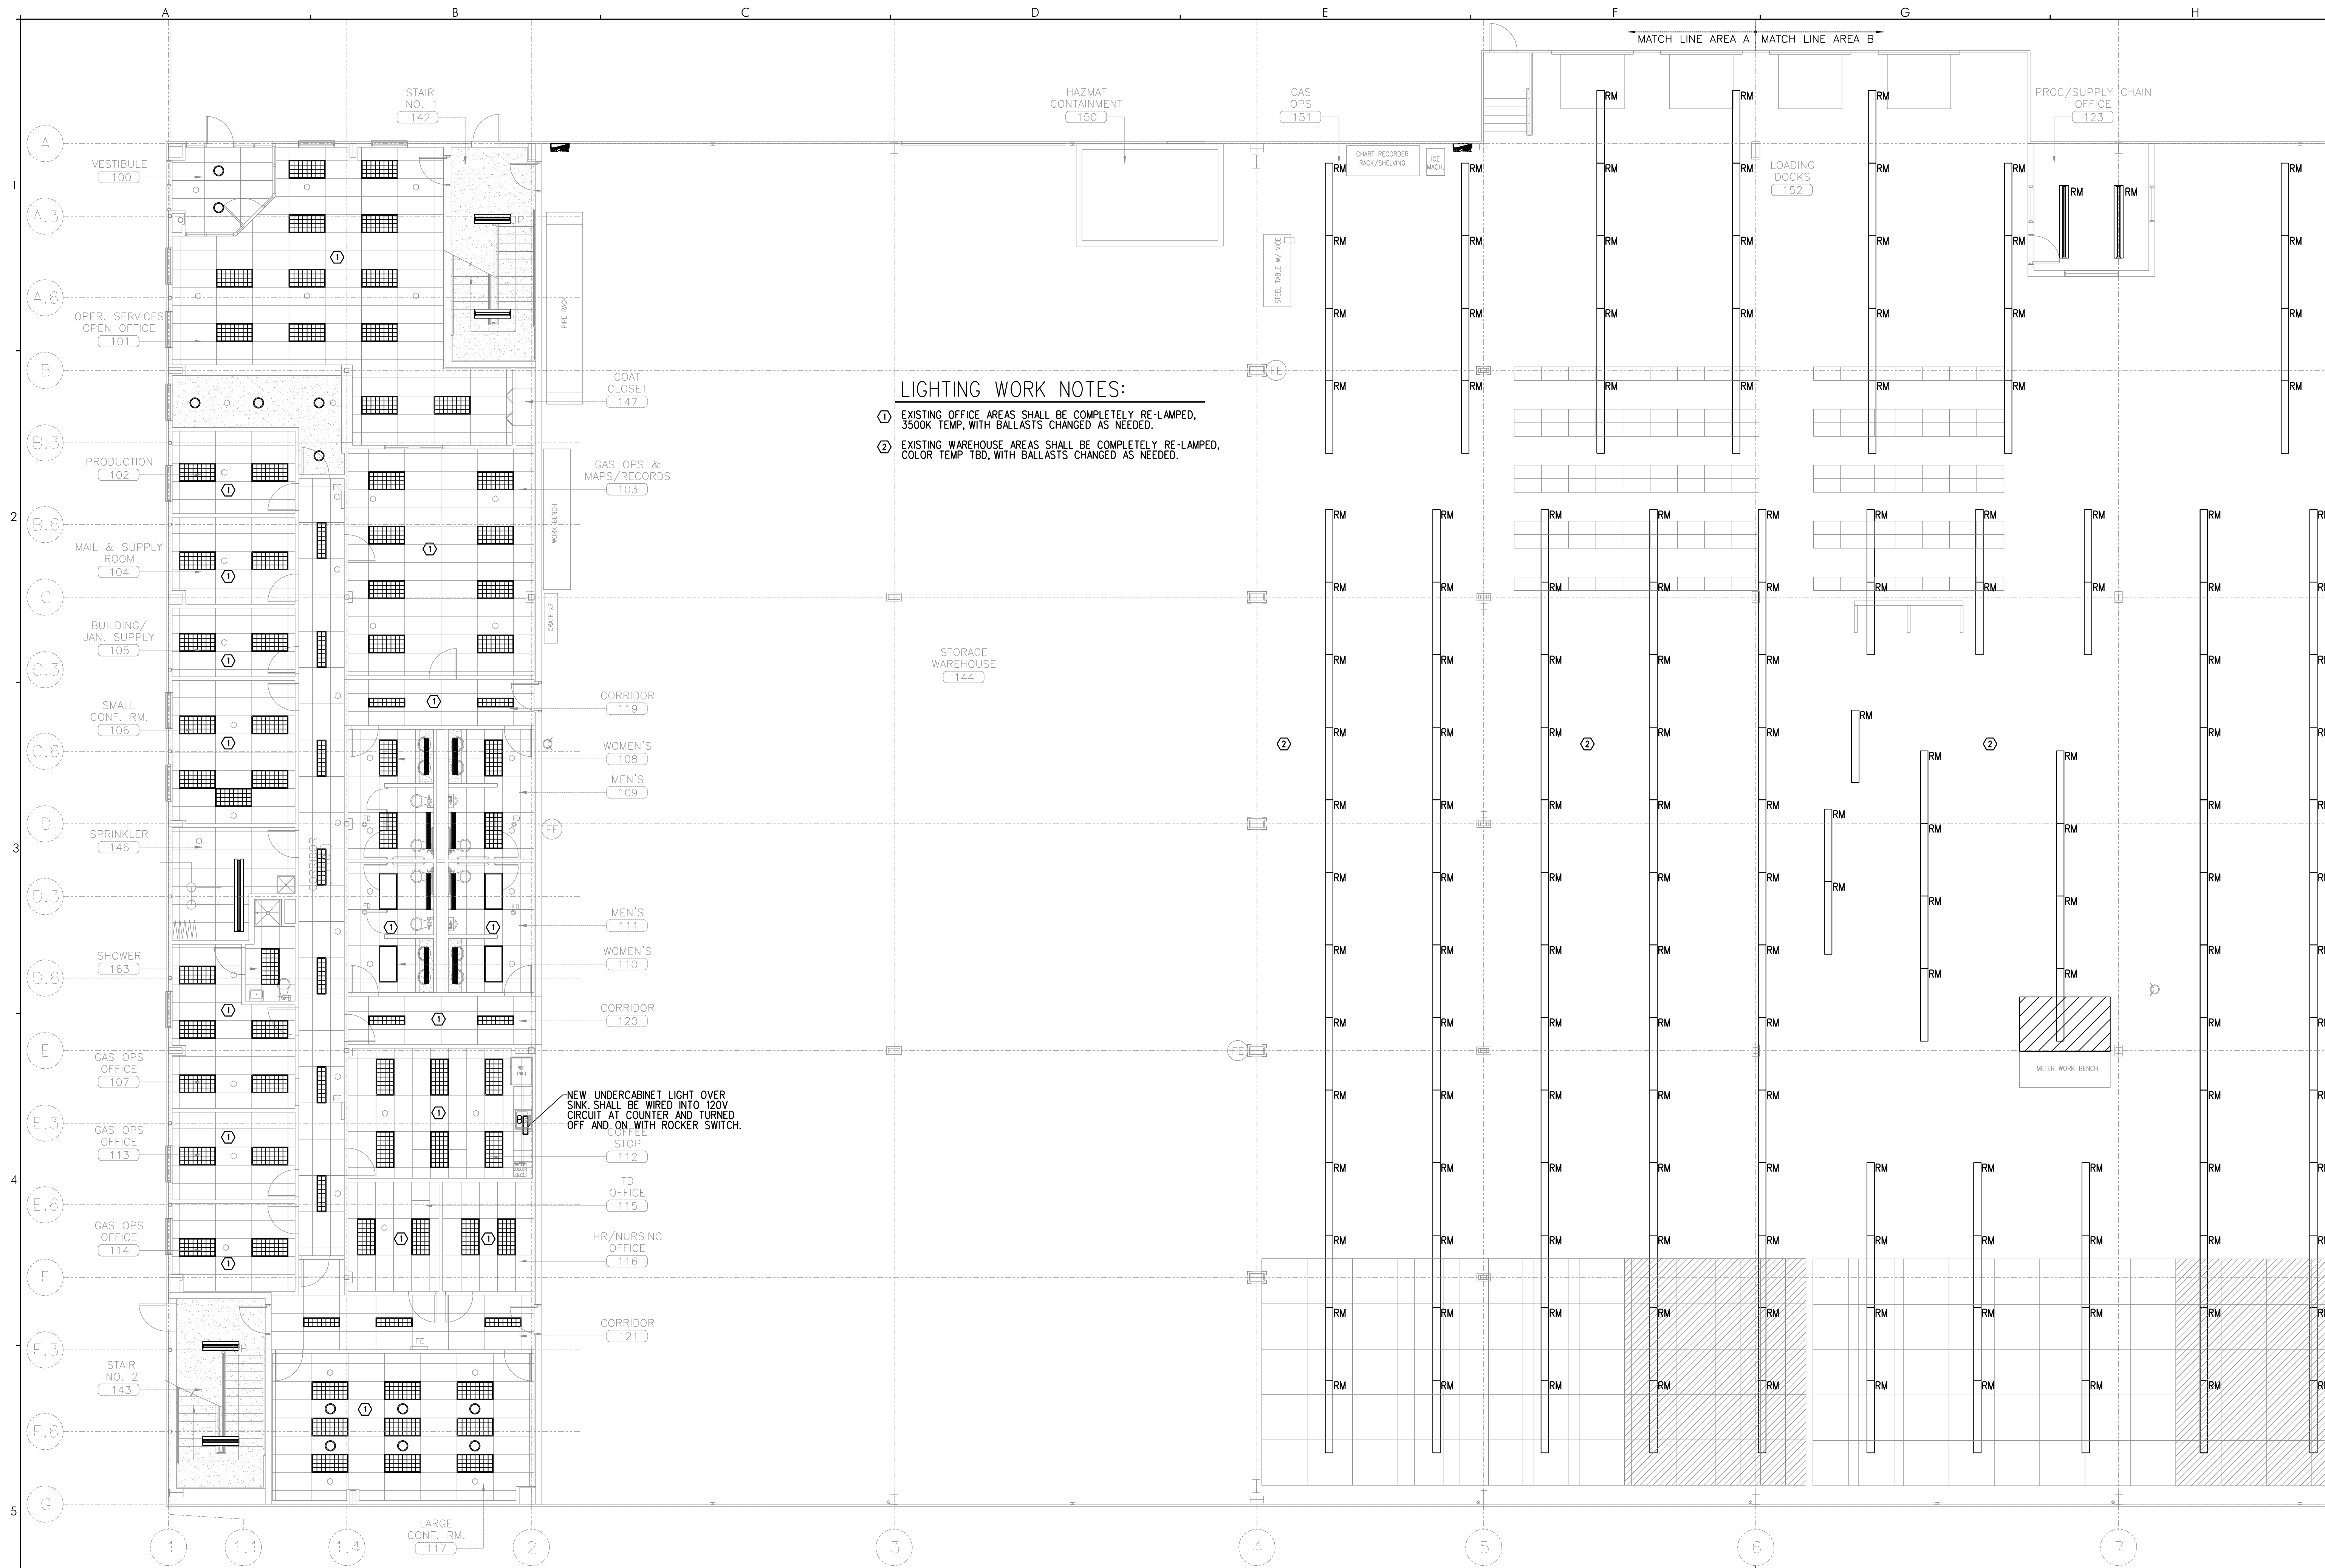

**LIGHTING WORK NOTES:**

- ① EXISTING OFFICE AREAS SHALL BE COMPLETELY RE-LAMPED, 3500K TEMP, WITH BALLASTS CHANGED AS NEEDED.
- ② EXISTING WAREHOUSE AREAS SHALL BE COMPLETELY RE-LAMPED, COLOR TEMP TBD, WITH BALLASTS CHANGED AS NEEDED.

NEW UNDERCABINET LIGHT OVER SINK SHALL BE WIRED INTO 120V CIRCUIT AT COUNTER AND TURNED OFF AND ON WITH ROCKER SWITCH.