

DESIGNER

OWNER

PROJECT

DRAWING

REVISIONS

DRAWING NUMBER


E1.21

SCALE: 1/8" = 1'-0"
DATE: 04/17/15


UNITIL
6 LIBERTY LANE WEST
HAMPTON, NEW HAMPSHIRE
03842

NORTHERN
UTILITIES, INC.
FIT-UP
400 RIVERSIDE INDUSTRIAL PARKWAY
PORTLAND, MAINE 04101

SECOND FLOOR
LIGHTING PLAN
AREA "A"

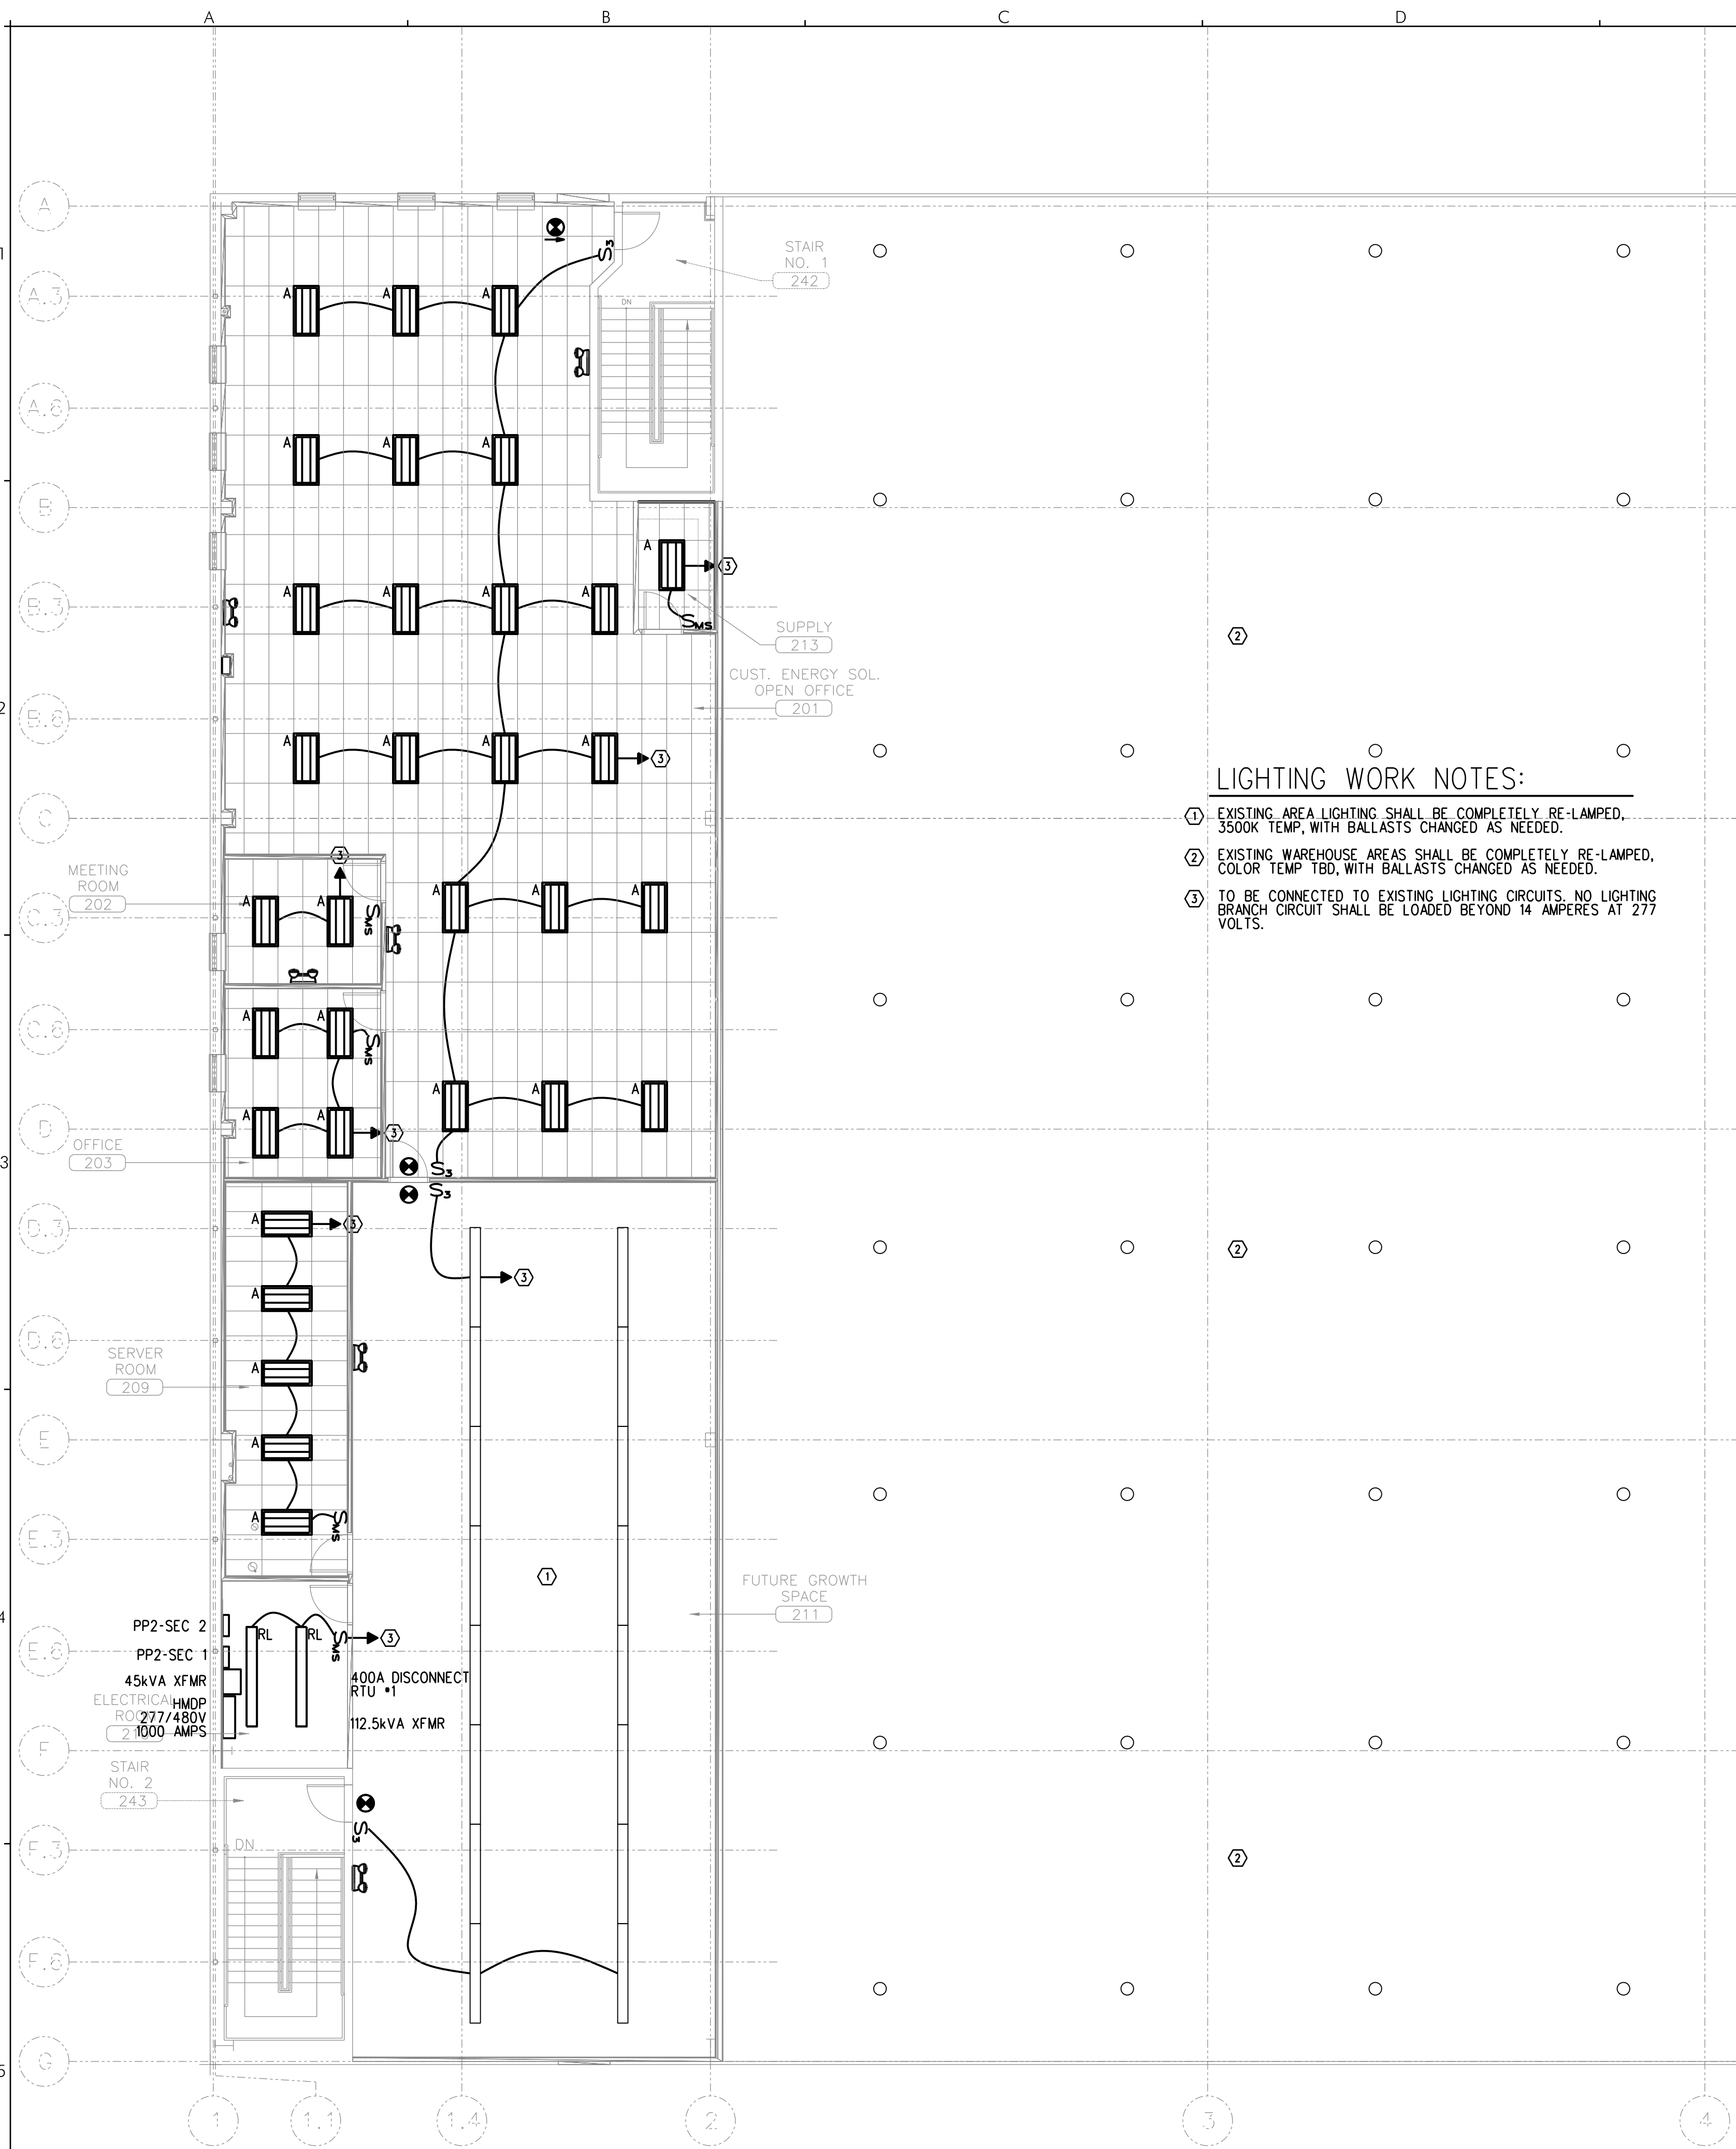

E1 NEW SECOND FLOOR LIGHTING PLAN- AREA "A"
SCALE: 1/8" = 1'-0"

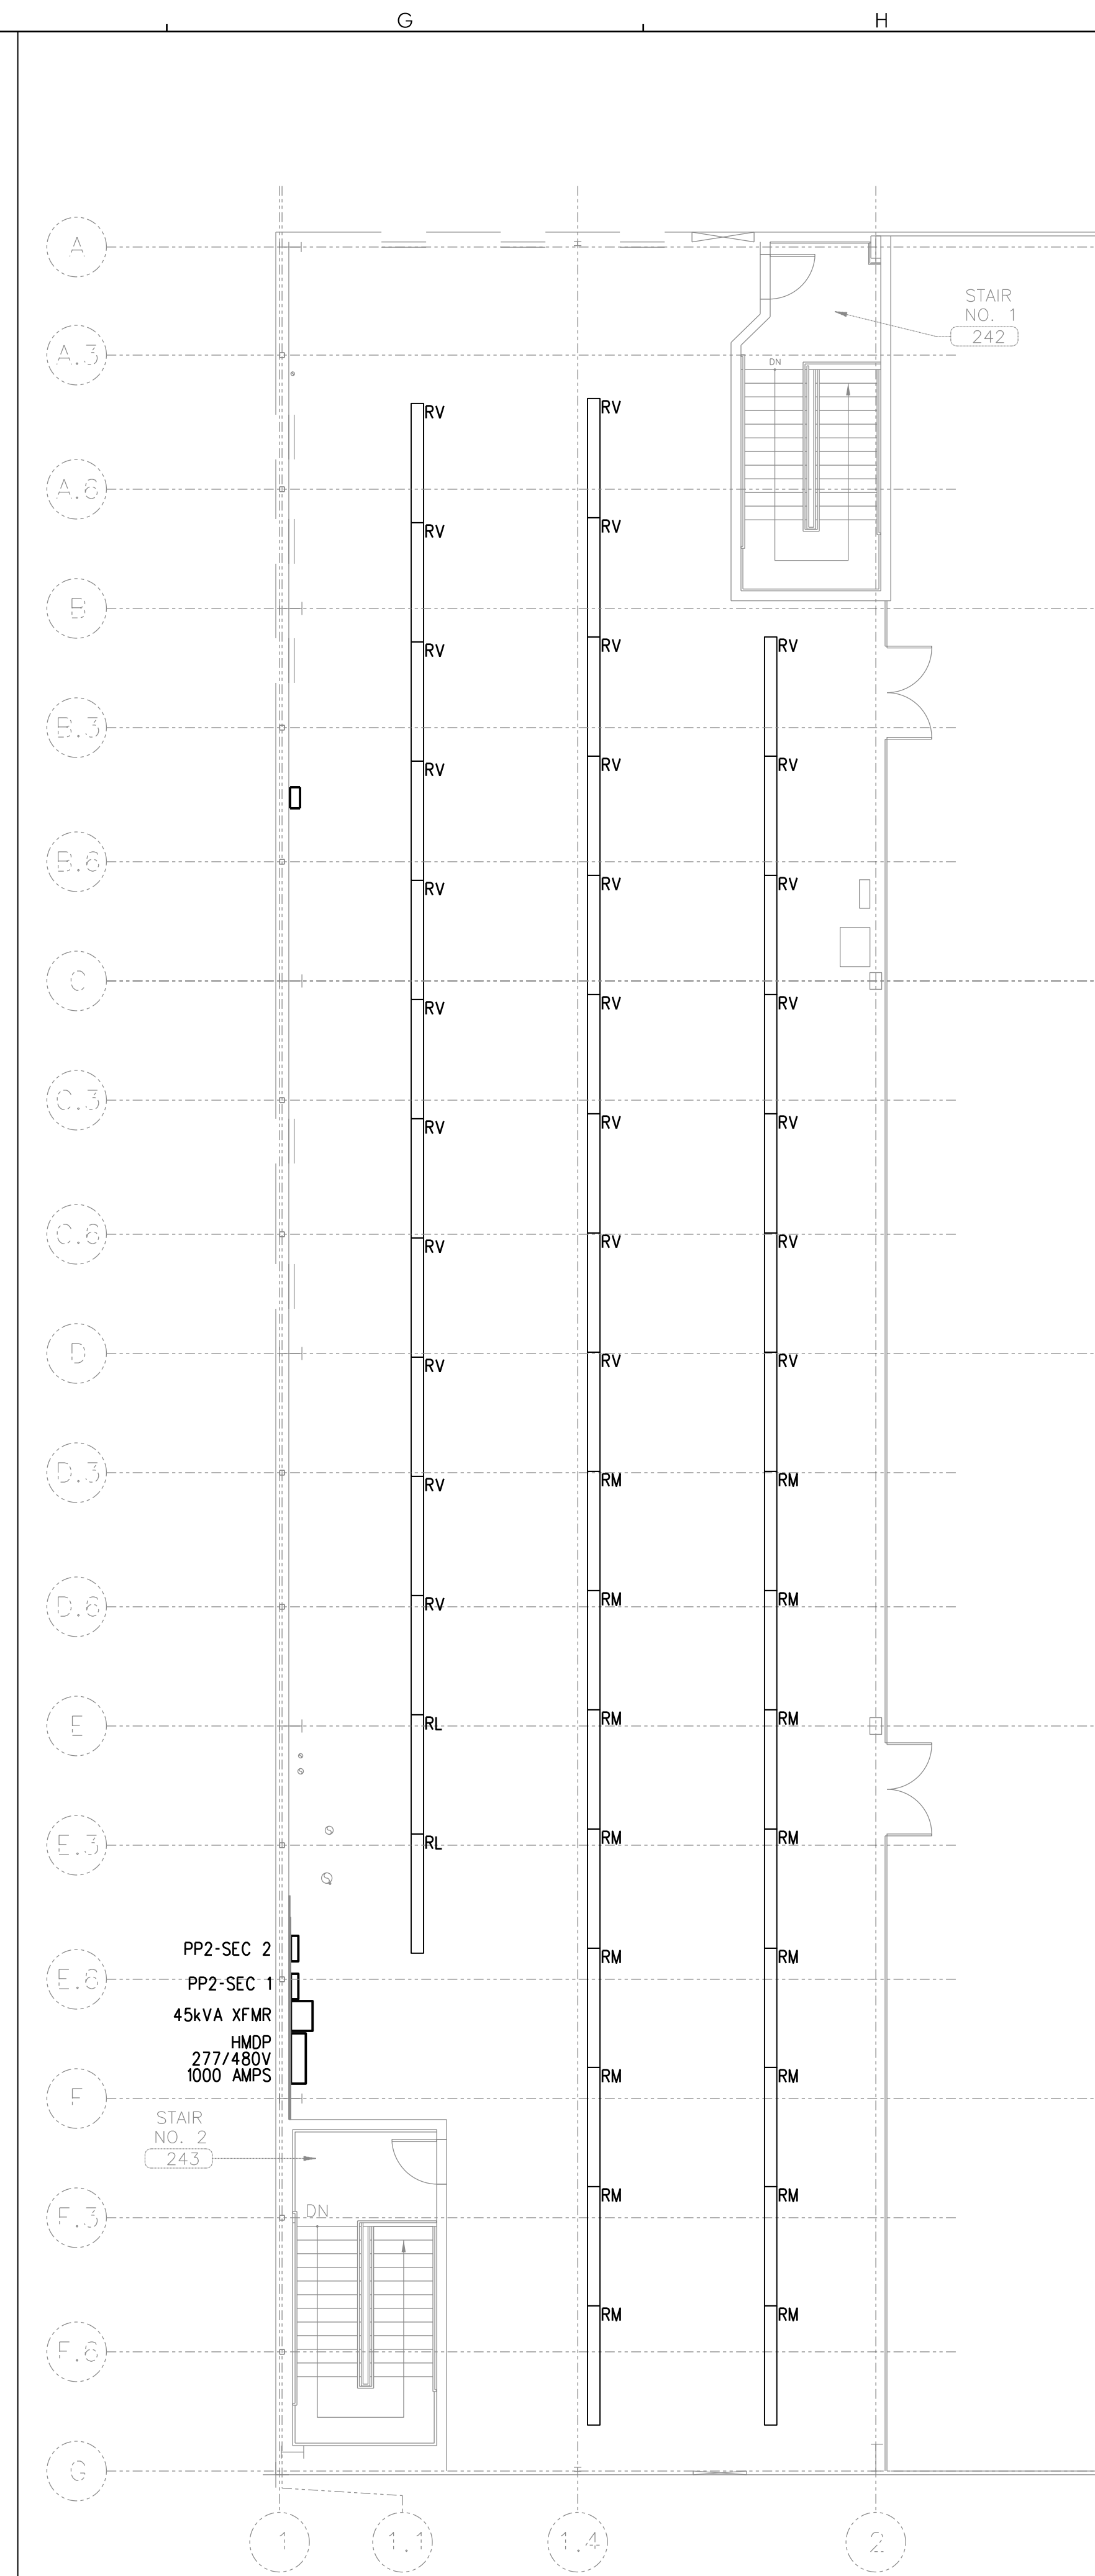

E2 EXISTING SECOND FLOOR LIGHTING PLAN- AREA "A"
REFERENCED FROM: SCALE: 1/8" = 1'-0"