

DESIGNER

CWS ARCHITECTS
ARCHITECTURE | INTERIOR DESIGN
264 US ROUTE ONE
BOX 6, SUITE 100-2A
SCARBOROUGH, MAINE 04074
T: 207.774.4441
WWW.CWSARCH.COM

OWNER

UNITIL

6 LIBERTY LANE WEST
HAMPTON, NEW HAMPSHIRE 03842

PROJECT

UNITIL GAS
OPERATIONS TRAINING
AND TESTING ROOM

376 RIVERSIDE INDUSTRIAL PARKWAY
PORTLAND, MAINE 04101

DRAWING

ENLARGED TRAINING / TESTING
ROOM REFLECTED
CEILING PLAN

CWS PROJECT NUMBER: 17027

REVISIONS


NO.	DATE	DESCRIPTION

DRAWING NUMBER

A2.11

SCALE: AS NOTED
DATE: 08/14/2017

ISSUED FOR CONSTRUCTION

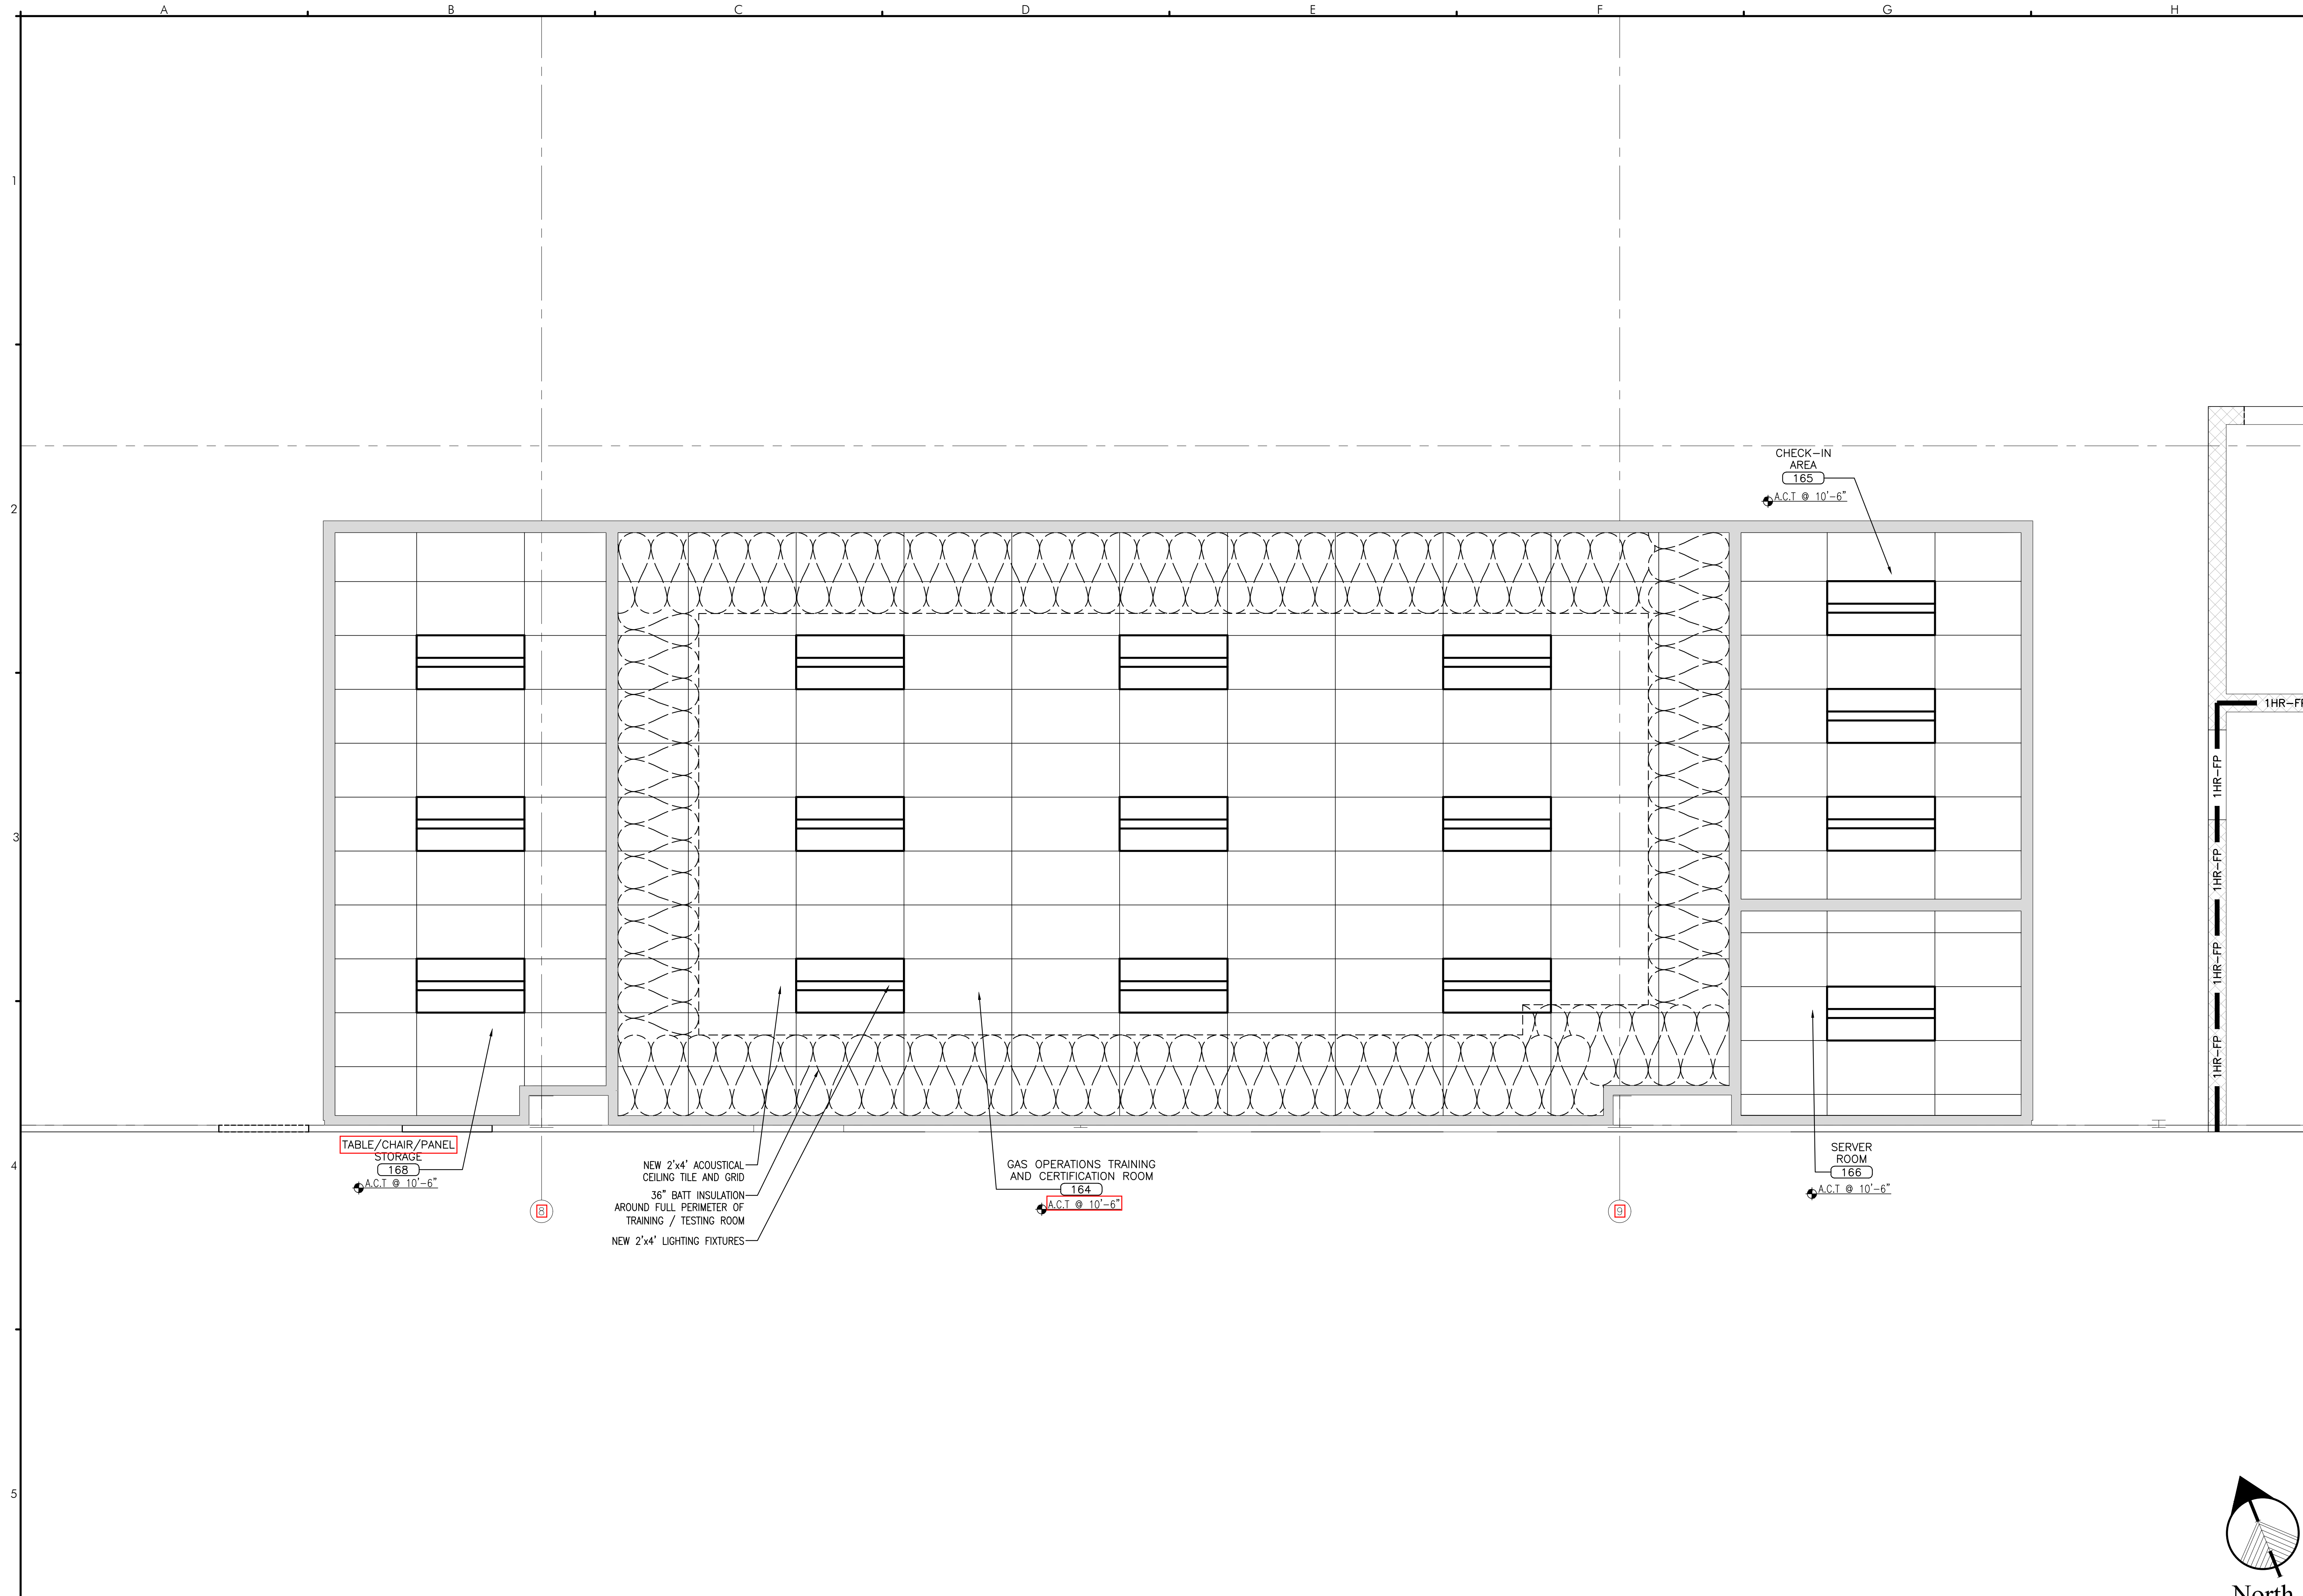

A5 ENLARGED TRAINING/TESTING ROOM REFLECTED CEILING PLAN
REFERENCED FROM: A2.10 SCALE: 3/8" = 1'-0"