

CWS ARCHITECTS
ARCHITECTURE | INTERIOR DESIGN
264 US ROUTE ONE
SCARBOROUGH, MAINE 04074
T: 207-774-4441
WWW.CWSARCH.COM

OWNER
UNITIL
6 LIBERTY LANE WEST
HAMPTON, NEW HAMPSHIRE 03842

PROJECT
UNITIL GAS
OPERATIONS TRAINING
AND TESTING ROOM
376 RIVERSIDE INDUSTRIAL PARKWAY
PORTLAND, MAINE 04101


DRAWING
LAYOUT OPTION #2 -
OVERALL LIFE SAFETY PLAN
CWS PROJECT NUMBER: 17027

REVISIONS

NO.	DATE	DESCRIPTION

DRAWING NUMBER
LS1.02

SCALE: AS NOTED
DATE: 08/14/2017

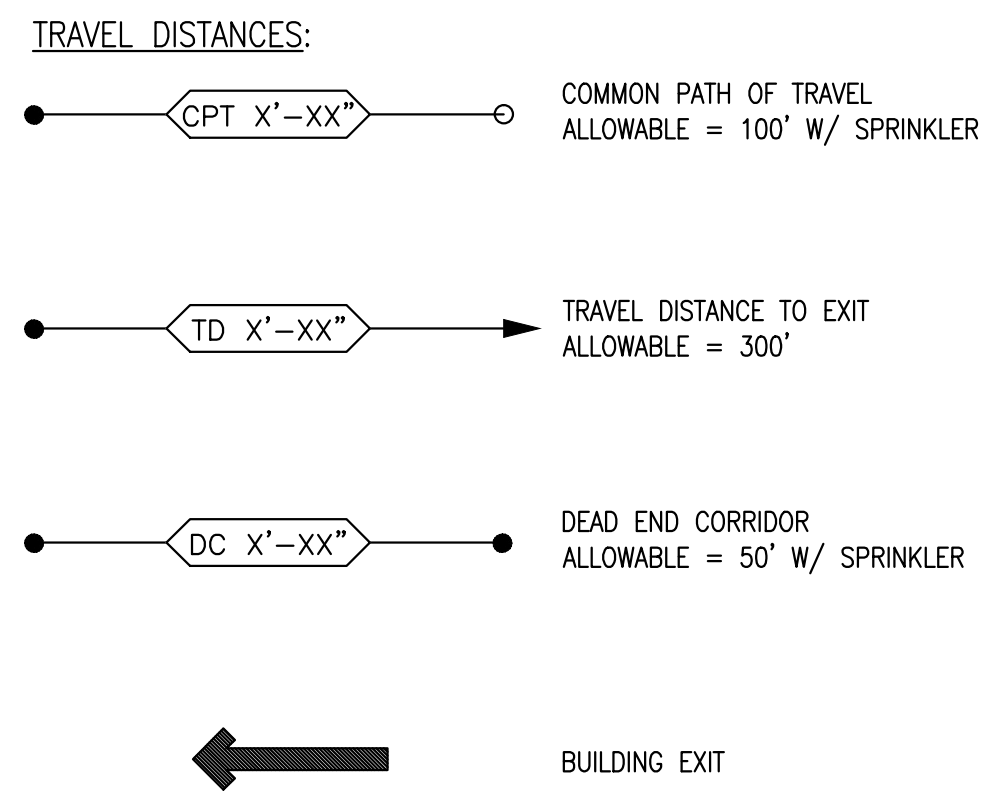

PROPOSED USE:
THE BUILDING IS CONSIDERED A NON-SEPARATED / MIXED USE FACILITY.
TRAINING ROOM / CERTIFICATION ROOM WILL BE AN ASSEMBLY A-2 / ASSEMBLY SPACE.
THE SPACE IS BEING CONSIDERED AN ACCESSORY USE WITHIN THE EXISTING S-2 PORTION OF THE BUILDING.

OVERALL BUILDING AREA:
THIS PROJECT WILL NOT IMPACT TO THE BUILDINGS HEIGHT OR AREA.

TRAINING/CERTIFICATION ROOM OCCUPANT LOAD:
ASSEMBLY USE: O.L. 80 PEOPLE

FIRE ALARM SYSTEM:
FIRE ALARM SYSTEM LAYOUT TO BE RECONFIGURED AS REQUIRED TO ACCOMMODATE THE NEW SPACE LAYOUT.

FIRE SUPPRESSION:
FIRE SUPPRESSION SPRINKLER SYSTEM LAYOUT TO BE RECONFIGURED AS REQUIRED TO ACCOMMODATE THE NEW SPACE LAYOUT.

FIRE PARTITIONS:
NOT APPLICABLE TO THIS PROJECT

SYMBOLS LEGEND:

- EXIT SIGN - ARROW DENOTES EXIT SIGN TO BE PROVIDED WITH DIRECTIONAL ARROW
- SEMI-RECESSED FIRE EXTINGUISHER CABINET AND FIRE EXTINGUISHER
- WALL MOUNTED FIRE EXTINGUISHER
- SMOKE DETECTOR
- PULL STATION
- HORN/STROBE DEVICE W/ CANDELLA RATING
- STROBE DEVICE W/ CANDELLA RATING
- EMERGENCY LIGHT FIXTURE
- FIRE ALARM CONTROL PANEL
- FIRE ALARM ANNUCIATOR PANEL
- KNOX-BOX

NOTES:
** REFER TO THE CODE SUMMARY ON DRAWINGS LS1.01 FOR ADDITIONAL INFORMATION AND CALCULATIONS.

