

DESIGNER

OWNER

UNITIL
6 LIBERTY LANE WEST
HAMPTON, NEW HAMPSHIRE
03842

PROJECT

NORTHERN
UTILITIES, INC.
FIT-UP
400 RIVERSIDE INDUSTRIAL PARKWAY
PORTLAND, MAINE 04101

DRAWING


FIRST FLOOR
AREA "A"

REVISIONS

DRAWING NUMBER


FA2.11

SCALE: 1/8" = 1'-0"
DATE: 04/17/15

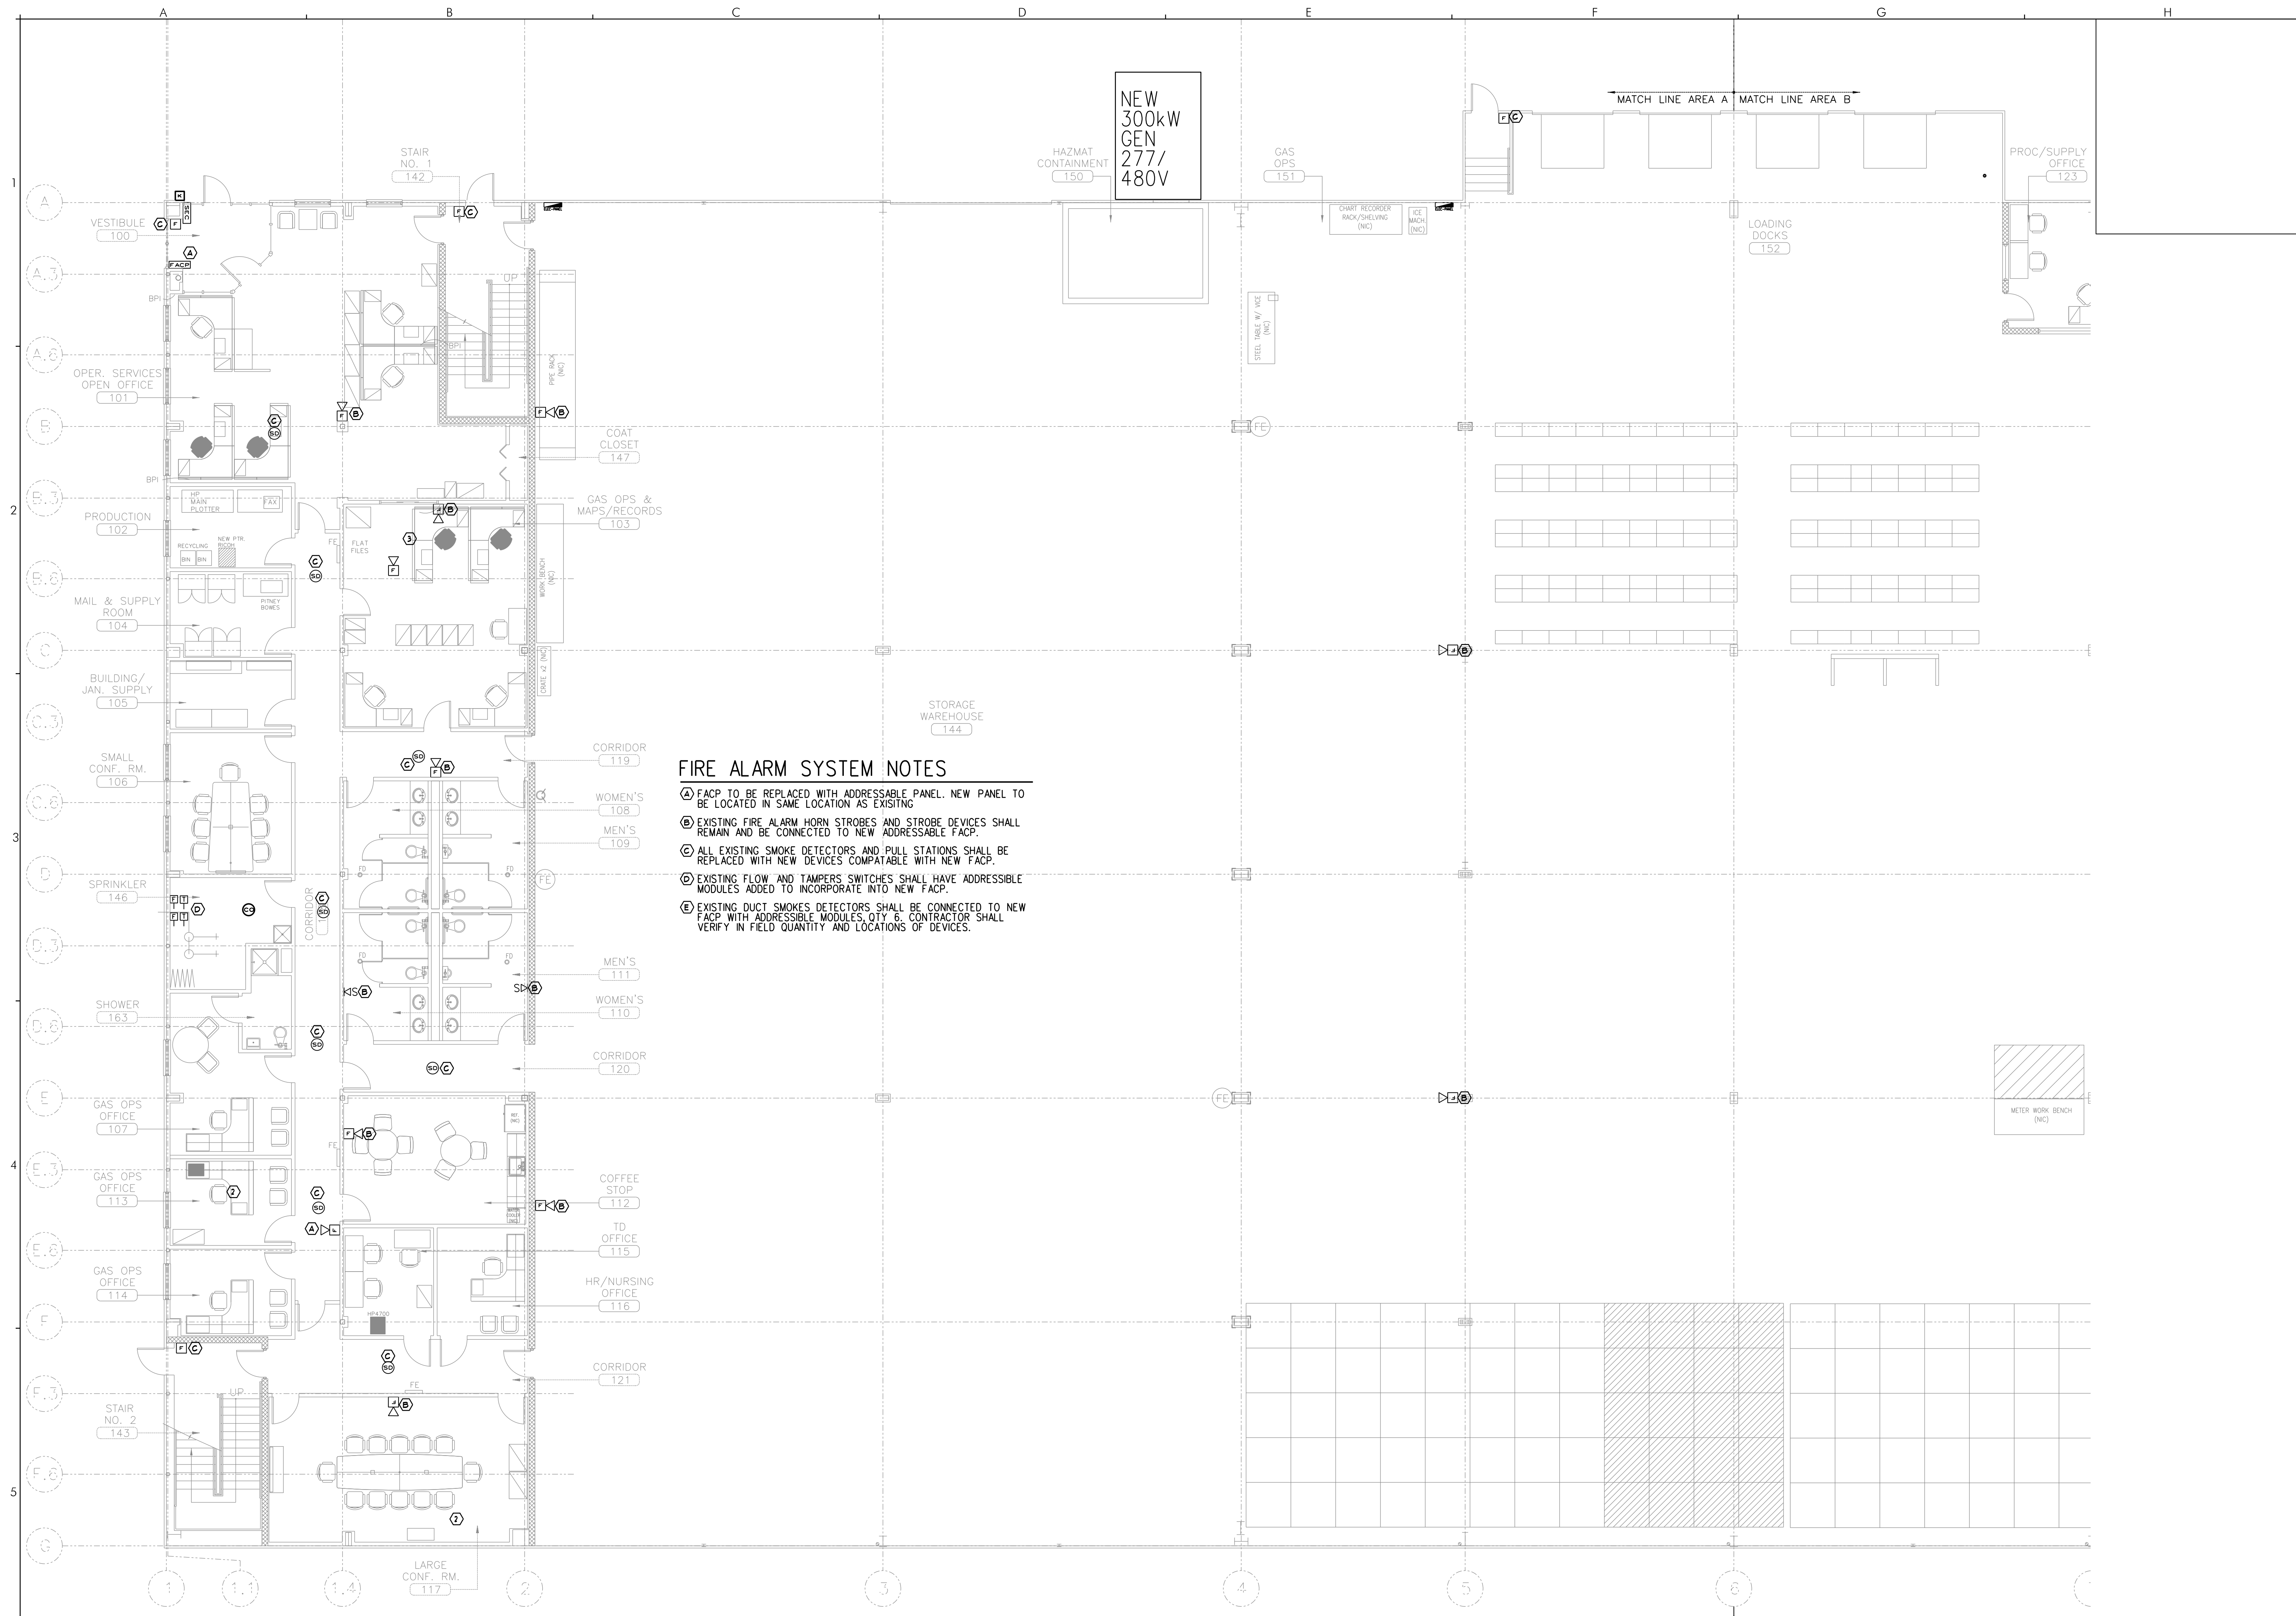

FIRE ALARM SYSTEM NOTES

 - Ⓐ FACP TO BE REPLACED WITH ADDRESSABLE PANEL. NEW PANEL TO BE LOCATED IN SAME LOCATION AS EXISTING
- Ⓑ EXISTING FIRE ALARM HORN STROBES AND STROBE DEVICES SHALL REMAIN AND BE CONNECTED TO NEW ADDRESSABLE FACP.
- Ⓒ ALL EXISTING SMOKE DETECTORS AND PULL STATIONS SHALL BE REPLACED WITH NEW DEVICES COMPATABLE WITH NEW FACP.
- Ⓓ EXISTING FLOW AND TAMPERS SWITCHES SHALL HAVE ADDRESSIBLE MODULES ADDED TO INCORPORATE INTO NEW FACP.
- Ⓔ EXISTING DUCT SMOKE DETECTORS SHALL BE CONNECTED TO NEW FACP WITH ADDRESSIBLE MODULES, QTY 6. CONTRACTOR SHALL VERIFY IN FIELD QUANTITY AND LOCATIONS OF DEVICES.



MATCH LINE AREA A MATCH LINE AREA B