



LOWER LEVEL CEILING PLAN

1/8"=1'-0"

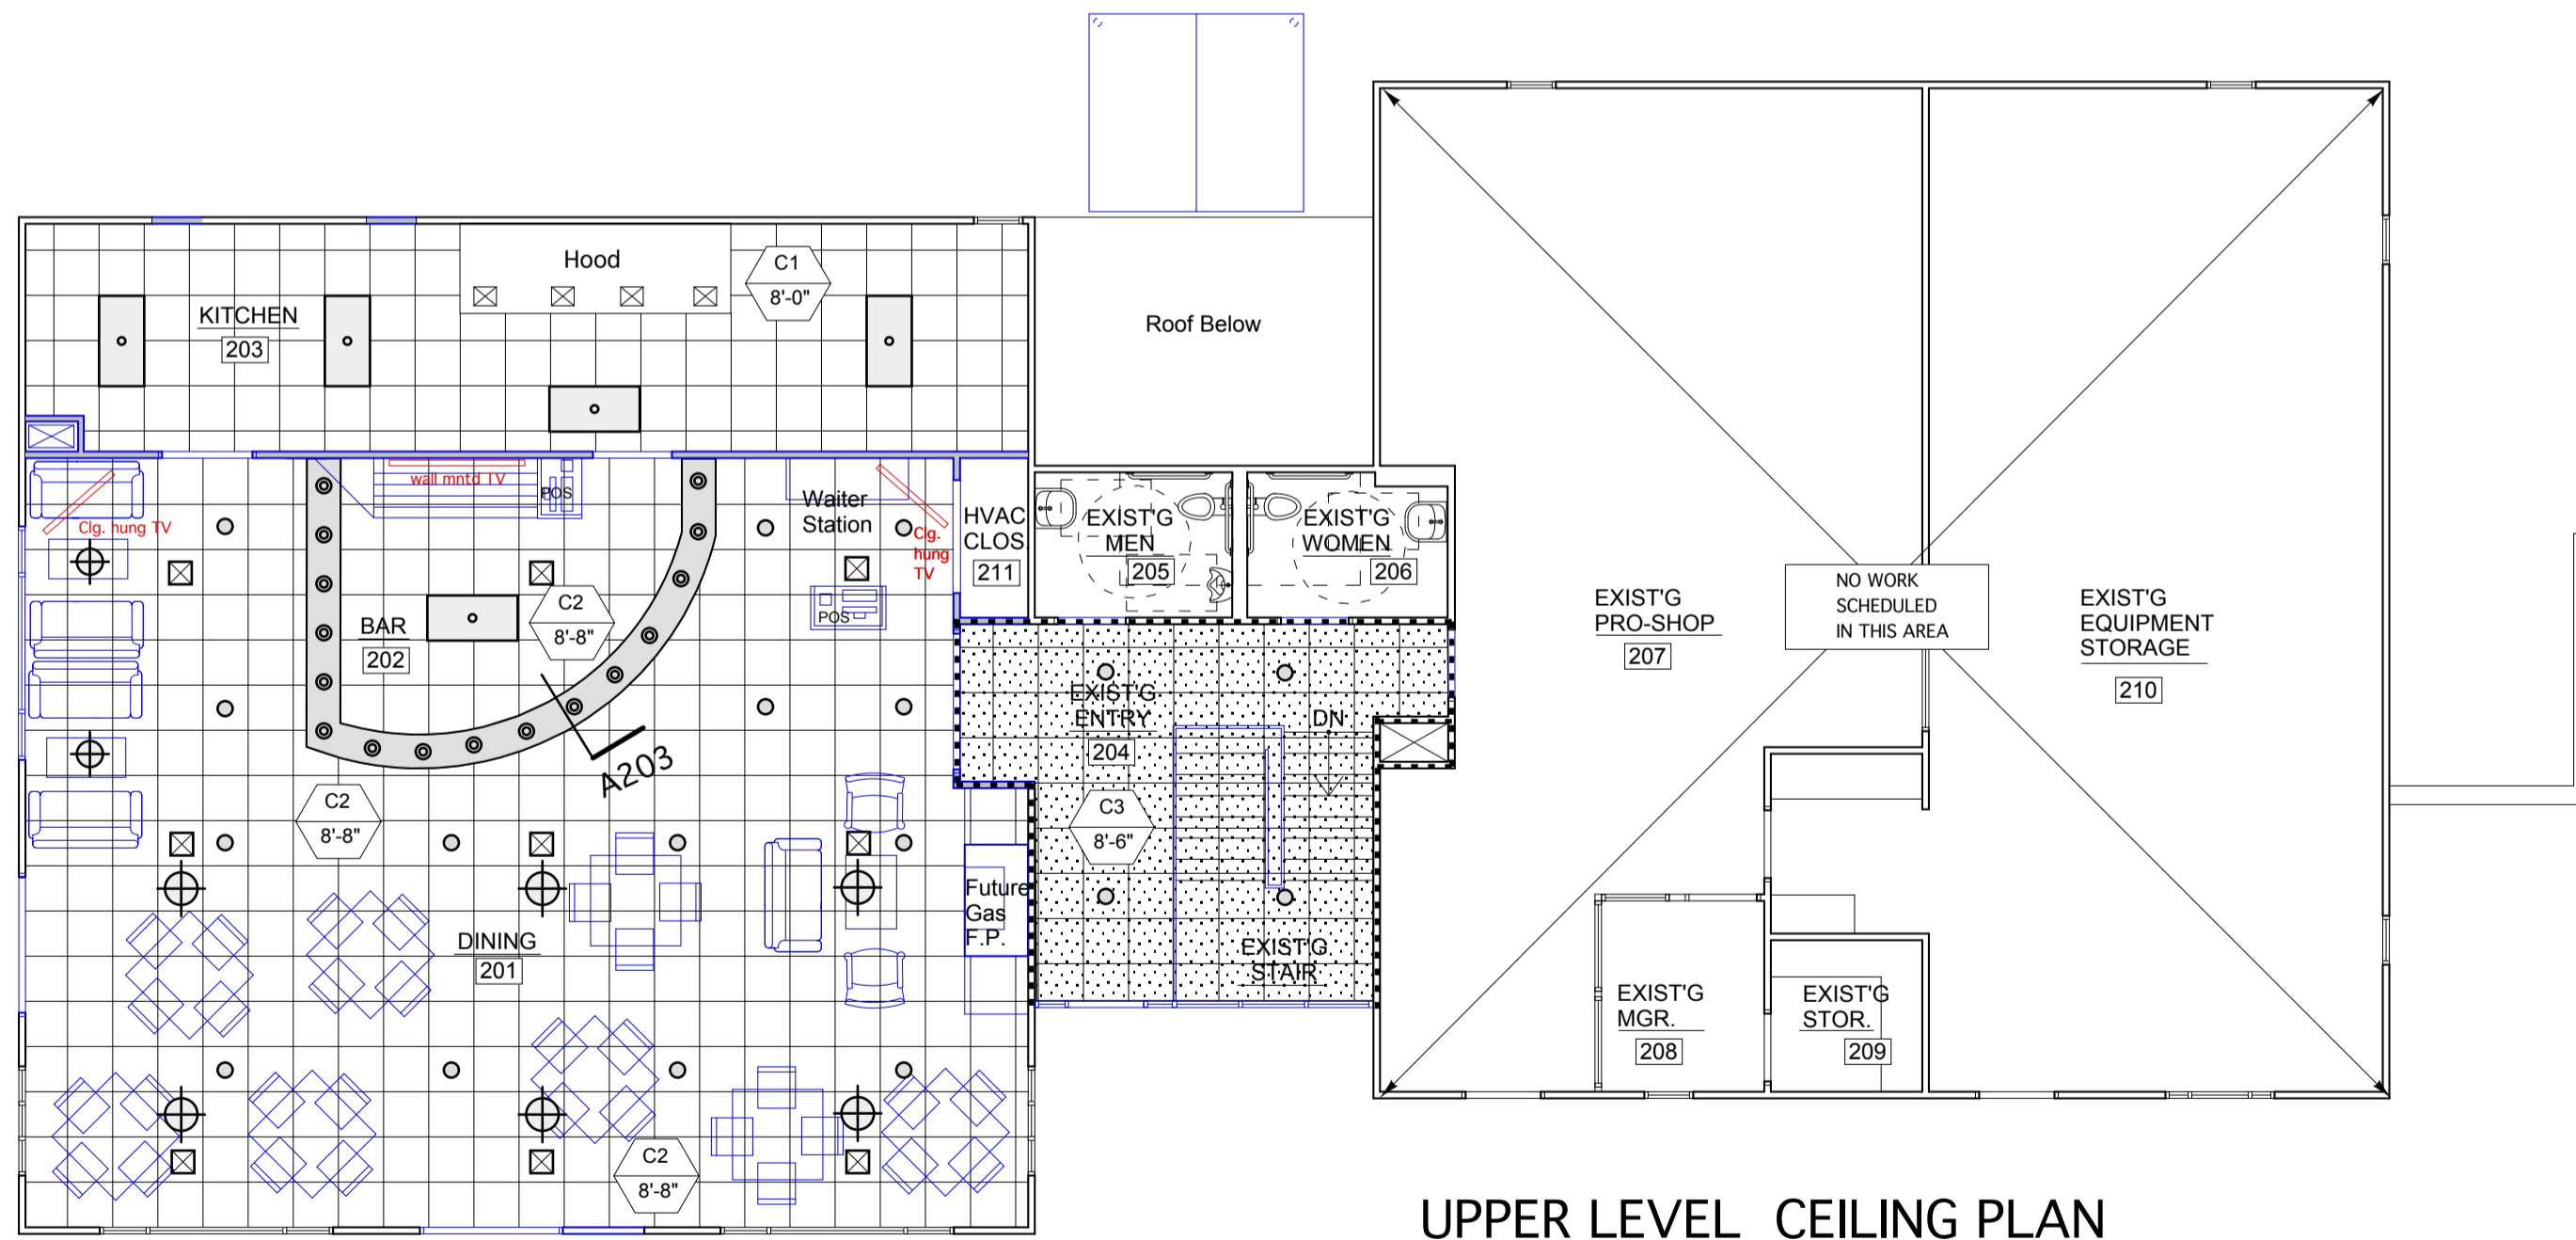

UPPER LEVEL CEILING PLAN

1/8"=1'-0"

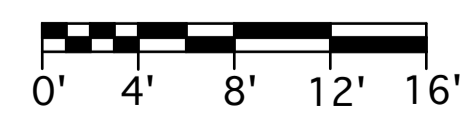

CEILING LEGEND

	Indicates ceiling type Indicates ceiling height from finish floor to underside of ceiling finish
	Suspended acoustical ceiling tiles.
	Suspended acoustical ceiling tiles. w/ 1 HOUR RATED GWB on framing above
	Painted 1 hour rated GWB ceiling
	Painted GWB Soffit- See details
	Exposed Structure

CEILING TYPES

C1	Suspended acoustical ceiling tiles. Scrubbable Type approved for use in food service areas.
C2	Suspended acoustical ceiling tiles.
C3	Suspended acoustical ceiling tiles. w/ 1 HOUR RATED GWB ceiling on wood roof trusses. UL Des L538: RC-1 mtl resilient channels at 16" o.c. run across bottom chord of trusses with 5/8" Fire Core GWB w/ finished joints.
C4	Suspended acoustical ceiling tiles. w/ 1 HOUR RATED GWB ceiling on wood floor joists above. GA File # FC 5406: (2) layers 5/8" Fire Core GWB attached to underside of joists. Offset joints on 2nd layer 24" from first layer. Finish joints.
C5	1 HOUR RATED GWB ceiling on wood floor joists above. GA File # FC 5406: (2) layers 5/8" Fire Core GWB attached to underside of joists. Offset joints on 2nd layer 24" from first layer. Finish joints.
C6	Exposed Existing wood joists

LIGHT FIXTURES LEGEND


FIXTURES ARE SHOWN FOR COORDINATION PURPOSES ONLY. LAYOUT IS NOT EXTENSIVE. REFER TO ELECTRICAL DRAWINGS AND SPECIFICATIONS FOR MORE DETAILS.

	RECESSED, LENSED LED FIXTURE.
	SURFACE MNTD LED FIXTURE.
	PENDANT LED FIXTURE.
	RECESSED LED DOWNLIGHT FIXTURE.
	SURFACE MNTD. LED FIXTURE.

MECHANICAL LEGEND

EQUIPMENT IS SHOWN FOR COORDINATION PURPOSES ONLY. LAYOUT IS NOT EXTENSIVE. REFER TO MECHANICAL DRAWINGS AND SPECIFICATIONS FOR MORE DETAILS.

	AIR SUPPLY GRILLE OR EXHAUST REGISTER. SEE MECH.
	AIR RETURN GRILLE OR EXHAUST REGISTER. SEE MECH.

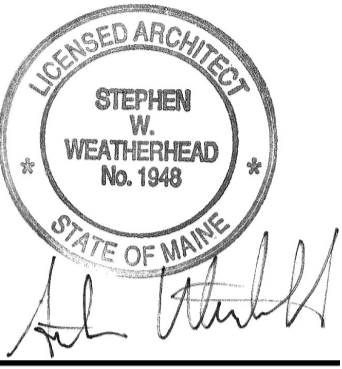

HVAC & plumbing Engineering:
MECHANICAL SYSTEMS ENGINEERS

Electrical Engineering:
SWIFT CURRENT ENGINEERING

Food Service Design Consultant:
TJM CONSULTING

Riverside Golf Course - North Course Club House Renovations

Riverside Street
Portland, Maine

REVISIONS

PERMIT DOCUMENTS
January 29, 2014

Reflected Ceiling Plans

Scale: As Noted