

HVAC & plumbing Engineering:
MECHANICAL SYSTEMS ENGINEERS

Electrical Engineering:
SWIFT CURRENT ENGINEERING

Riverside Golf Course - North Course Club House Renovations PHASE II

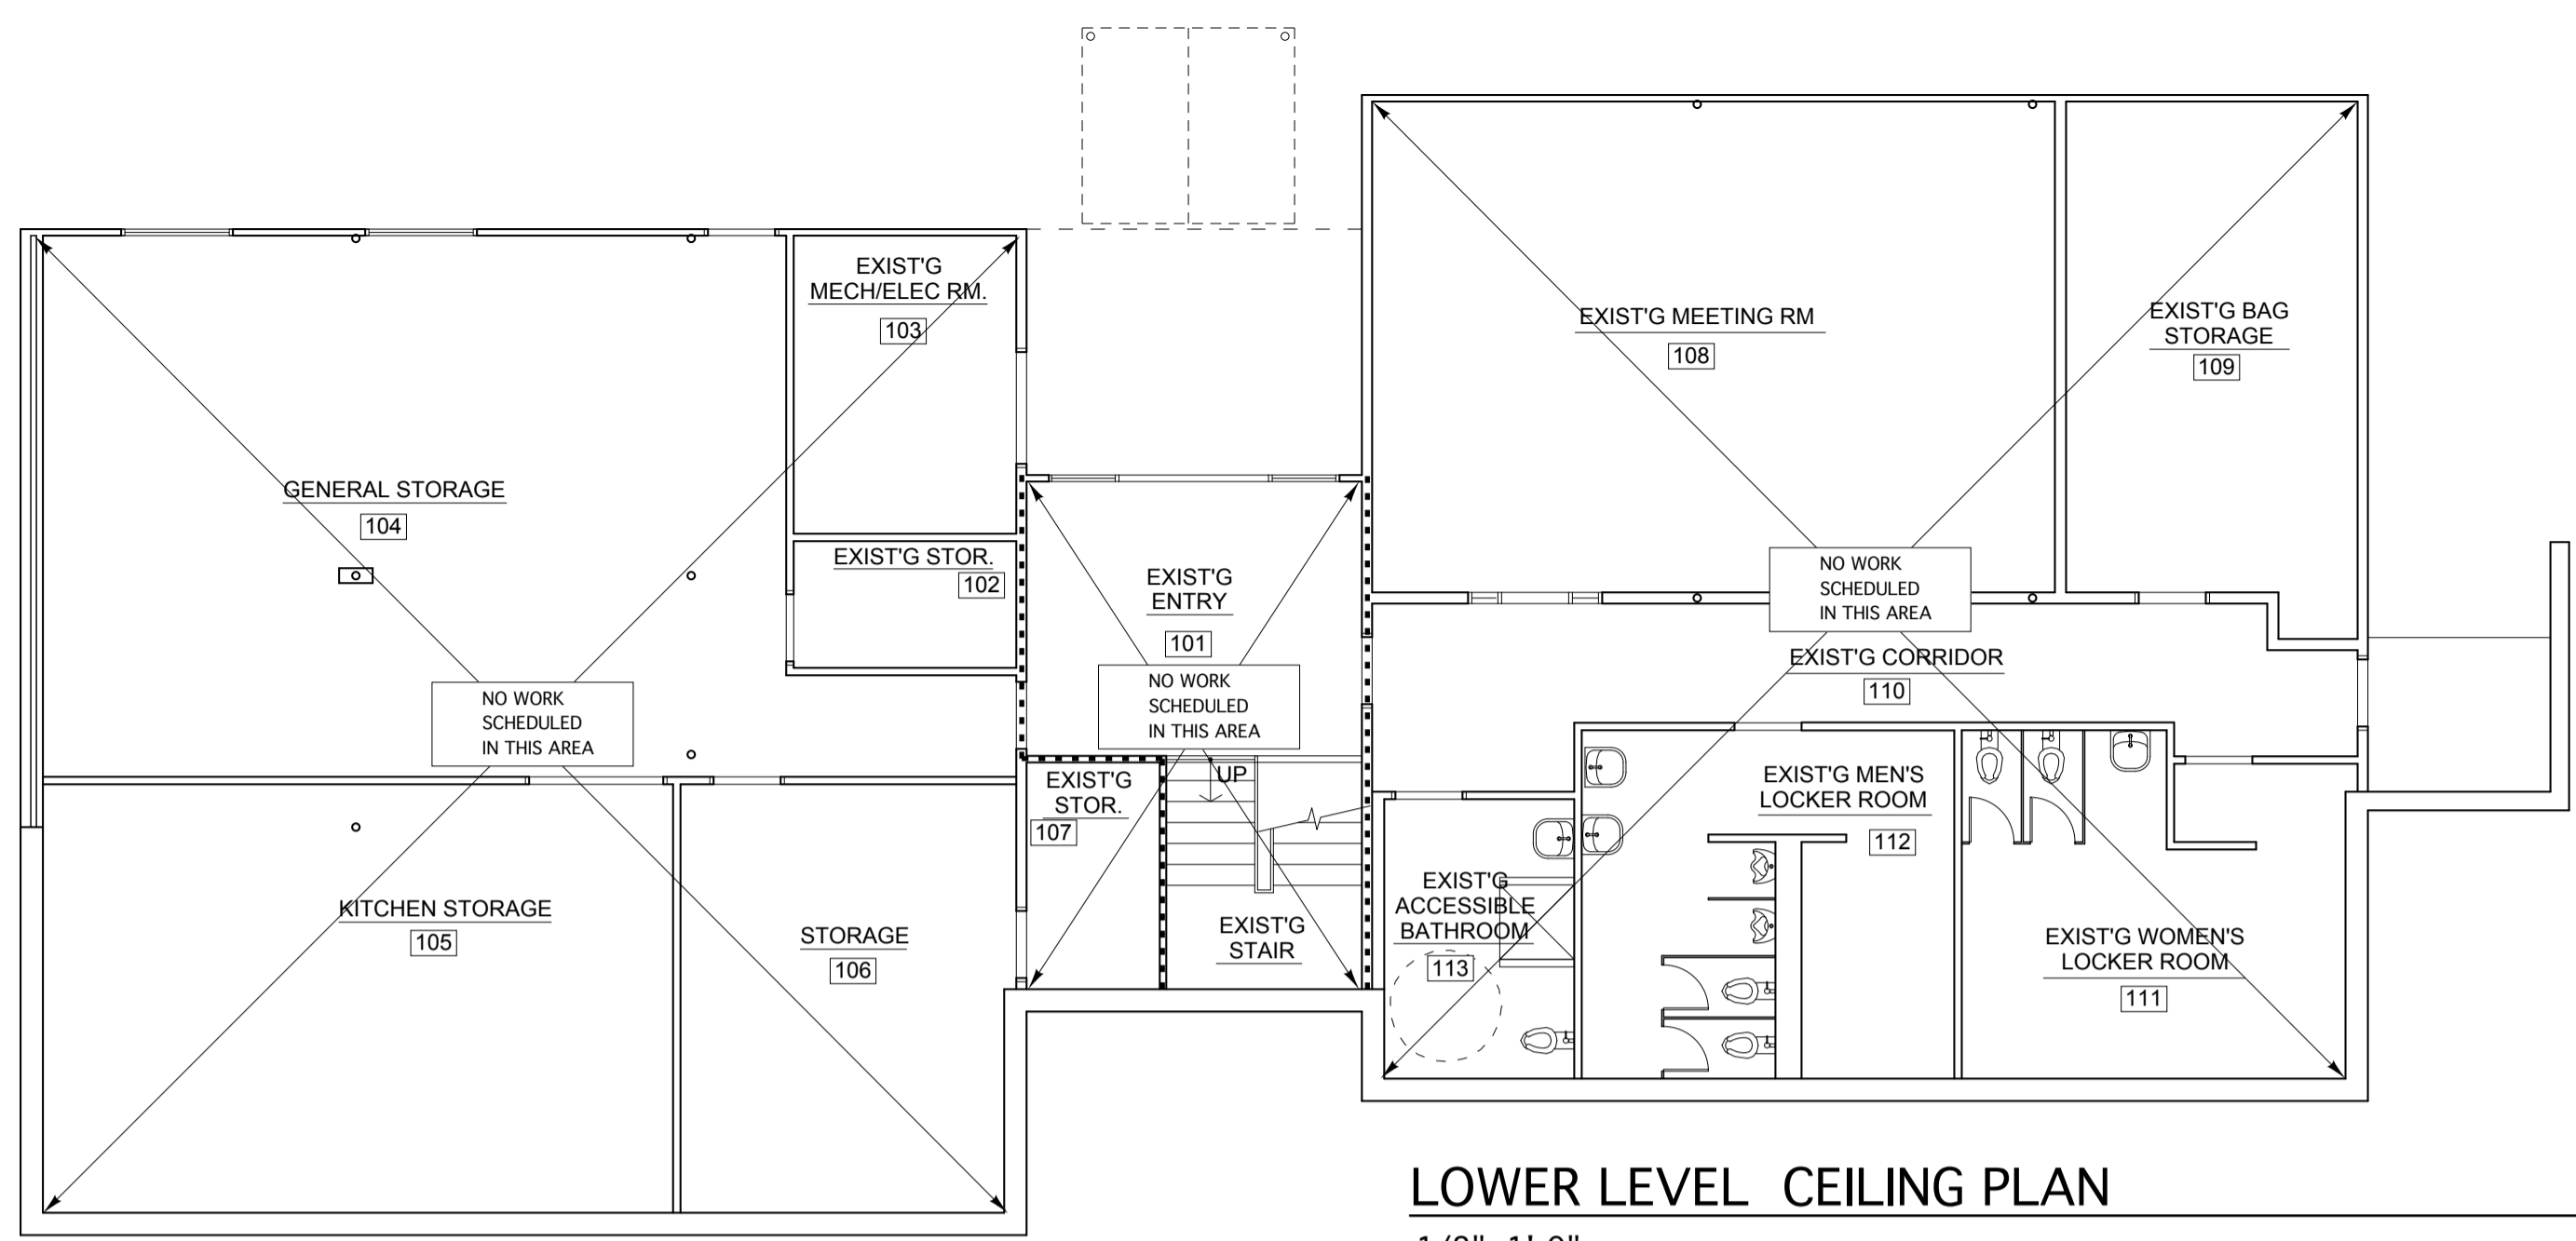
Riverside Street
Portland, Maine

REVISIONS

PERMIT DOCUMENTS
JANUARY 16, 2015

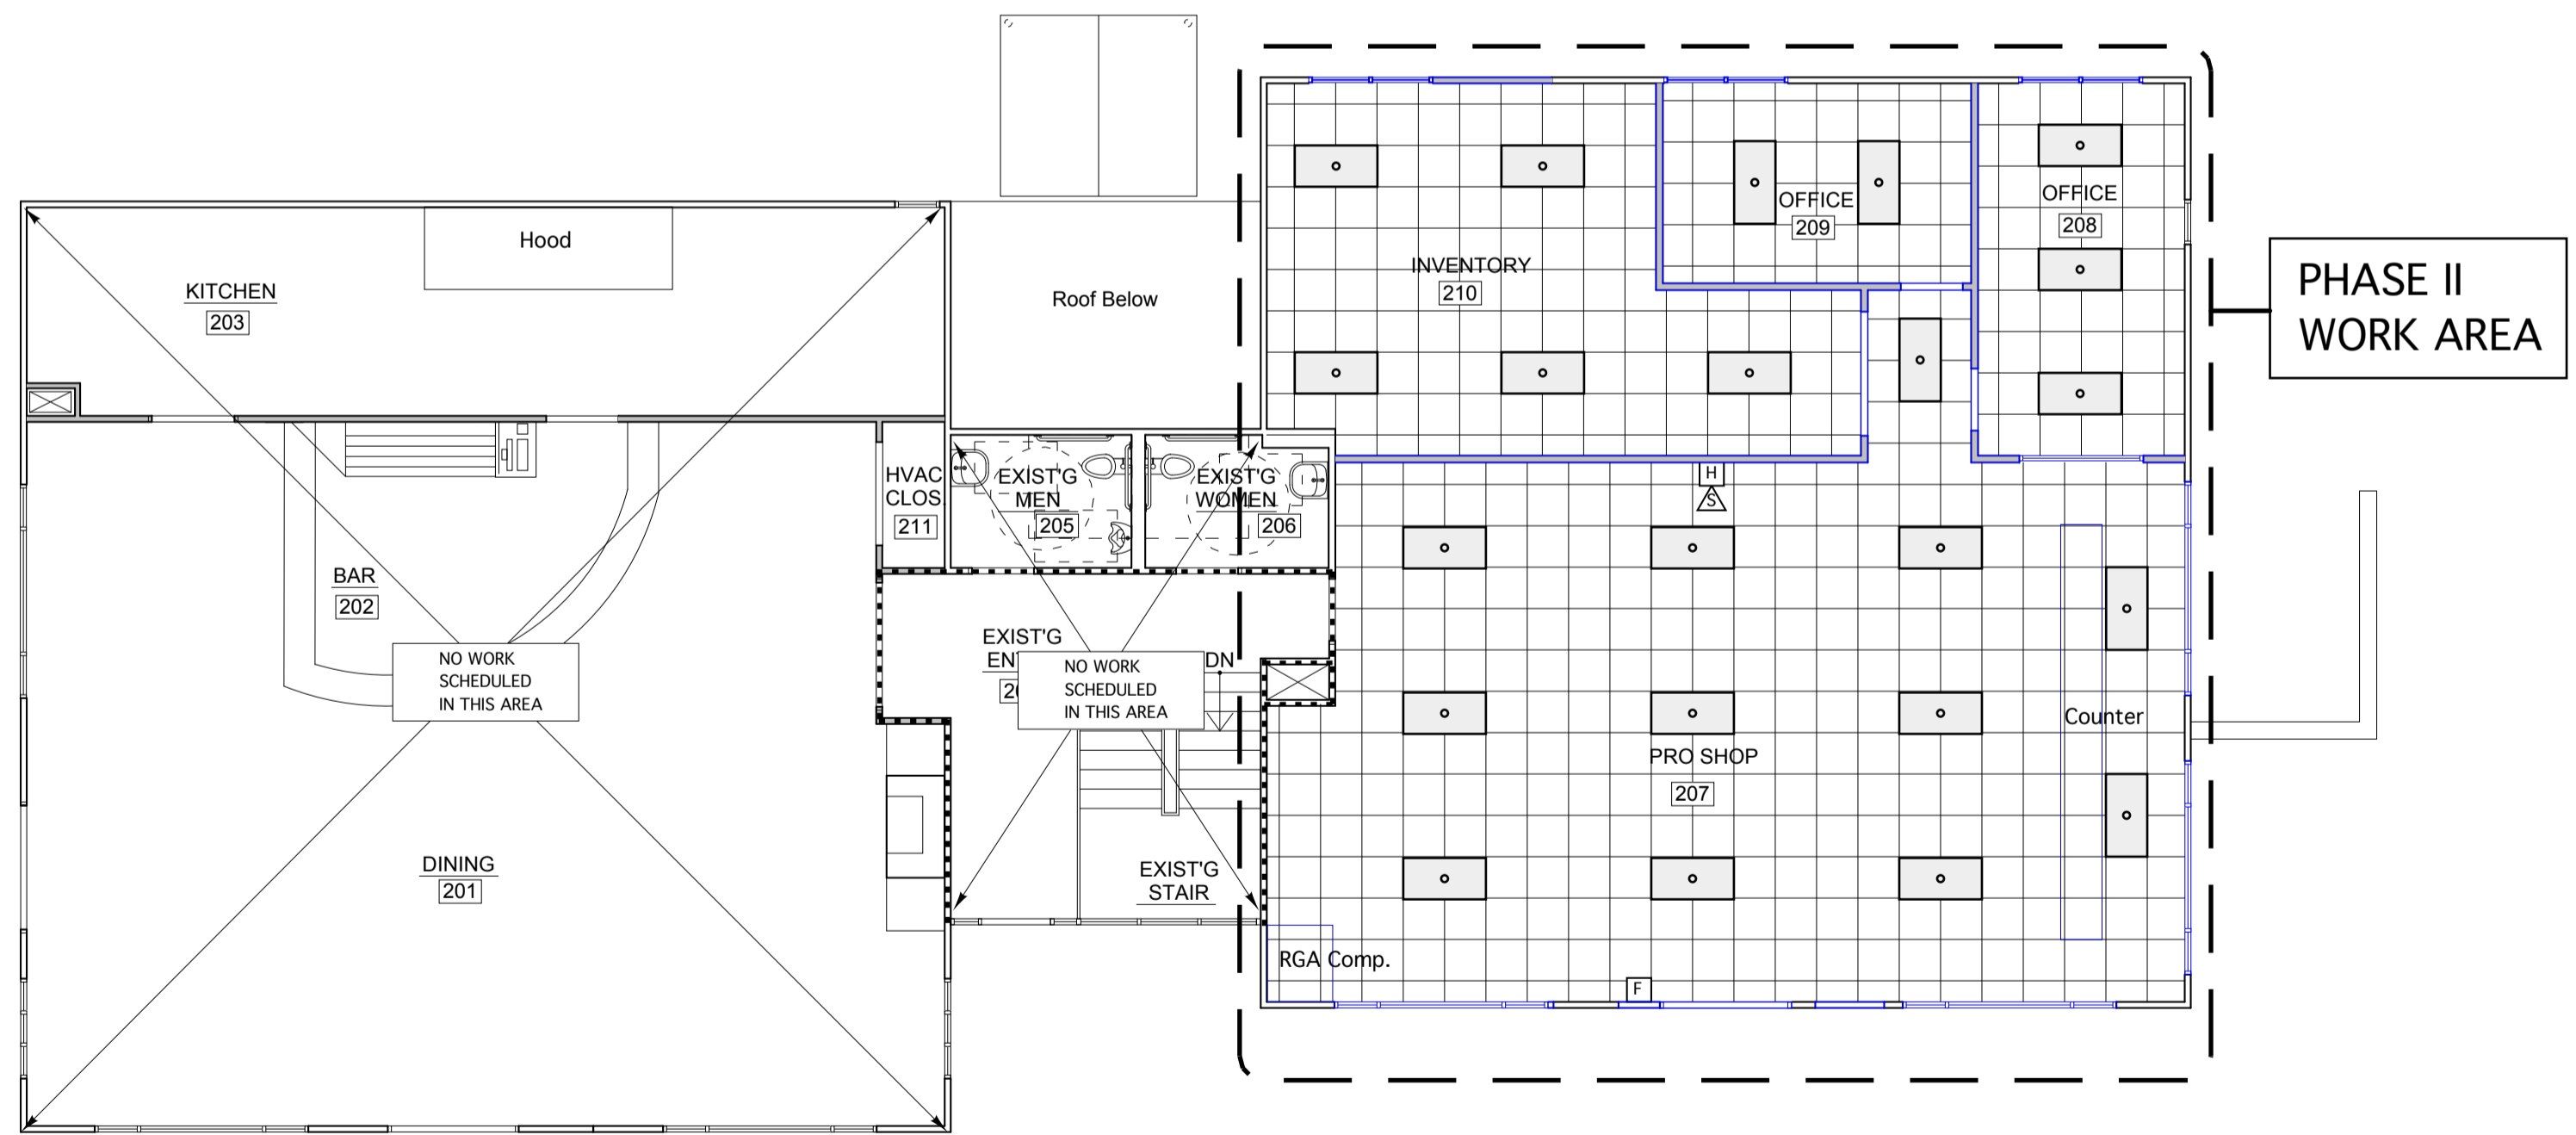
Reflected Ceiling Plans

Scale: As Noted



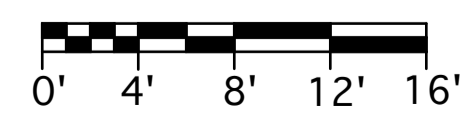
LOWER LEVEL CEILING PLAN

1/8"=1'-0"

 
 



UPPER LEVEL CEILING PLAN

1/8"=1'-0"



CEILING LEGEND

 

 


-  Indicates ceiling type
Indicates ceiling height from finish floor to underside of ceiling finish
-  Suspended acoustical ceiling tiles.
-  Painted GWB Soffit- See details

CEILING TYPES

- C1 Suspended acoustical ceiling tiles.

 
 
LIGHT FIXTURES LEGEND

FIXTURES ARE SHOWN FOR COORDINATION PURPOSES ONLY. LAYOUT IS NOT EXTENSIVE. REFER TO ELECTRICAL DRAWINGS AND SPECIFICATIONS FOR MORE DETAILS.

 
 
-  RECESSED, LENSED LED FIXTURE.
-  SURFACE MNTD LED FIXTURE.
-  PENDANT LED FIXTURE.
-  RECESSED LED DOWNLIGHT FIXTURE.
-  SURFACE MNTD. LED FIXTURE.

MECHANICAL LEGEND

EQUIPMENT IS SHOWN FOR COORDINATION PURPOSES ONLY. LAYOUT IS NOT EXTENSIVE. REFER TO MECHANICAL DRAWINGS AND SPECIFICATIONS FOR MORE DETAILS.

-  AIR SUPPLY GRILLE OR EXHAUST REGISTER. SEE MECH.
-  AIR RETURN GRILLE OR EXHAUST REGISTER. SEE MECH.

FIRE ALARM LEGEND

-  FIRE ALARM AUDIBLE/VISIBLE NOTIFICATION APPLIANCE (GENERAL EVACUATION)
-  FIRE ALARM PULL STATION