

**Riverside  
Golf Course -  
North Course  
Club House  
Renovations**

Riverside Street  
Portland, Maine

REVISIONS


CONTRACT  
DOCUMENTS  
February 03, 2014

**Lower Level  
Mechanical  
Plan**

Noted

**M1**

ALL PIPING, BOILER VENTS  
AND DUCTWORK ARE SHOWN  
DIAGRAMMATICALLY AND ALL  
THE OFFSETS THAT WILL BE  
REQUIRED ARE NOT SHOWN.

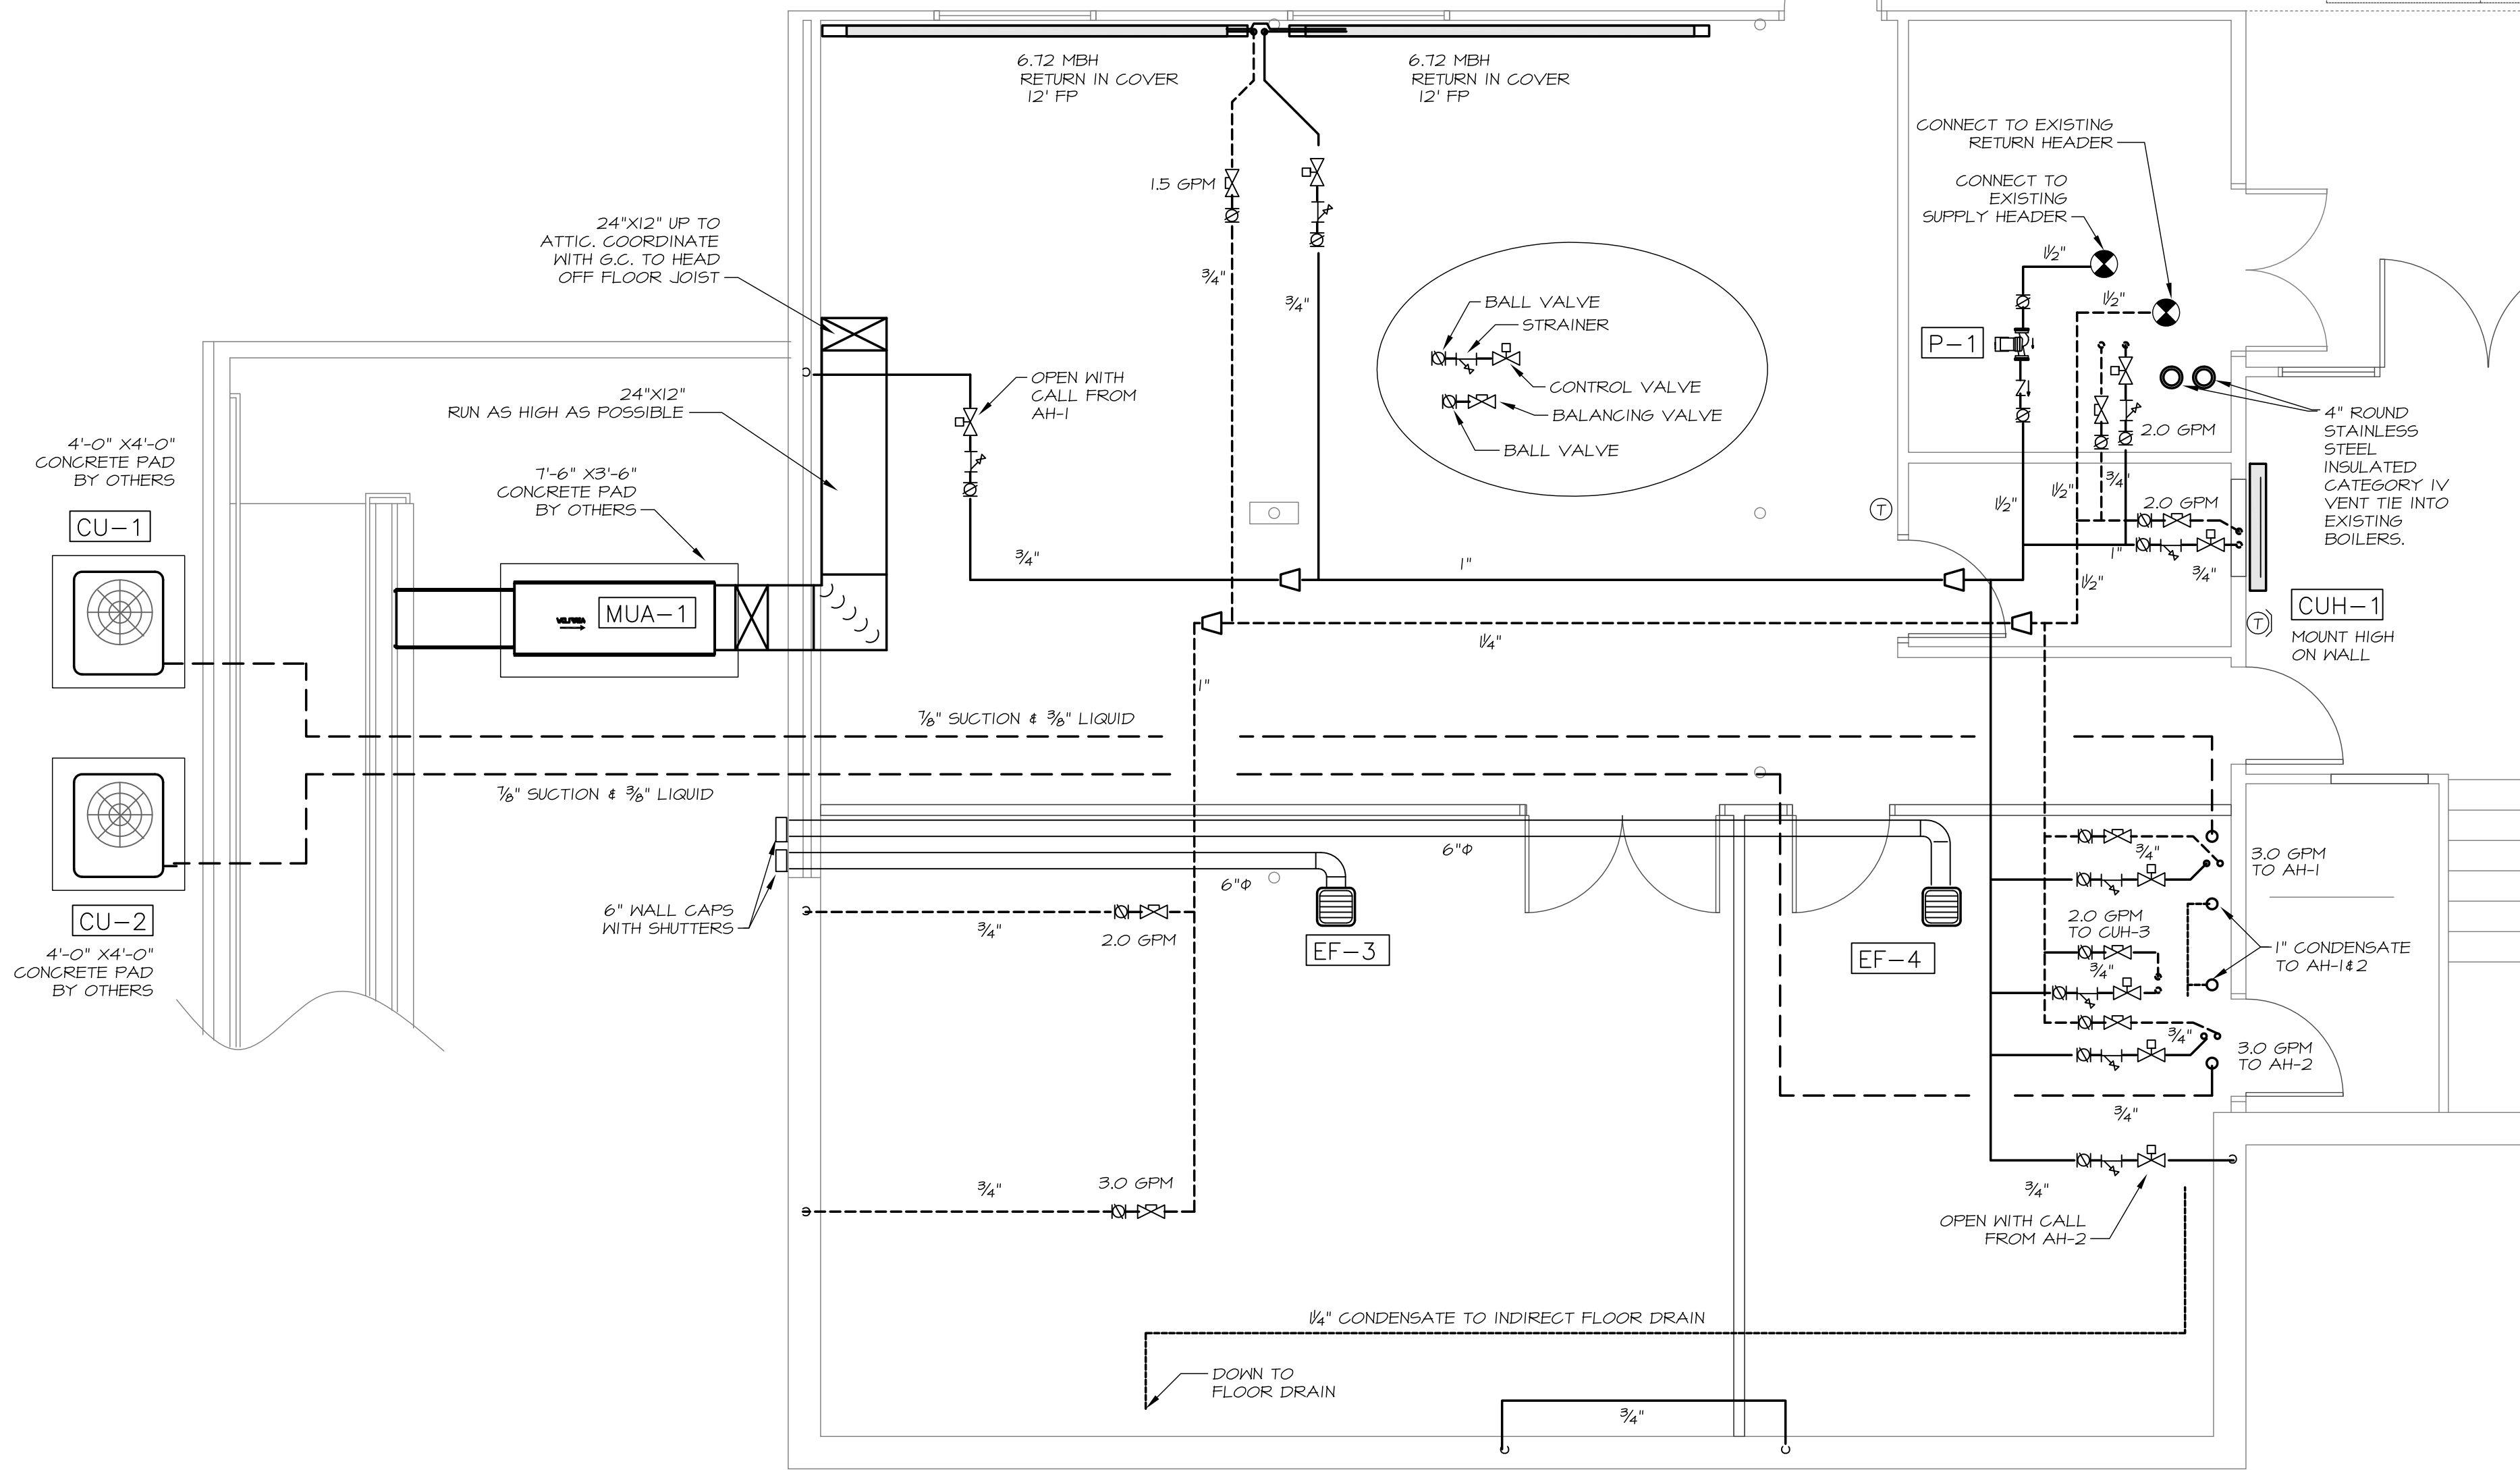

**1 LOWER LEVEL MECHANICAL PLAN**  
SCALE: 1/4" = 1'-0"



**MECHANICAL SYSTEMS ENGINEERS**  
ROYAL RIVER CENTER, UNIT #10  
10 FOREST FALLS DRIVE  
YARMOUTH, MAINE 04096  
FACEBOOK: MECHANICAL SYSTEMS ENGINEERS  
207-846-1441  
M.S.E. Proj. 1334  
© COPYRIGHT 2014