

REVISIONS

Bunker & Savage Architects  
 P.O. Box 2387  
 Augusta, Maine  
 Tele. (207) 623-4708  
 E-Mail Address: bsarch@bunkerandsavage.com


 

 





 


BSA


Verizon - Construction Services  
 Boston, Ma.  
 125 High Street  
 Verizon

Verizon - Construction Services  
 1 DAVIS FARM  
 2nd Floor Renovation  
 Portland, Maine  
 FLOOR PLAN

Drawing No.  
 M1

**SYMBOLS AND ABBREVIATIONS**

-  FLEX DUCT 10 FT LENGTH UNLESS NOTED OTHERWISE
-  CEILING MOUNTED DIFFUSER
-  CEILING MOUNTED RET/EXH REGISTER
-  METAL DUCT WITH OPPOSED BLADE BALANCE DAMPER
-  DUCT INCREASER OR REDUCER
-  ROOM AIR TEMPERATURE SENSOR
-  NON-PENETRATING ROOF MOUNTED PIPE SUPPORT
-  GAS COCK
-  EXHAUST REGISTER
-  RETURN REGISTER
-  SUPPLY DIFFUSER
-  SUPPLY REGISTER

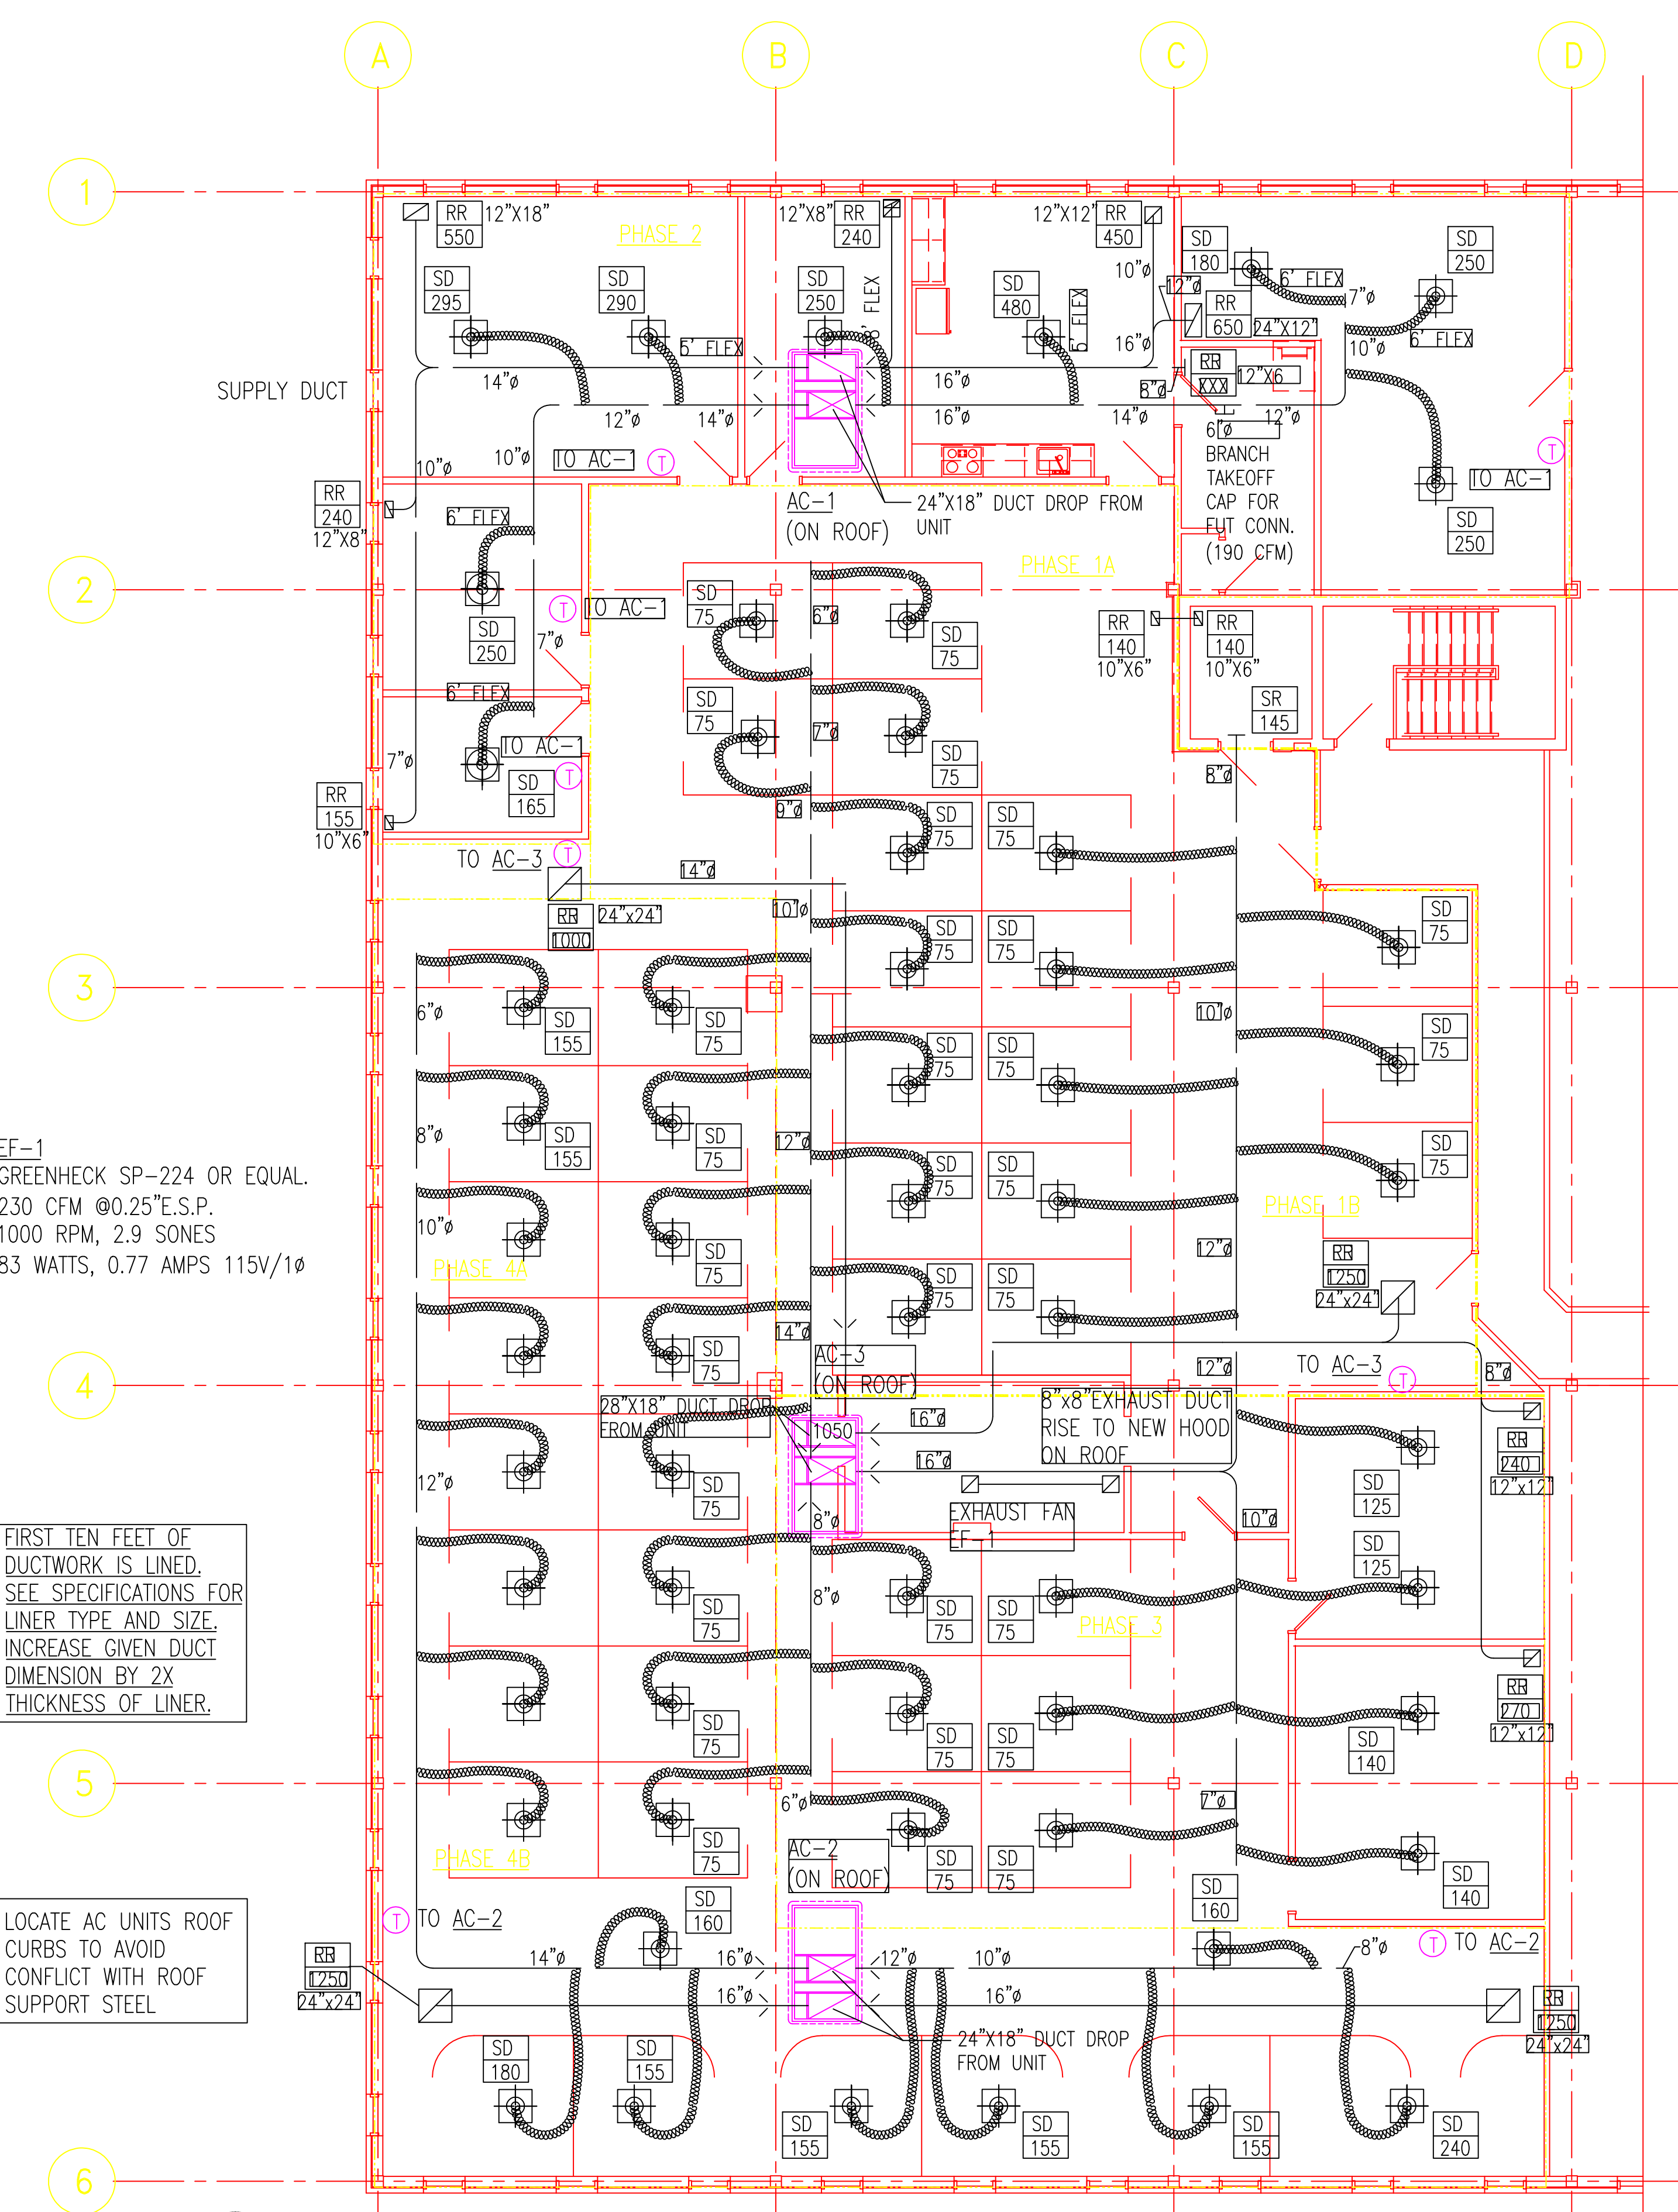

EF-1  
 GREENHECK SP-224 OR EQUAL.  
 230 CFM @0.25"E.S.P.  
 1000 RPM, 2.9 SONES  
 83 WATTS, 0.77 AMPS 115V/1Ø

FIRST TEN FEET OF  
 DUCTWORK IS LINED.  
 SEE SPECIFICATIONS FOR  
 LINER TYPE AND SIZE.  
 INCREASE GIVEN DUCT  
 DIMENSION BY 2X  
 THICKNESS OF LINER.

LOCATE AC UNITS ROOF  
 CURBS TO AVOID  
 CONFLICT WITH ROOF  
 SUPPORT STEEL

WORK SHALL PROCEED IN A  
 PHASED MANNER. SEE PHASE  
 NOTES THIS SHEET AND ON  
 ARCHITECTURAL DRAWINGS



**Renovated Floor Plan - Partial Plan**  
 Scale: 3/32" = 1'-0"

**NG**  
 Neill and Gunter  
 Scarborough, Maine, U.S.A.

