

REVISION	DESCRIPTION	DATE
0	ISSUED FOR REVIEW & APPROVAL	11/1/2013


RESERVED FOR CITY STAMP

CUNNINGHAM
 Security Systems
 10 Princes Point Road, Yarmouth, Maine 04096
 Office: 207.846.3350 • Fax: 207.846.6080

56 ALLISON AVENUE
 PORTLAND, MAINE 04103
 FIRST FLOOR FIRE ALARM PLAN

DRAWN	JPB	UNICAD JOB #13639
CHECKED	WAYNE B. HAWES	NCET # 90496
DATE	10/31/2013	REVISION 0
SCALE	1/4"=1'-0"	

FA-3

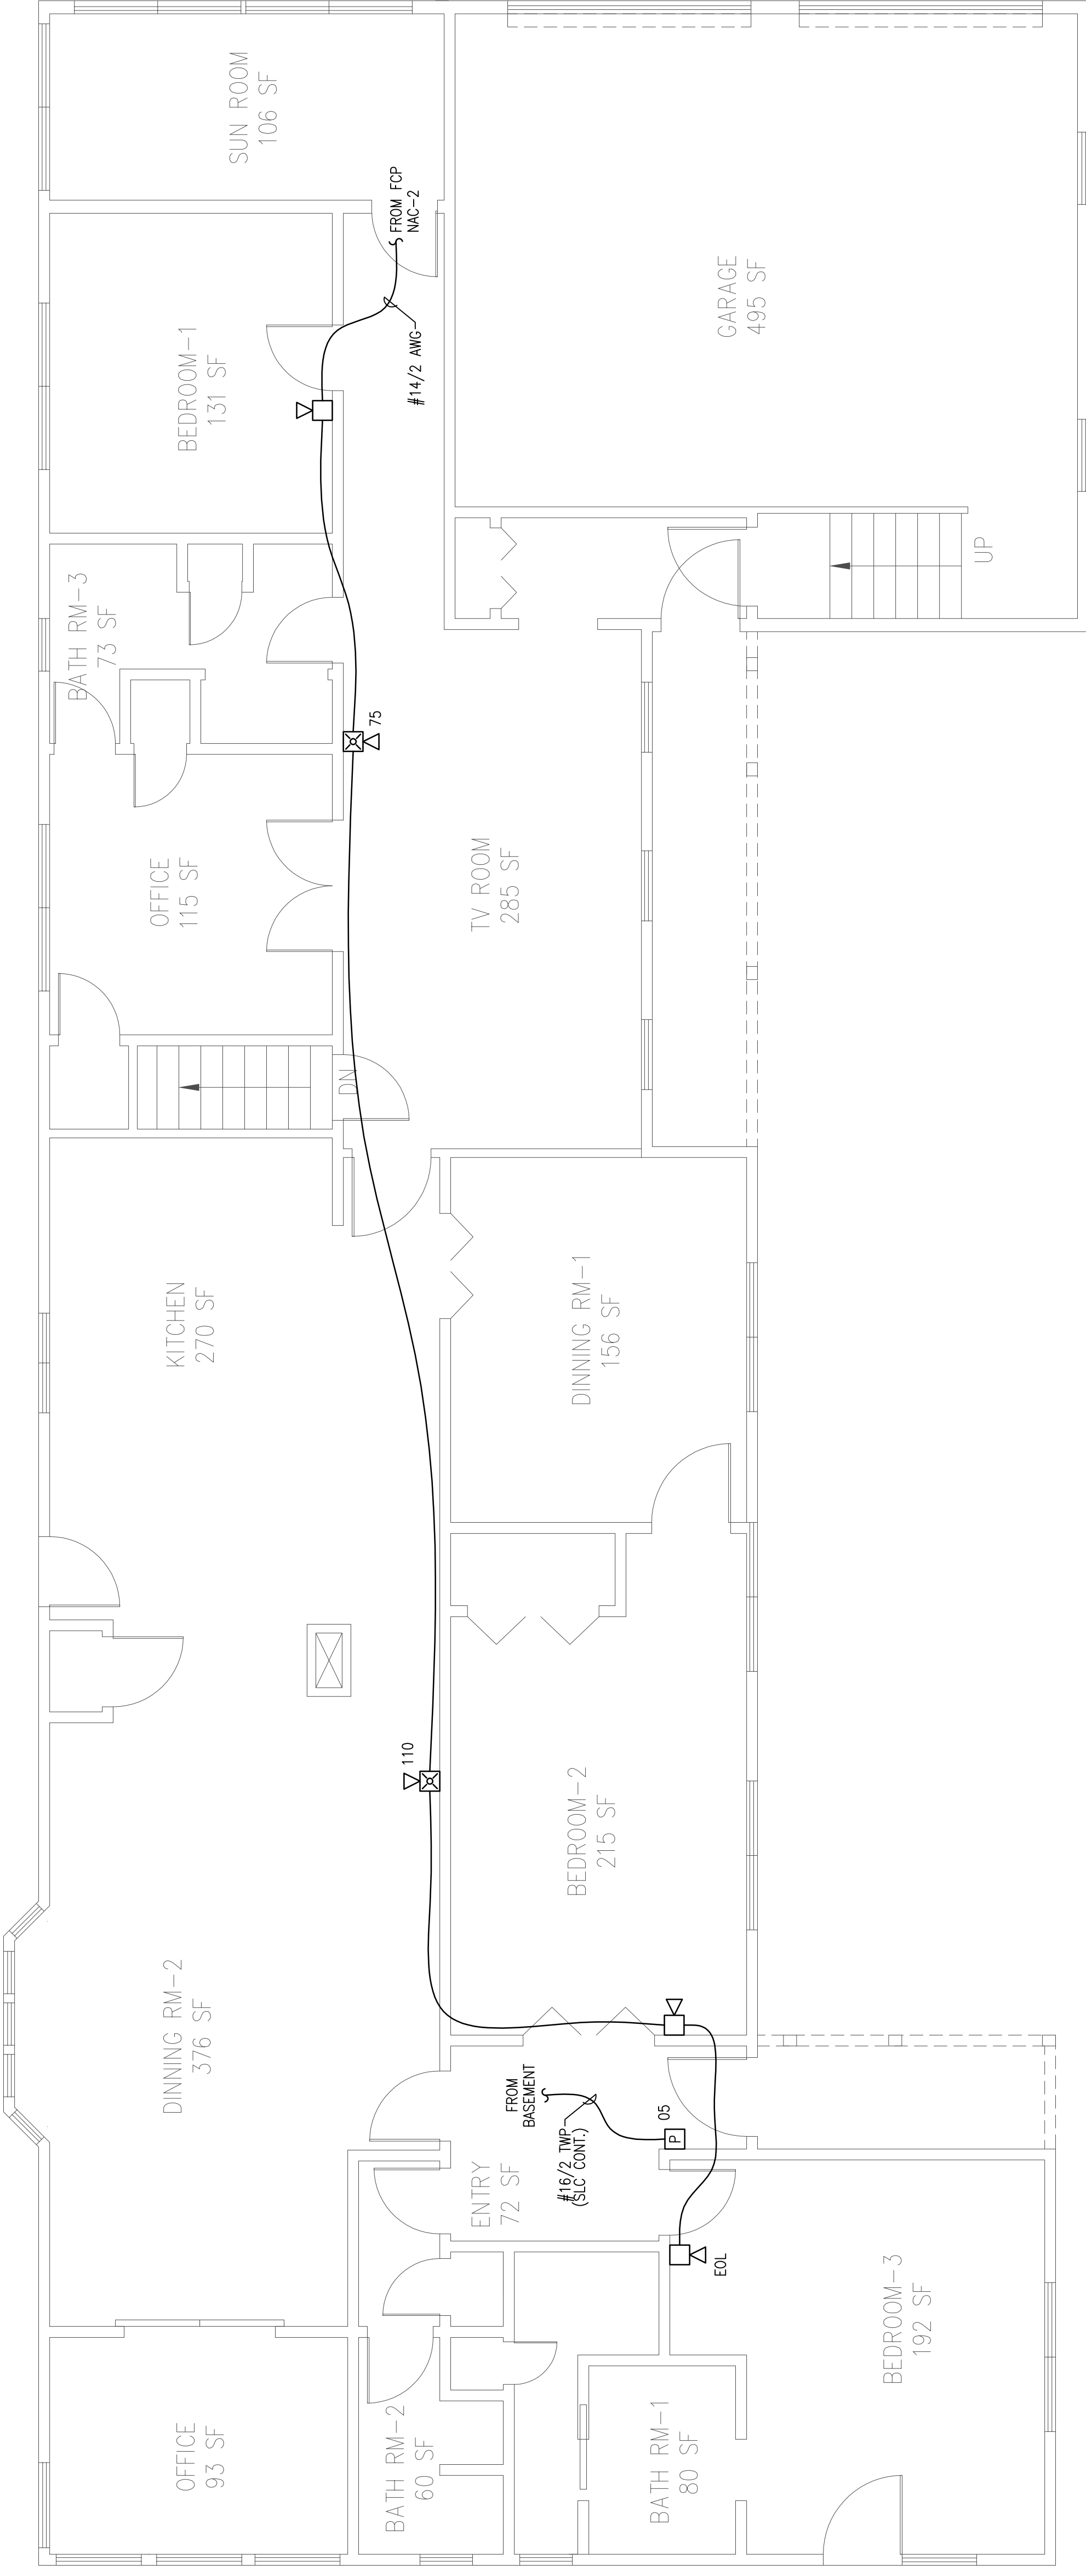

FIRST FLOOR FIRE ALARM PLAN
 SCALE: 1/4"=1'-0"