


1 MECHANICAL HVAC - EXHAUST FAN & HOOD DUCTWORK PLAN
SCALE: 1/8" = 1'-0"

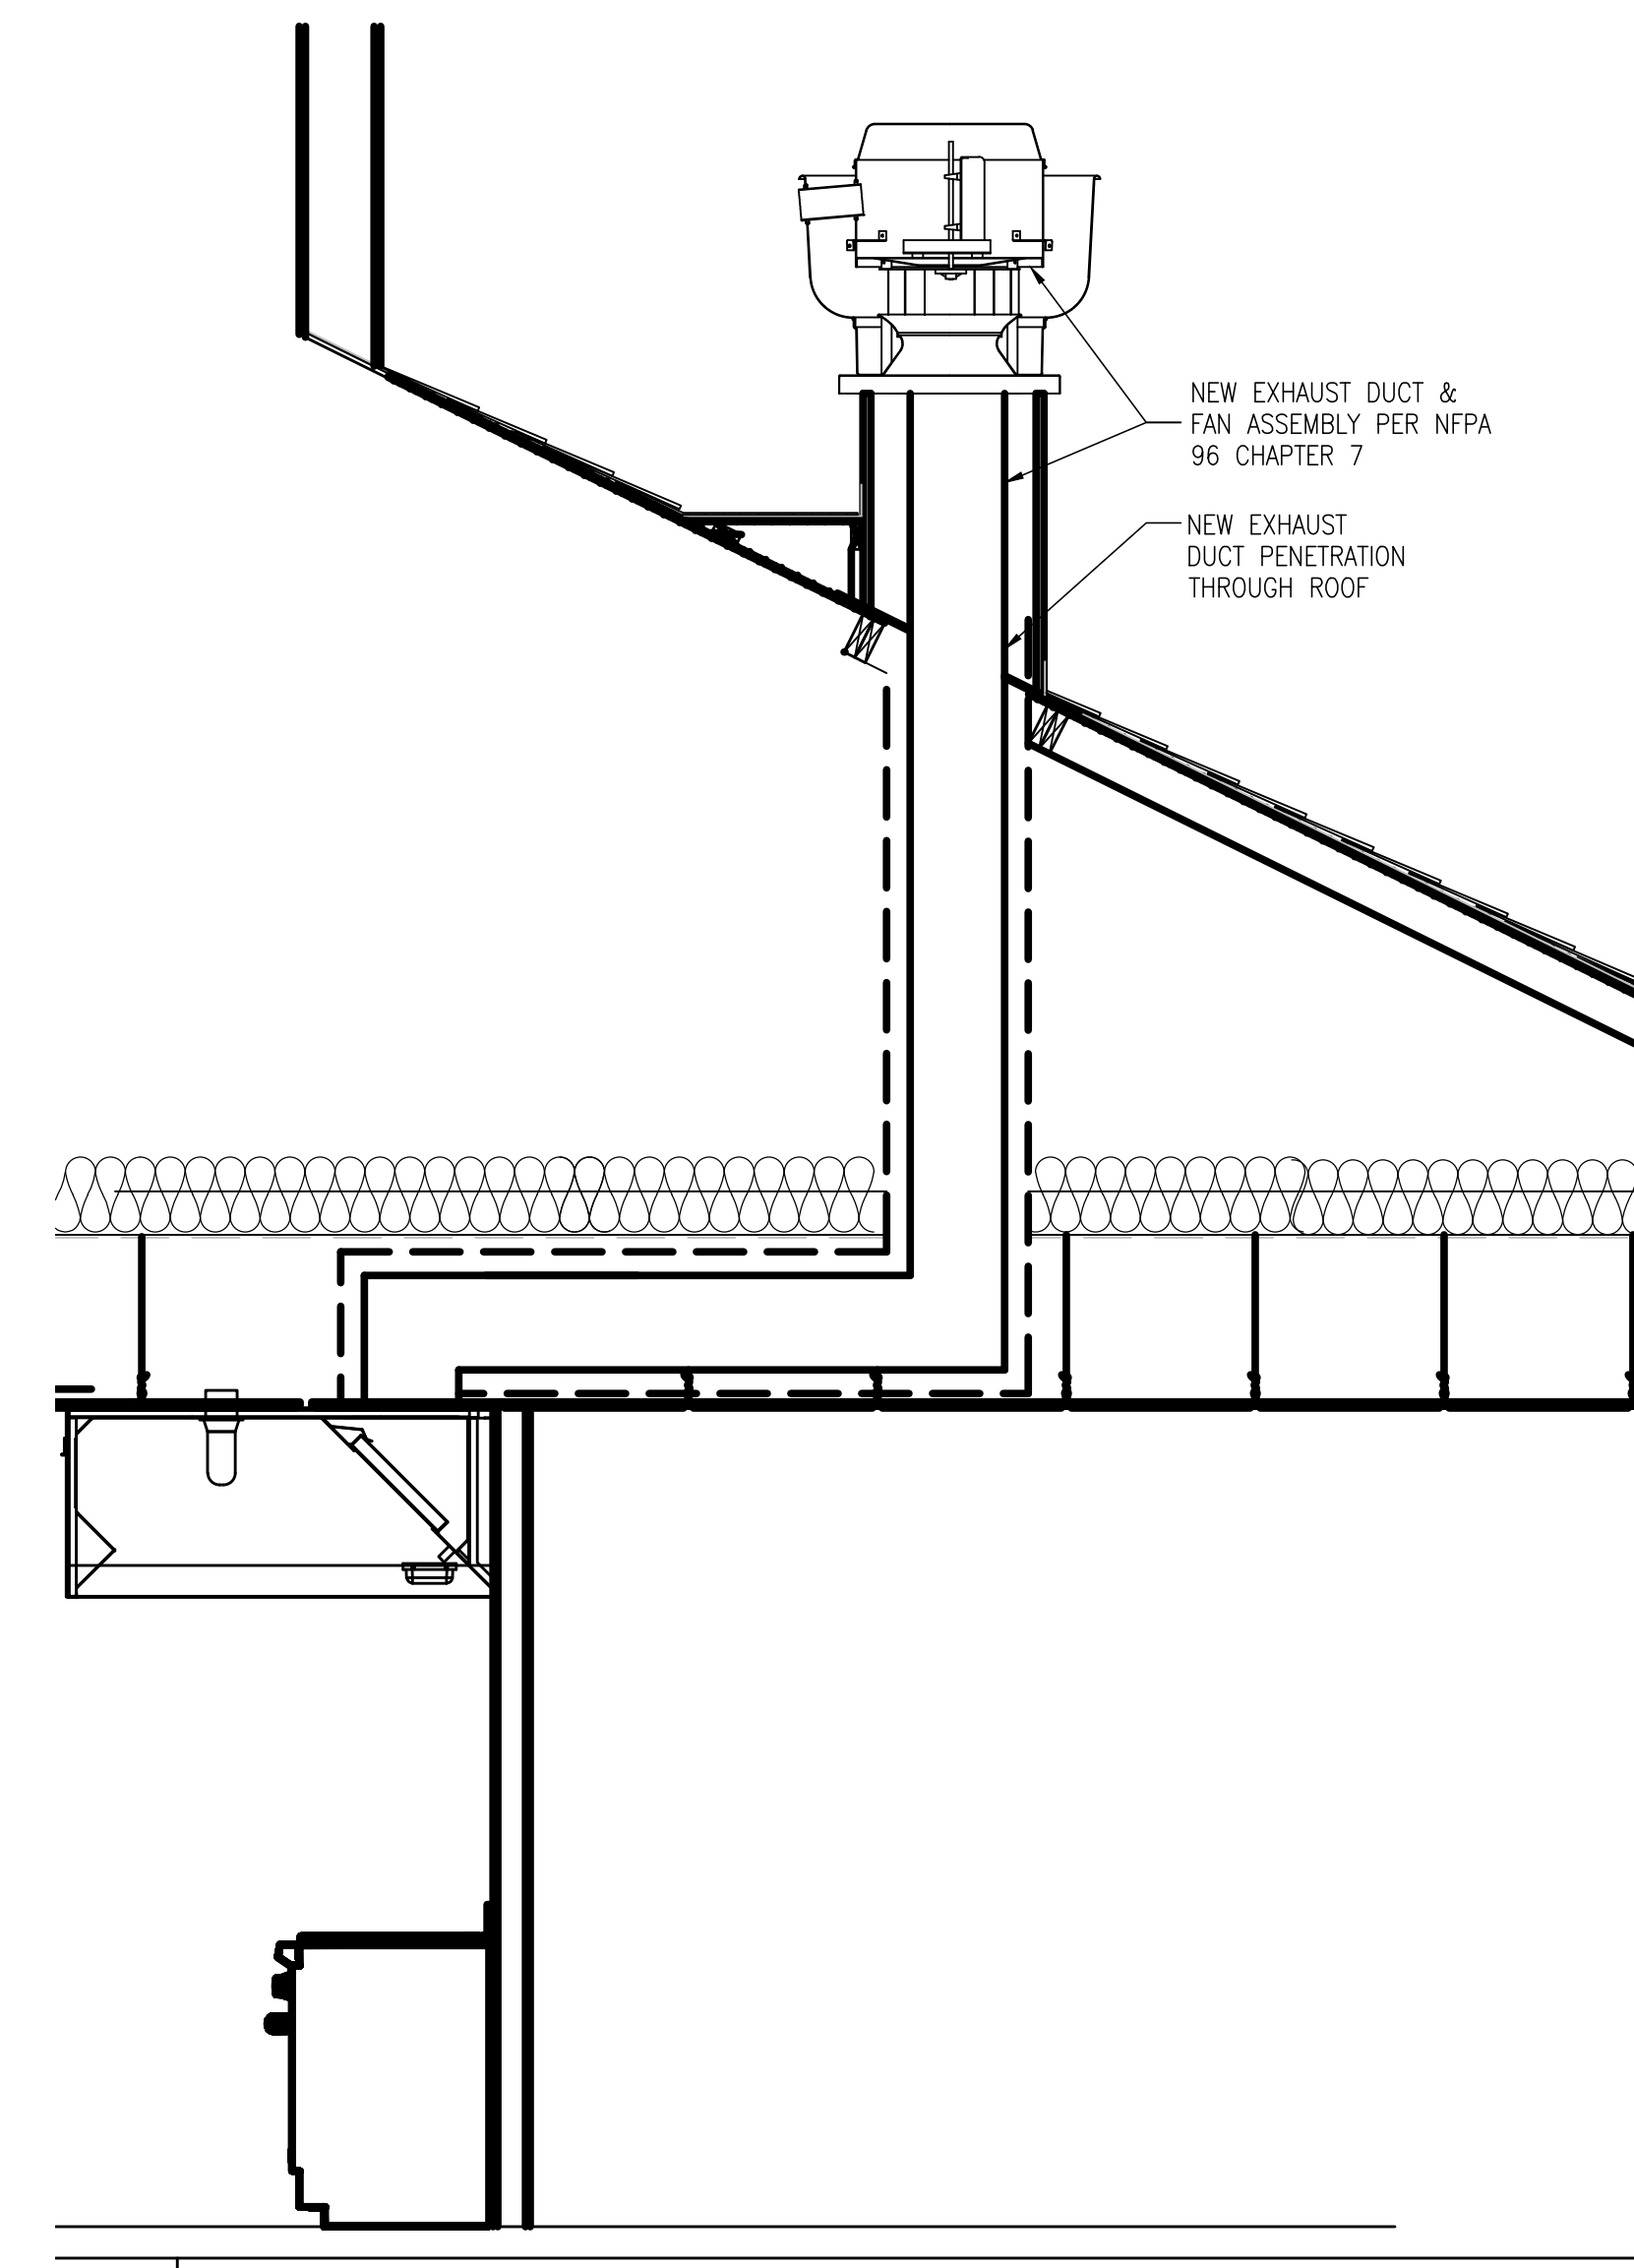


1 MECHANICAL HVAC - EXHAUST FAN & HOOD DETAIL
SCALE: 1/2" = 1'-0"

This document is owned by, and the information contained in it is proprietary to Titan Mechanical Inc. By receipt hereof the holder agrees not to use the information, disclose it to any third party, nor reproduce this document without the prior written consent of Titan Mechanical Inc. and agrees to return this document forthwith upon request.

REVISIONS	DATE

Titan Mechanical, Inc.
Design Build Engineering - Mechanical Contracting
232 Riverside Industrial Parkway
Portland, Maine 04103
Ph. (207) 878-5223 Fax. (207) 878-5235

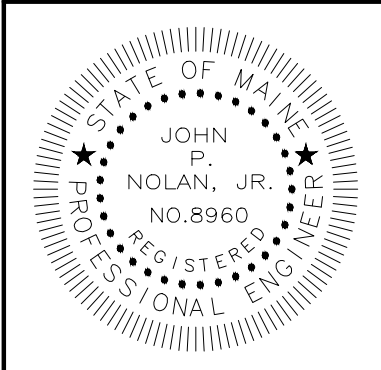

ZACHAU CONSTRUCTION INC.
CLIENT
NEW PORTLAND MORRISON CENTER FIT-UP
PROJECT
EXHAUST FAN & HOOD - DUCTWORK PLAN
DRAWING TITLE

DATE: 03-16-2015

SCALE: 1/8" = 1'-0"

DRAWN BY: KLM

CHECKED BY: JPN

ISSUED FOR:
PERMIT
03-16-2015

SHEET NUMBER

M1.0
SHEET 1 OF 1