


2
A1.4
IT OF WORK
SECOND FLOOR RCP
SCALE: 1/4" = 1'-0"

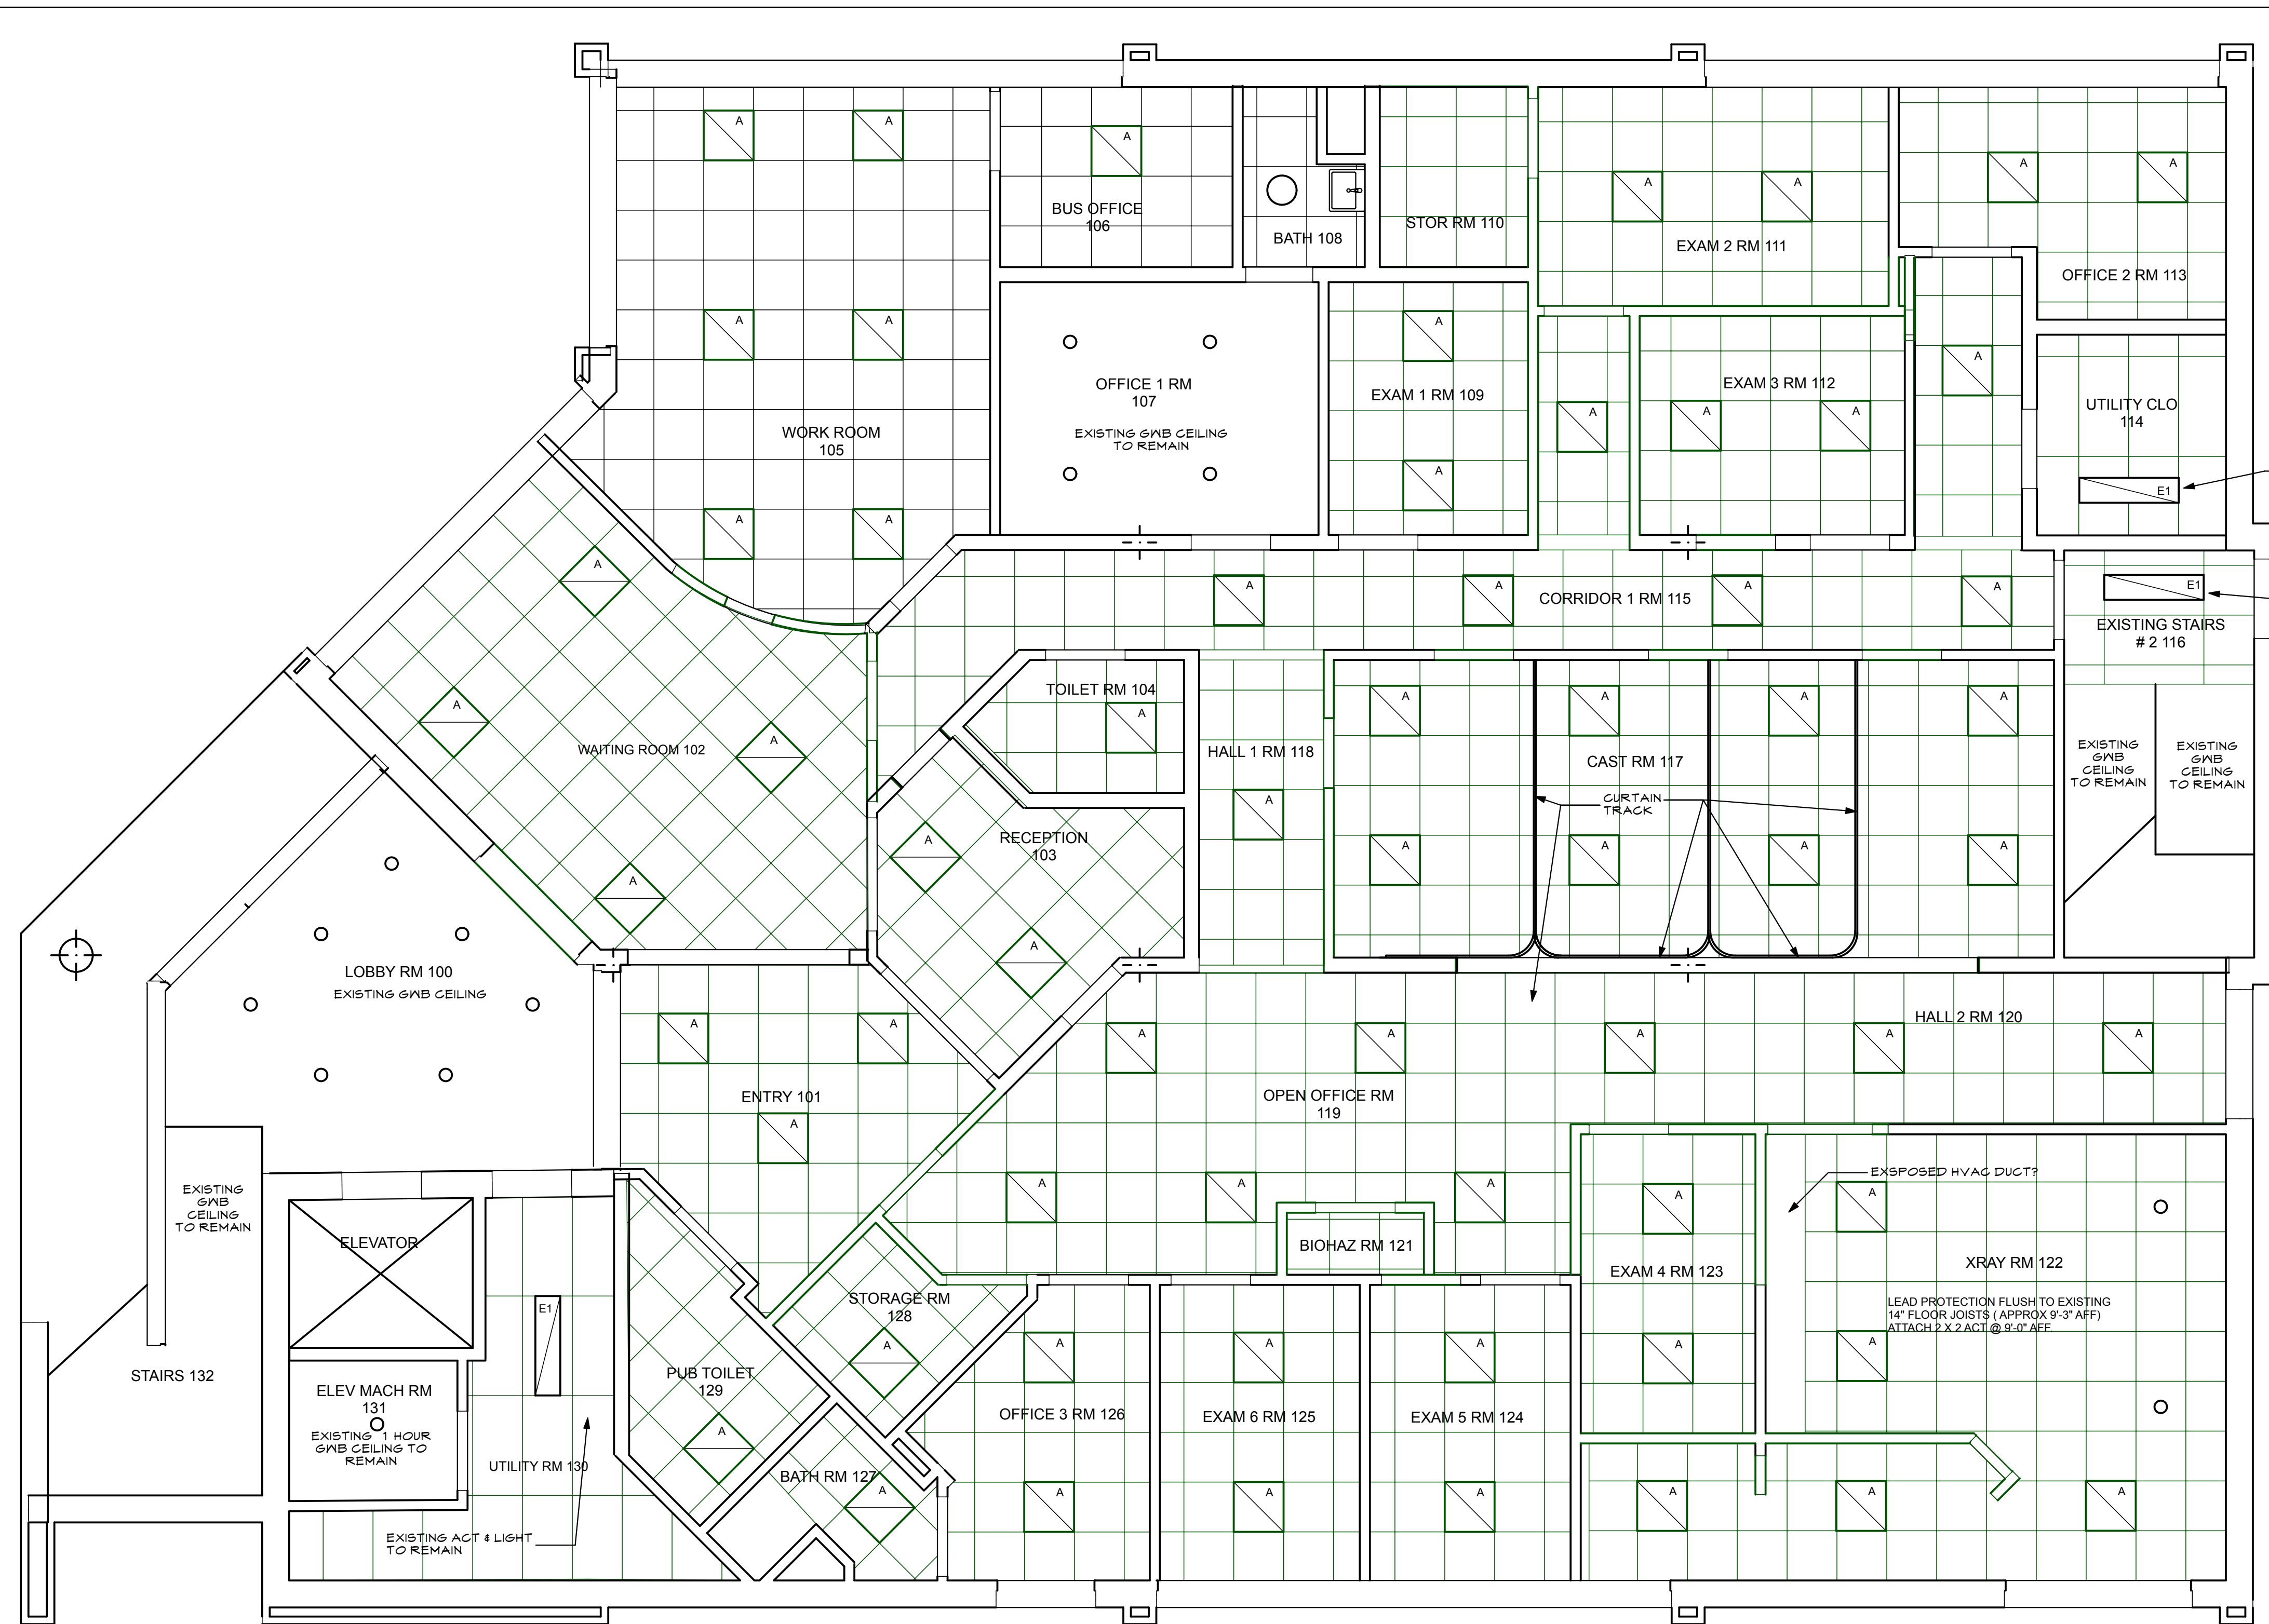


1
A1.4
FIRST FLOOR REFLECTED CEILING PLAN
SCALE: 1/4" = 1'-0"

- NOTES:**
- PROVIDE NEW HVAC DIFFUSERS AND RETURNS AS NECESSARY FOR NEW LAYOUT
 - ADD AND ADJUST SPRINKLER LAYOUT TO NEW FLOOR PLAN LAYOUTS WITH HEADS TO MATCH EXISTING.
 - REFERR TO X-RAY INSTALLER FOR

LIGHTING LEGEND						
SYMBOL	LABEL	DESCRIPTION	MANUFACTURER	CATALOG NUMBER	LAMPS	NOTES
	A	2 X 2 LED	COOPER LIGHTING-METALUX	22EN-LD1-34-UNV-L835-CD1-U	3500K LEDS	
	E1	1 X 4' EXISTING				REPLACE BULBS WITH NEW 3500K FLUORESCENT
	E2	2 X 4' EXISTING				

**MEDICAL OFFICES FOR
NEW ENGLAND FOOT & ANKLE
SPECIALISTS**
RENOVATIONS TO
117 AUBURN STREET
PORTLAND, MAINE
04103

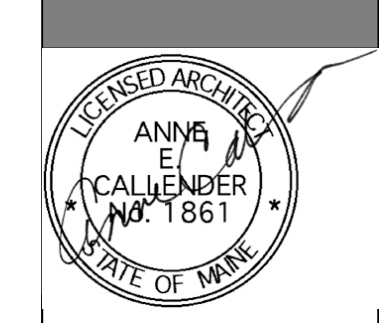

**WHIPPLE
CALLENDER
ARCHITECTS**

136 PLEASANT AVE.
PORTLAND, ME 04103
P 207.775.2696
F 207.775.3631
www.whipplecallender.com

DATE	DESCRIPTION
2-28-2017	ISSUED FOR STATE FIRE PERMIT
3-4-2017	ISSUED FOR PERMIT W/ SURVEY

DATE: 3/6/17
CHECKED BY: AEC
DRAWN BY: CLL
JOB: NEF
SHEET TITLE: REFLECTED CEILING PLANS

A1.4

THIS DRAWING IS AN INSTRUMENT OF SERVICE AND SHALL REMAIN THE PROPERTY OF WHIPPLE CALLENDER ARCHITECTS. IT SHALL NOT BE USED FOR ANY OTHER PURPOSE THAN THAT FOR WHICH IT IS SPECIFICALLY FURNISHED.