



©2011 STARBUCKS COFFEE COMPANY

STARBUCKS COFFEE COMPANY
2401 UTAH AVENUE SOUTH
SEATTLE, WASHINGTON 98134
(206) 318-1575

THESE DRAWINGS AND SPECIFICATIONS ARE CONFIDENTIAL AND SHALL REMAIN THE SOLE PROPERTY OF STARBUCKS CORPORATION, WHICH IS THE OWNER OF THE COPYRIGHT IN THIS WORK. THEY SHALL NOT BE REPRODUCED (IN WHOLE OR IN PART), SHARED WITH THIRD PARTIES OR USED IN ANY MANNER ON OTHER PROJECTS OR EXTENSIONS TO THIS PROJECT WITHOUT THE PRIOR WRITTEN CONSENT OF STARBUCKS CORPORATION. THESE DRAWINGS AND SPECIFICATIONS ARE INTENDED TO EXPRESS DESIGN INTENT FOR A PROTOTYPICAL STARBUCKS STORE (WHICH IS SUBJECT TO CHANGE AT ANY TIME) AND DO NOT REFLECT ACTUAL SITE CONDITIONS. NEITHER PARTY SHALL HAVE ANY OBLIGATION NOR LIABILITY TO THE OTHER (EXCEPT STATED ABOVE) UNTIL A WRITTEN AGREEMENT IS FULLY EXECUTED BY BOTH PARTIES.

T P G ARCHITECTURE
TPG Architecture, LLP
360 Park Avenue, South, New York, New York 10010
212 768 0800 212 768 1597 fax
www.tpgarchitecture.com

Frederic M. Strauss

ME License No. 4099
Architect of Record

Revision Schedule			
Rev	Date	By	Description

TO CONTACT AN INFORMATION TECHNOLOGY VENDOR REGARDING DATA CABELING, VOICE & NETWORK CIRCUITS, IT RACK AND/OR TURNING EQUIPMENT OFF FOR RELOCATION OR PAINTING, CONTACT VIA EMAIL: NEWSTORE@STARBUCKS.COM.

FF AND E PLAN NOTES

- A. GENERAL CONTRACTOR TO SCHEDULE WITH LOCAL REFRIGERATION CONTRACTOR TO CONDUCT INITIAL FOOD CASE START-UP AND TESTING. FOR APPROVED CONTRACTOR, CONTACT VENDOR.
- B. THE SPACE IS SERVED BY THE MUNICIPAL WATER AND SEWER SYSTEM UNLESS OTHERWISE NOTED.
- C. ALL EQUIPMENT AND INSTALLATION WILL MEET NATIONAL SANITATION FOUNDATION STANDARDS OR EQUIVALENT.
- D. EQUIPMENT UNITS SHALL CONTAIN NO EXPOSED THREADS, EMBELLISHMENTS OR OVERHANGING EDGES THAT SERVE AS PLACES FOR ACCUMULATION OF DUST, DIRT AND DEBRIS.
- E. WARMING OVEN(S) SHOWN FOR PERMITTING PURPOSES. INSTALLATION AT STORE OPENING TO BE VERIFIED BY STARBUCKS CONSTRUCTION REPRESENTATIVE.
- F. EACH HAND WASHING SINK WILL HAVE A SINGLE SERVICE TOWEL AND SOAP DISPENSER, AND ALL HAND SINKS TO HAVE A COMBINATION FAUCET OR PREMIXING FAUCET.
- G. FOR PLUMBING FIXTURES, REFER TO THE PLUMBING DESIGN PLAN. FOR DATA DEVICE SCHEDULE, REFER TO THE ELECTRICAL DESIGN PLAN

SHEET NOTES

- 1. GENERAL CONTRACTOR TO REVERSE DOOR HINGE ON UNDER COUNTER REFRIGERATOR TO RIGHT-HAND SWING, AS SHOWN.
- 2. SEE ELEVATIONS FOR DISTRIBUTION OF CUP DISPENSERS.
- 3. RELOCATED SHUTTLE (2).
- 4. RELOCATED BREWER.
- 5. RELOCATED GRINDER.
- 6. RELOCATED SCALE.
- 7. RELOCATED ESPRESSO MACHINE (2).
- 8. RELOCATED 2-DOOR UC FRIDGE.
- 9. RELOCATED 1-DOOR UC FRIDGE (2).
- 10. NEW 54" PASTRY CASE.
- 11. RELOCATED SAFE AND BASE.
- 12. RELOCATED NEW YORK TIMES STAND.
- 13. RELOCATED MERCH BASKET AND FEATURE CUBE.
- 14. RELOCATED BLENDERS (2).
- 15. RELOCATED BANNER.
- 16. NEW MERCH BAY (2).
- 17. RELOCATED POS & EQUIPMENT. RELOCATED EXISTING POS EQUIPMENT. STARBUCKS CONTRACTS DIRECTLY WITH DATA CABELING VENDOR TO SPPLY, INSTALL OR RELOCATE CAT 5 LAN CABELING FOR THEIR POS SYSTEMS. CONTRACTOR MUST SCHEDULE THROUGH THE STARBUCKS RENOVATION CONSTRUCTION MANAGER A MINIMUM OF TWO WEEKS PRIOR TO NEED.
- 18. NEW WATER FILTRATION (CONFIG 1).
- 19. RELOCATED WARMING OVEN.
- 20. EXISTING DROP-IN WORK SINK TO REMAIN.

FF&E RESPONSIBILITY LEGEND

GC	PROVIDED BY GENERAL CONTRACTOR
LL	PROVIDED BY LANDLORD
VD	PROVIDED BY VENDOR
WH	PROVIDED BY STARBUCKS WAREHOUSE

NOTE: ALL RESPONSIBILITIES TO BE CONFIRMED WITH STARBUCKS DM PRIOR TO ORDERING / CONSTRUCTION.

SPECIALTY EQUIPMENT SCHEDULE - "E"				
DESIGN ID	COUNT	DESCRIPTION	RESP.	COMMENTS
10384	2	Diaper Changing Station - Horizontal	WH	
X0500	2	HAND DRYER/ W SHARED PLANET LOGO	VD	MFR: EXCEL DRYER, MODEL: XL-GR 110/120V, 12.5AMP, GREY, CONTACT: NEWTON DISTRIBUTION, KEITH@NEWTONDISTRIBUTING.COM

FOOD CASE				
DESIGN ID	COUNT	DESCRIPTION	RESP.	COMMENTS
10154	1	FOOD CASE - STACKED - 54IN 1370MM - BLACK	WH	
12394	1	FOOD CASE - UPRIGHT - 46IN 1170MM - BLACK	WH	

ICE				
DESIGN ID	COUNT	DESCRIPTION	RESP.	COMMENTS
10344	1	ICE - BIN DROP IN 90LB 40KG	VD	ELKAY: www.elkayusa.com/

OTHER				
DESIGN ID	COUNT	DESCRIPTION	RESP.	COMMENTS
10091	1	CUP DISPENSER TALL HOT VERTICAL	WH	
10396	1	CUP DISPENSER SHORT HOT VERTICAL	WH	
10791	2	CUP DISPENSER GRANDE VENTI COLD VERTICAL	WH	
10855	2	CUP DISPENSER GRANDE VENTI HOT VERTICAL	WH	
10858	1	CUP DISPENSER TALL COLD VERTICAL	WH	
13330	1	MOBILE CUP DISPENSER CADDY	WH	
13584	1	CUP DISPENSER TRENTA COLD VERTICAL	WH	
X0505	4	WOOD TRIM	VD	By Casework Vendor - See Casework Finish Schedule

PLUMBING FIXTURE SCHEDULE - "P"				
DESIGN ID	COUNT	DESCRIPTION	RESP.	COMMENTS
DRAIN				
10726	1	Drain - Grate Half Square - 12in 305mm	WH	
FAUCET				
10153	1	FAUCET - WATER TOWER - 12IN 305MM	WH	
10215	2	FAUCET - DOUBLE LABORATORY WITH SWING SPOUT	WH	
10874	1	FAUCET - HOT WATER DISPENSER GOOSENECK	WH	
10943	1	FAUCET - SINGLE LABORATORY WITH SWING SPOUT	WH	
11003	1	FAUCET - DIPPERWELL	WH	
FILTER				
13080	2	FILTER - HEAD QUAD	VD	PENTAIR
13081	8	FILTER - CARBON FILTER CARTRIDGE	VD	PENTAIR
SINK				
10294	1	DRAIN - Floor Sink Square - 12IN 305MM	WH	


GRAPHICS SCHEDULE - "G"				
DESIGN ID	COUNT	DESCRIPTION	RESP.	COMMENTS
GRAPHICS - ARTWORK				
10566	1	PAPER BLOCKS - STAMPS - 31X40IN 785X1015MM	VD	CAFFE VERONA STAMP - STANDARD ARTWORK (READY TO HANG)
11844	1	PAPER BLOCKS - STAMPS - 31X40IN 785X1015MM	VD	ESPRESSO ROAST STAMP - STANDARD ARTWORK (READY TO HANG) - CUSTOM SIZE

GRAPHICS - INTERIOR MENU				
DESIGN ID	COUNT	DESCRIPTION	RESP.	COMMENTS
12837	4	MENU BOARD - 1 FRONT PANEL INSERT STYLE	WH	
12838	1	MENU BOARD - DAILY OFFERING CHALKBOARD FRONT PANEL RECTANGULAR	WH	
12839	5	MENU BOARD - UNIVERSAL MOUNTING HARDWARE FOR FRONT PANELS	WH	


GRAPHICS - OTHER				
DESIGN ID	COUNT	DESCRIPTION	RESP.	COMMENTS
10753	2	RESTROOM SIGN SET ACCESSIBLE	VD	
X0312	1	ART WORK	VD	3" wood frame. See casework finish schedule. Graphic vendor to coordinate with design manager on final selection of artwork.
X0313	4	CUSTOM ARTWORK FRAME -BY DM	VD	3" wood frame. See casework finish schedule. Graphic vendor to coordinate with design manager on final selection of artwork.
X0501	1	CHALK BOARD- PAINT Benjamin moore -BM307	VD	2" wood frame. See casework finish schedule.
X0502	1	COMMUNITY BOARD MAGNETIC MED WARM BROWN WD0004 - 46X36IN 1170X915MM	VD	

SIGNAGE SCHEDULE - "S"				
DESIGN ID	COUNT	DESCRIPTION	RESP.	COMMENTS
SIGNAGE - DISK				
X0060	2	SIGN - DISK DF ILLUMINATED SUSPENDED EVOLVED - 24IN 610MM	VD	REMOVE EXISTING VINYL GRAPHIC AND ACRYLIC'S FROM EXISTING LOGO SIGN, BOTH SIDES. PRESERVE SIGN CASING AND HARDWARE FOR REUSE WITH NEW VINYL GRAPHIC AND ACRYLIC. REMOVE LIGHT IN PREPARATION FOR NEW LED FIXTURE. BY HILTON DISPLAYS.

FURNITURE SCHEDULE - "F"				
DESIGN ID	COUNT	DESCRIPTION	RESP.	COMMENTS
10093	2	Mirror - Restroom - 18x30in	GC	
12330	2	CHAIR - LOUNGE BARRELBACK - BRICK RED NATURAL F0017	WH	Fabric - Dark Brick Red Natural, ID: F0017; Wood - Warm Brown Medium Tone, ID: WD0004
X0310	1	Custom Banquette with Fabric-F0017 : Thin Padded Seat	VD	
CHAIR				
12149	4	CHAIR - CAFE SLATTED METAL SUITE - BLACK MT0029	WH	
12282	7	CHAIR - CAFE BENT PLYWOOD - AMBER HONEY WD0005	WH	
13368	6	CHAIR - STOOL 29IN 735MM INDUSTRIAL - DISTRESSED DARK BROWN PRESSBOARD WD0012	WH	
13570	6	CHAIR - BACK FOR INDUSTRIAL STOOL - ANTIQUE PEWTER MT0034	WH	
TABLE				
12160	1	TABLE - ACCESSIBLE METAL SUITE - 39X23IN 990X585MM - BLACK MT0028	WH	
12161	1	TABLE - CAFE METAL SUITE SQUARE - 30IN 760MM - BLACK MT0028	WH	
12187	5	TABLE - BASE CAFE DOME ACCENT - 18X28IN 455X710MM - HOT ROLLED STEEL MT0011	WH	
12212	3	TABLE - BASE BAR HEIGHT DOME ACCENT - 18X42IN 455X1065MM - HOT ROLLED STEEL MT0011	WH	
12241	1	TABLE - ACCESSIBLE METAL STRAP BASE - 38X24IN 965X610MM - AMBER HONEY WD0005	WH	
12304	8	TABLE - TOP WITH SCORED LINES - 24IN 610MM - HOT ROLLED STEEL MT0011	WH	
12379	1	TABLE - OCCASIONAL X BASE - AGED DARK BROWN CM0001	WH	

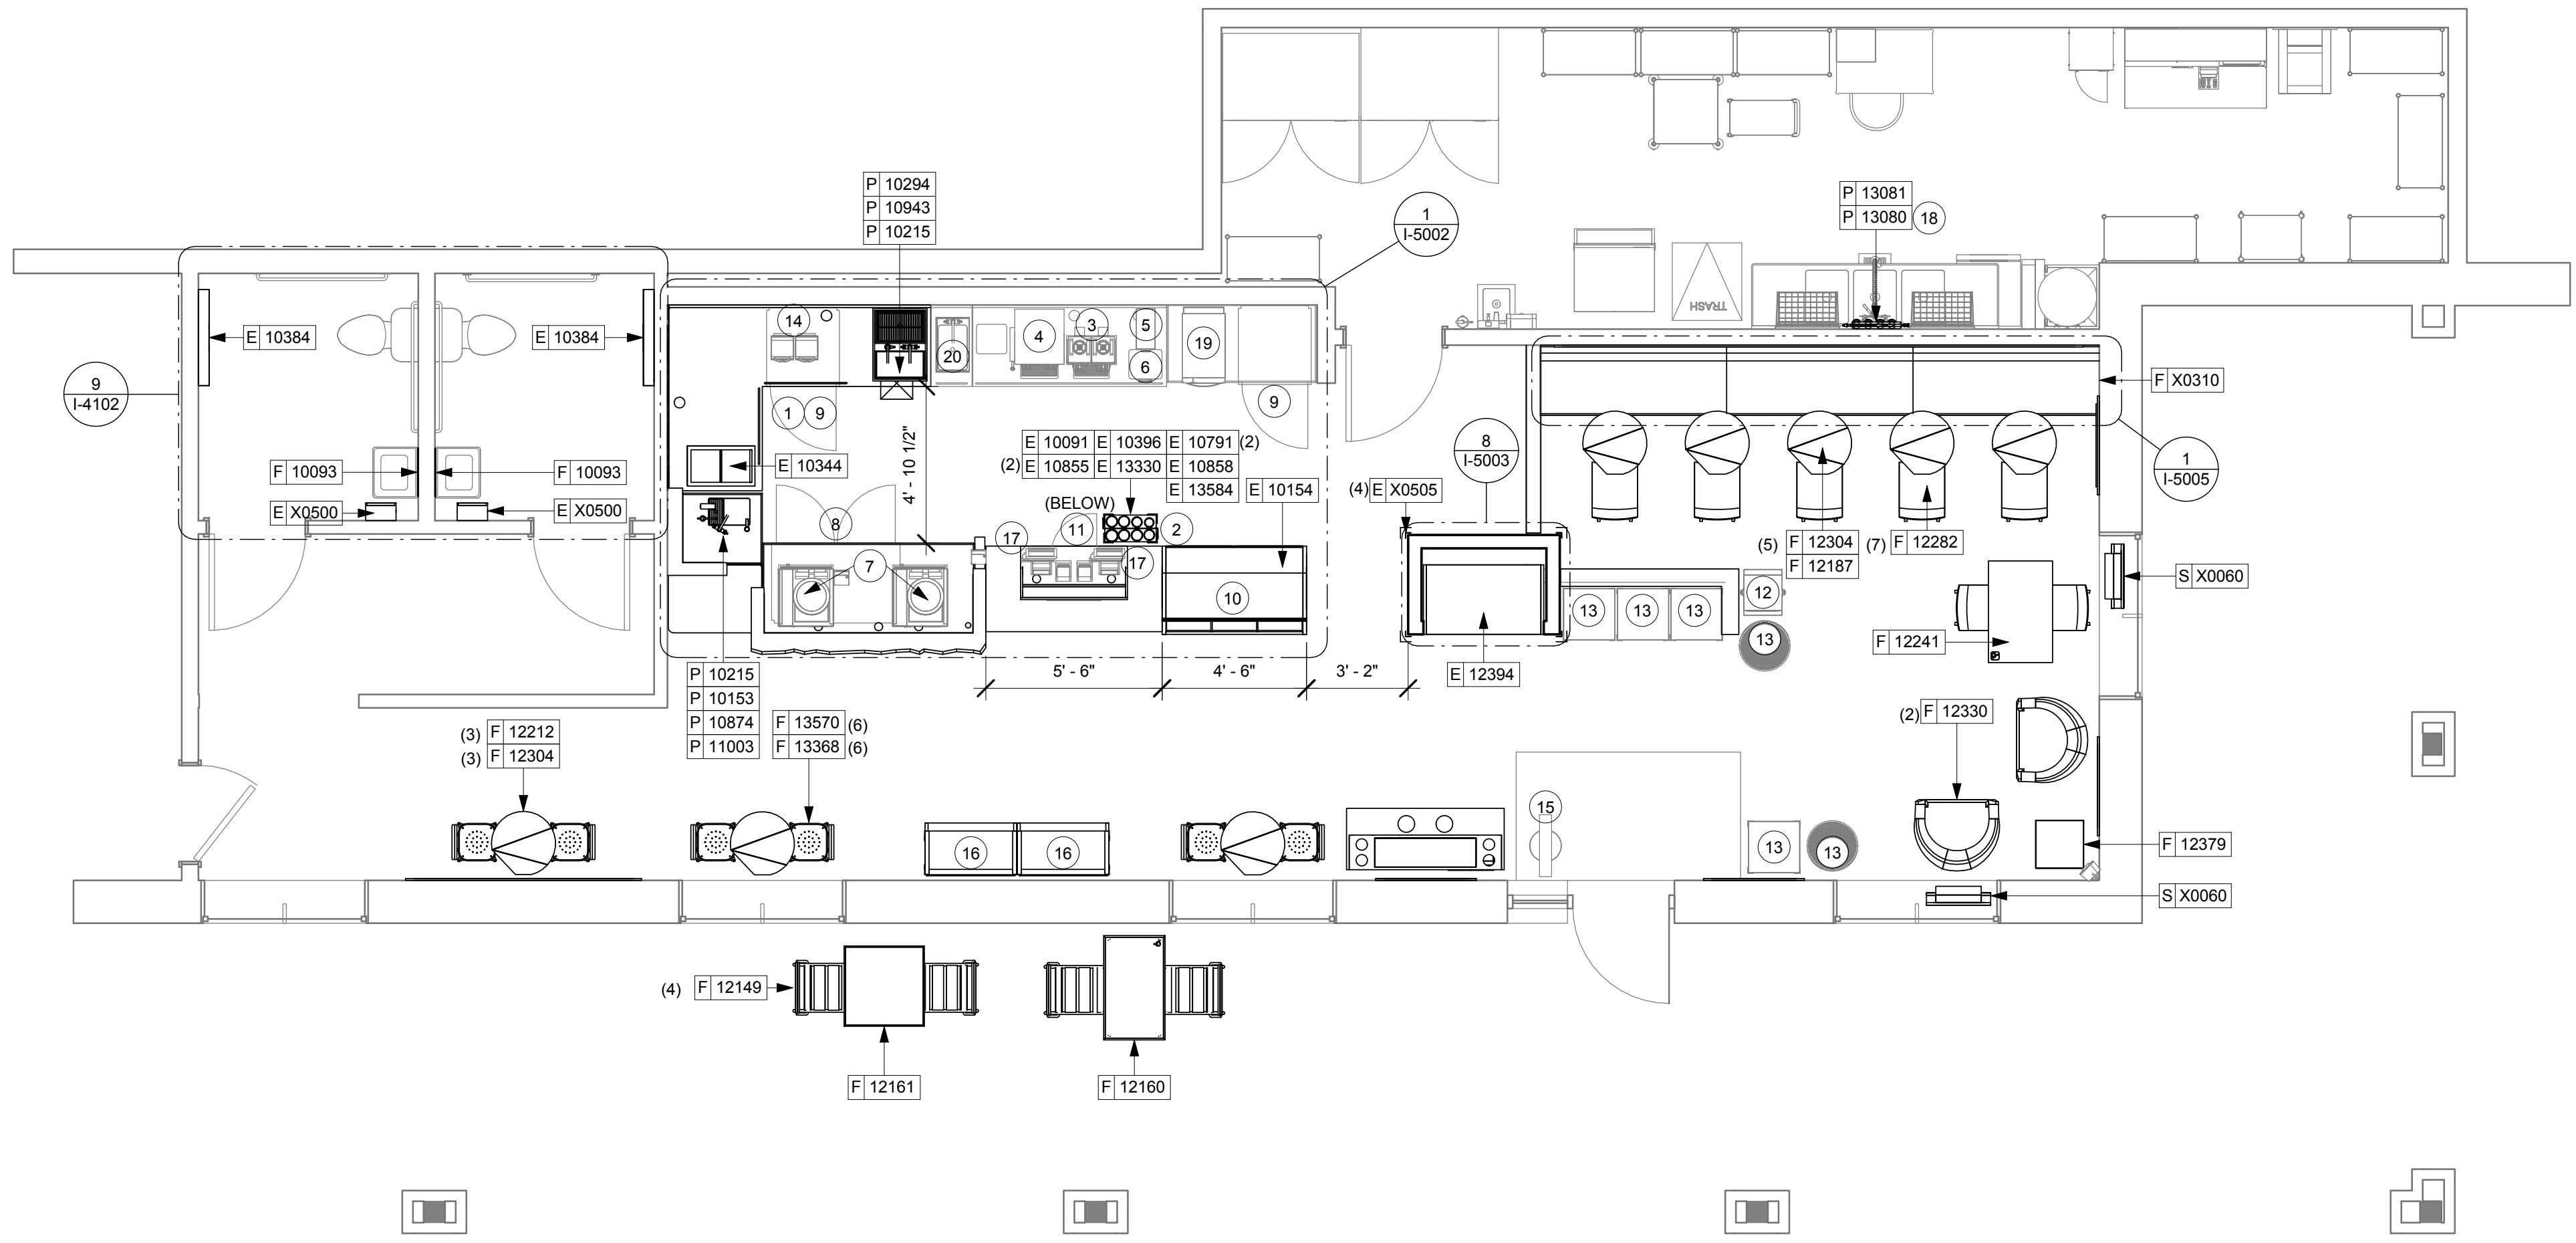

1ST FLOOR - FURNITURE, FIXTURES, AND EQUIPMENT PLAN
Scale: 1/4" = 1'-0"

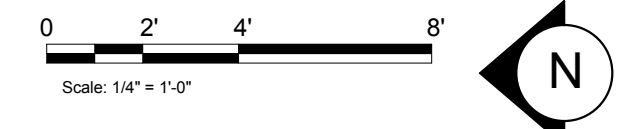

1/20/2014 12:58:01 PM G:\1311513889-00\Arch\Archive\OUT\2014-1-20 DOBNORTHGATE_CD_DOB.rvt

PROJECT NAME:
NORTHGATE PLAZA
PROJECT ADDRESS:
**91 AUBURN STREET,
PORTLAND ME 04103**

STORE #: 2830
PROJECT #: 22764-021
CONCEPT:
PALETTE:
ISSUE DATE: 12/19/2013
DESIGN MANAGER: Eta Kliger
LEED® AP:
PRODUCTION DESIGNER: AH
CHECKED BY: Allison Stadnyck

SHEET TITLE:
FF AND E PLAN

SCALE: 1/4" = 1'-0"

SHEET NUMBER:
I-1105