


J:\2009\80766-00\0_Drawings\Plans-AutoCAD\Plumbing_FP\80766-00_P-1.1.dwg Sep 01, 2009 - 3:41 pm RMP

PLUMBING SUBCONTRACTOR SHALL PROVIDE A WATER TIGHT PENETRATION FOR THE IRRIGATION SUBCONTRACTOR IN RECEIVING AREA NEAR DOMESTIC WATER METER. PROVIDE REDUCE PRESSURE BACKFLOW PREVENTER, COORDINATE SIZE AND LOCATION WITH IRRIGATION SUBCONTRACTOR PRIOR TO INSTALLATION.
 (PLUMBING SUBCONTRACTOR SHALL COORDINATE EXACT LOCATION OF PENETRATION WITH IRRIGATION SUBCONTRACTOR AND ARCHITECT PRIOR TO INSTALLATION.)

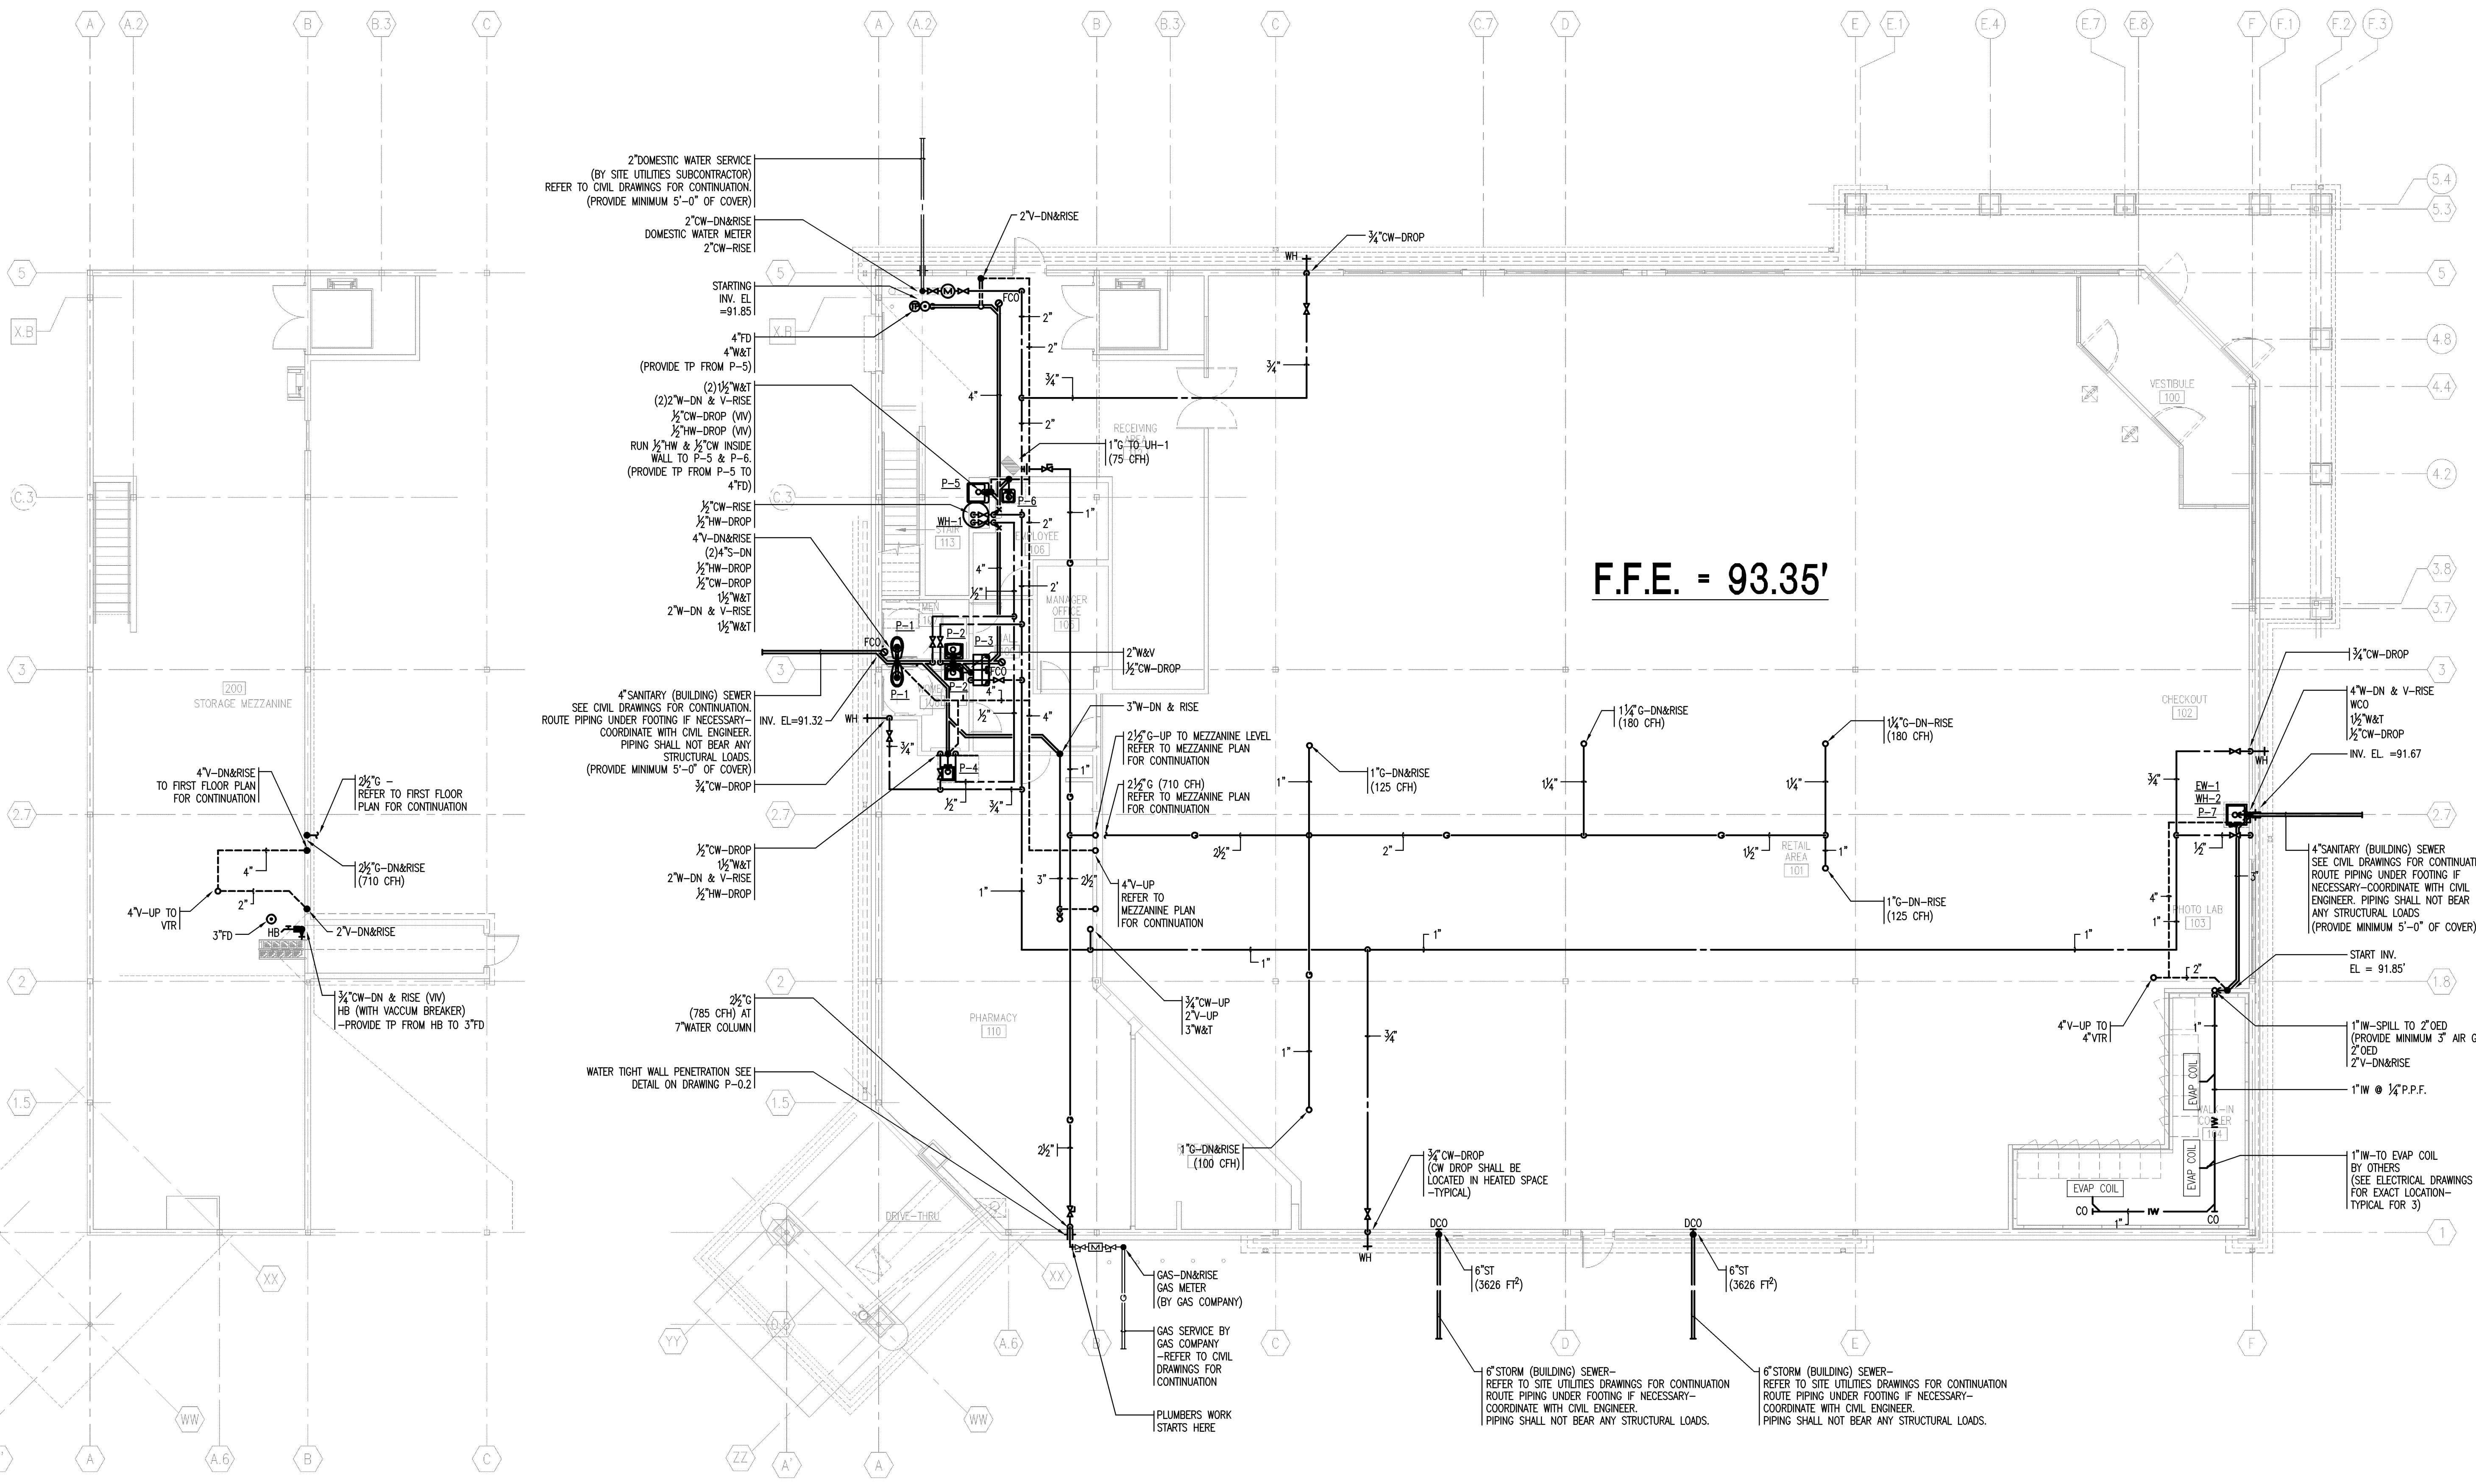

2 PLUMBING MEZZANINE PLAN
 P-1.1 SCALE: 1/8"=1'-0"

1 PLUMBING FIRST FLOOR PLAN
 P-1.1 SCALE: 1/8"=1'-0"

bka
BKA Architects, Inc.
 Architecture + Interiors
 142 Crescent Street
 Brockton, MA 02302
 tel : 508.583.5603
 fax : 508.584.2914
 e-mail : bka@bkaarch.com

CONSULTANT:
RWS R. W. Sullivan Engineering
 HVAC, Electrical, Plumbing, Fire Protection, Code
 The Sprague Center, 539 Main St., Suite 203
 Boston, Massachusetts 02202-1101
 Phone: (617) 533-8227 Fax: (617) 533-8016
 www.rwsusa.com
 RWS-JCB # 80766.00

SEAL:

CVS/
pharmacy
 NEW
 STORE NUMBER: 329
 NORTHGATE PLAZA
 91 AUBURN STREET
 PORTLAND, MAINE

DEVELOPER:
 A & D REALTY, LLC
 5 MILITIA DRIVE
 LEXINGTON, MA 02421

REVISIONS:

DRAWING BY: RMP
 DATE: 8/31/09
 JOB NUMBER: 209017
 TITLE: PLUMBING FIRST & MEZZANINE FLOOR PLAN
 SHEET NUMBER: P-1.1
 COMMENTS:
 ISSUED FOR CONSTRUCTION

© 2009 by BKA Architects, Inc. The construction plan, schedule, quantities and other information on this sheet are not valid unless the project is approved by the appropriate authority and the project is within the scope of BKA Architects, Inc. No part thereof shall be copied, distributed to others, or used in connection with any work or project, other than the specific project for which they have been prepared and developed, without the express knowledge and written consent of BKA Architects, Inc.