

MAY 3, 2012


Bldg. Elevations

DRAWING SHEETS

A1 First & Second Floor Plans  
A2 Bldg. Elevations, Sched.  
A3 Building Sections  
A4 Lighting Plans

PERMIT

A-2

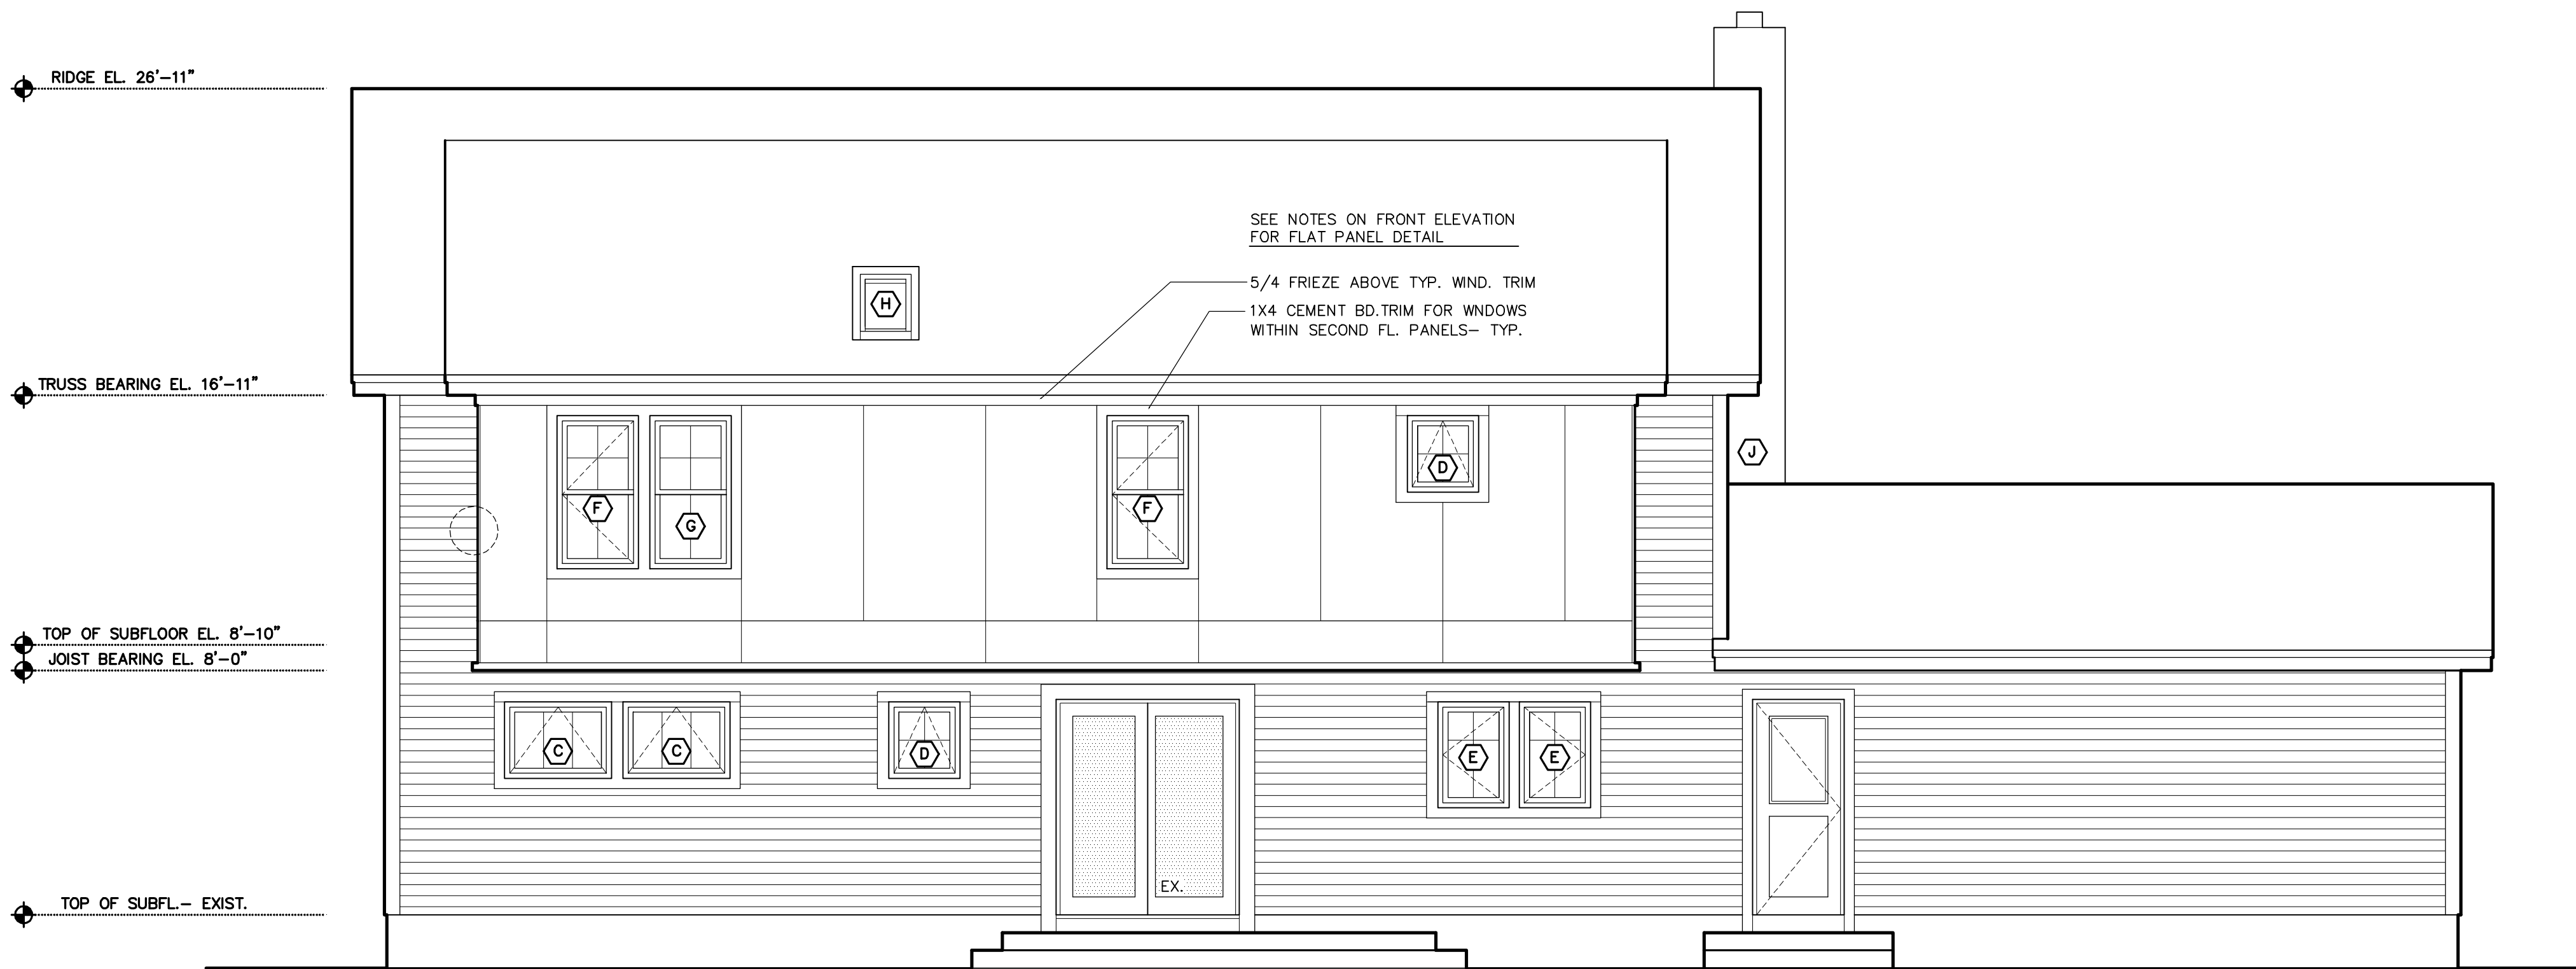


01 SOUTH ELEVATION (REAR)  
scale: 1/4"= 1'-0"


WINDOW SCHEDULE		PARADIGM WINDOW: COLOR: WHITE (TYP.) W/ WHITE SCREENS GRILLES: AS SHOWN GLASS- LOW E, INSULATED GLASS			
SYMBOL	QTY.	WINDOW UNIT SIZE (W X H)	SILL/ HEAD	TYPE	UNIT NUMBER OR GENERAL NOTES
A	5	3'-0" X 5'-0"	7'-0" HEAD	DOUBLE HUNG	SNAP APPLIED 4" FLAT CASING BY PARADIGM FOR ALL WINDOWS WITHIN VINYL SIDING CEMENT BD. CASING FOR WINDOWS WITHIN FLAT PANELS- SEE ELEVATIONS
B	6	2'-8" X 2'-8"	7'-0" HEAD	AWNING	
C	2	3'-6" X 2'-6"	7'-0" HEAD	AWNING	
D	2	2'-4" X 2'-6"	7'-0" HEAD	AWNING	
E	2	2'-4" X 3'-6"	7'-0" HEAD	CASEMENT	
F	5	2'-8" X 5'-0" (EGRESS)	7'-3" HEAD	CASEMENT	
G	1	2'-8" X 5'-0"	7'-3" HEAD	DOUBLE HUNG	
H	5	1'-9" X 3'-9-3/4" (R.O.)	SEE SECTION	ROOF WND.	VELUX VSE C06 (ELEC. OPER. W/ RAIN SENSOR)
J	1	2'-0" X 2'-0"	7'-3" HEAD	AWNING	VERIFY LOCATION W/ GARAGE ROOF

DOOR SCHEDULE		UNIT NUMBER OR GENERAL NOTES
NUMBER	DOOR SIZE (W x H)	
D101	3'-0" X 7'-0"	THERMA-TRU SMOOTH-STAR FIBERGLASS S601 (CONFIRM 7'-0" DOOR HT.) (SUBSTITUTE AS NECESSARY TO GET 7'-0" HT.)

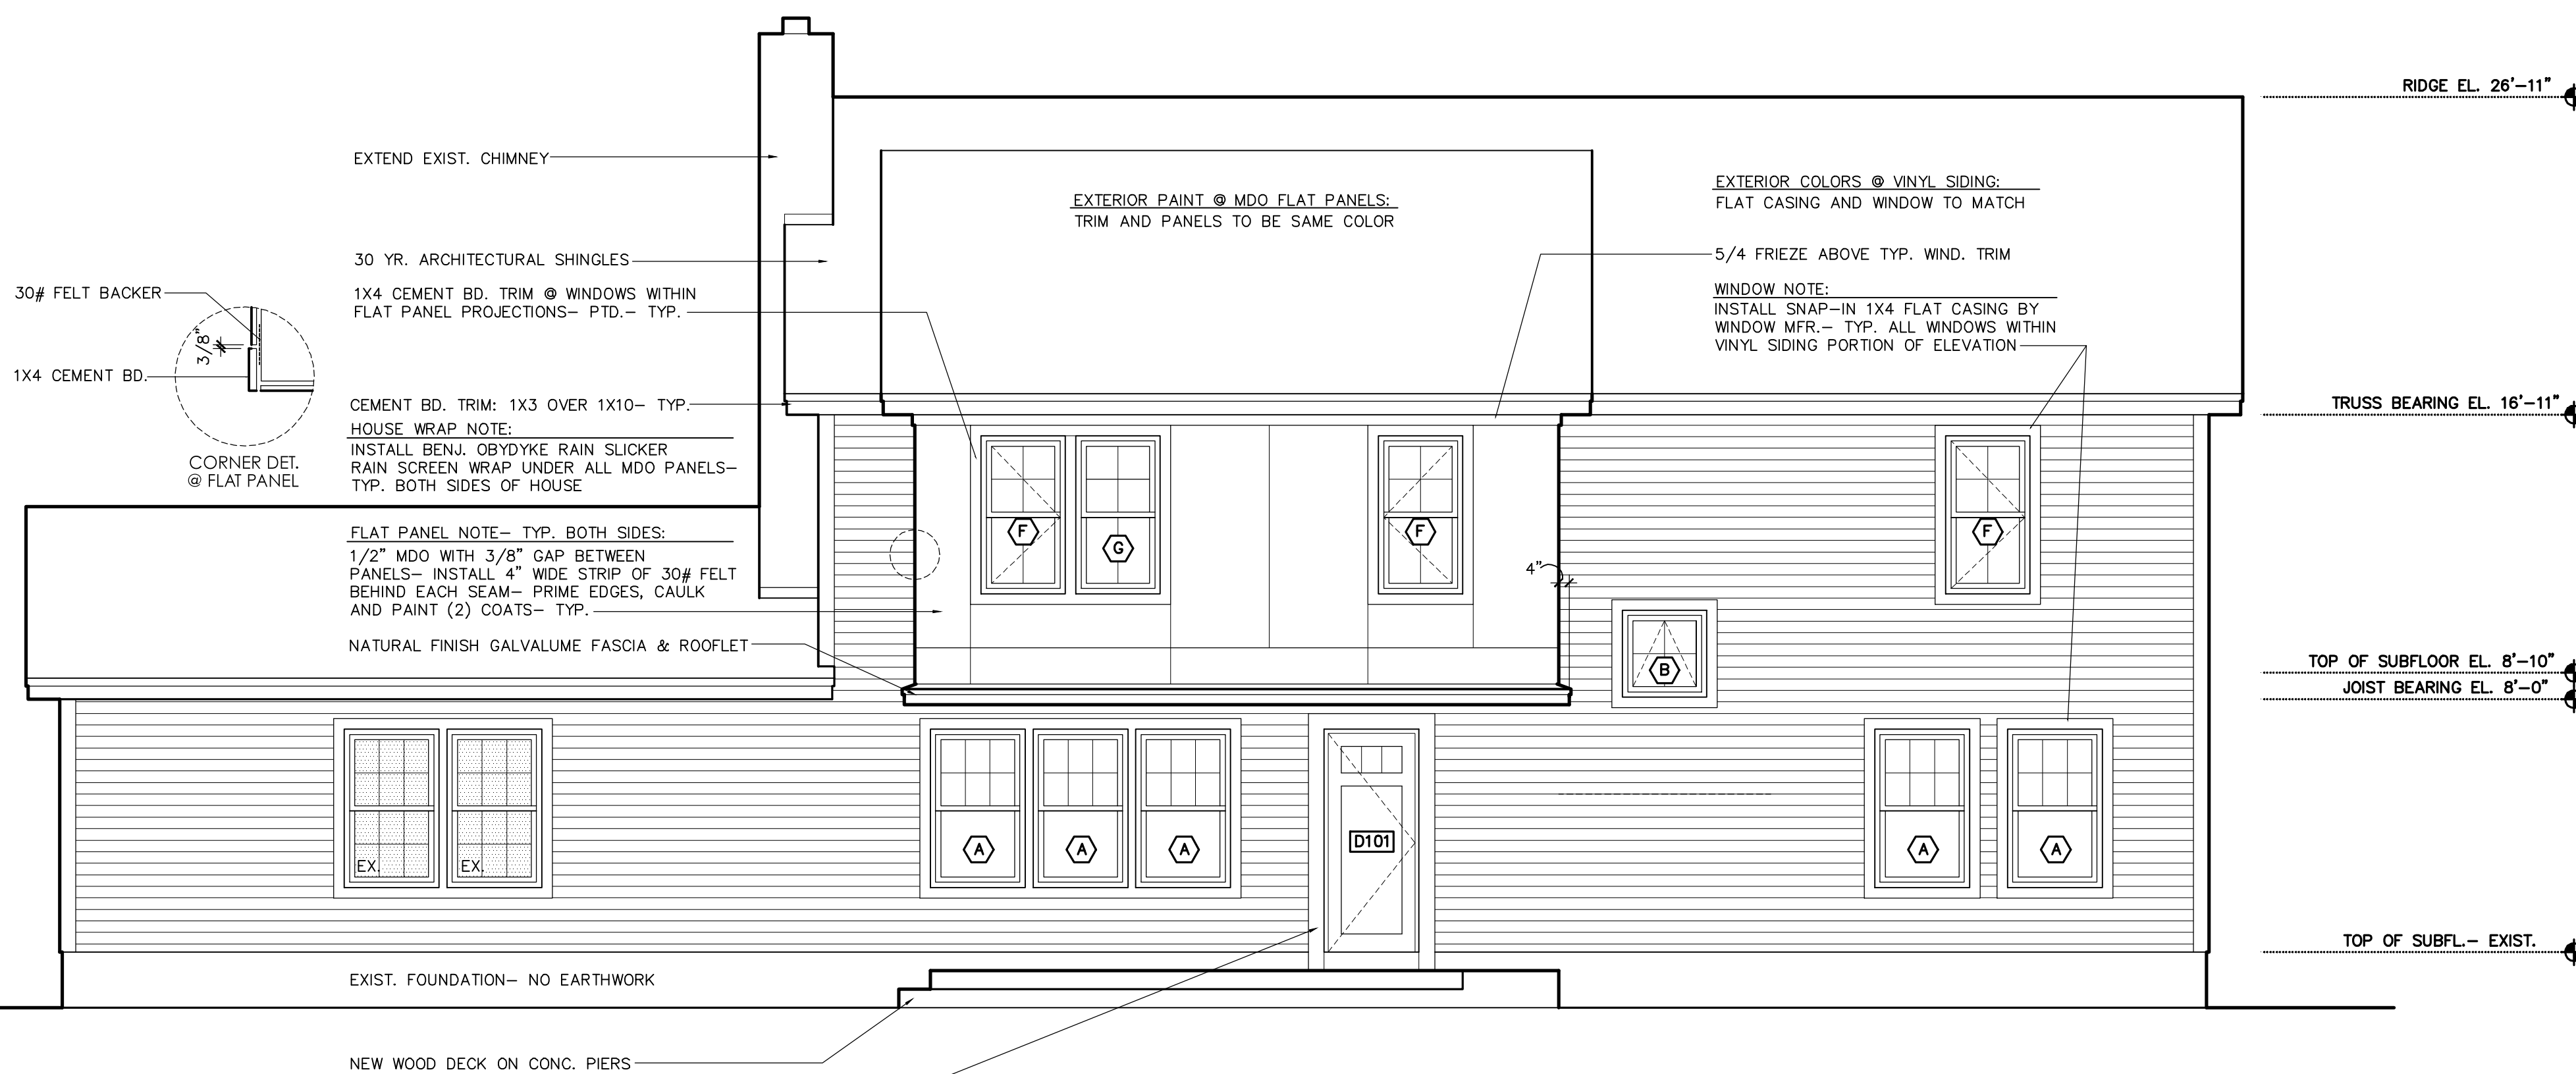

02 NORTH ELEVATION (FRONT)  
scale: 1/4"= 1'-0"

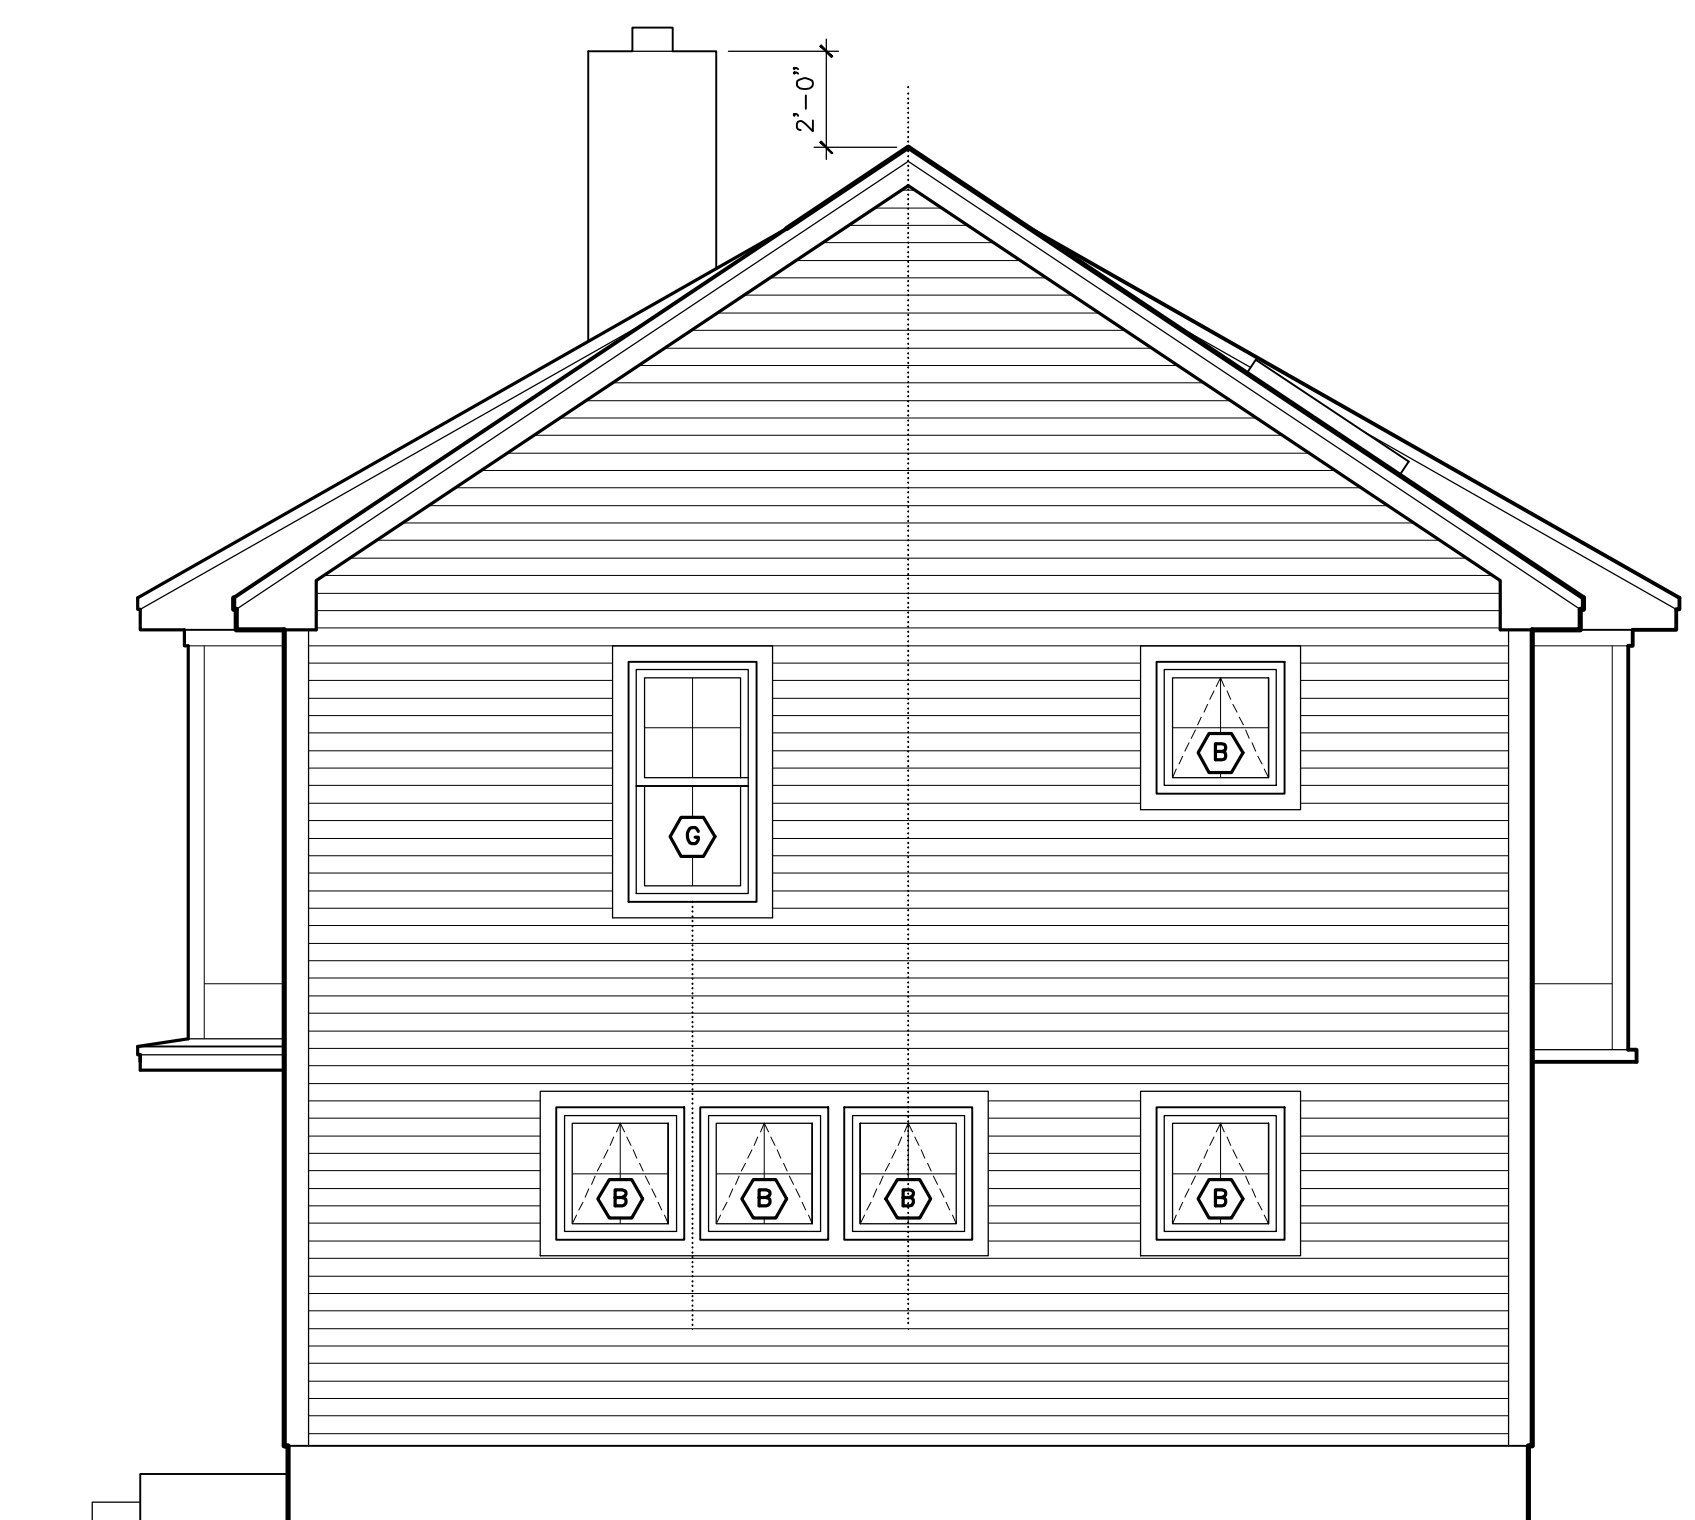

03 WEST ELEVATION (SIDE)  
scale: 1/4"= 1'-0"